


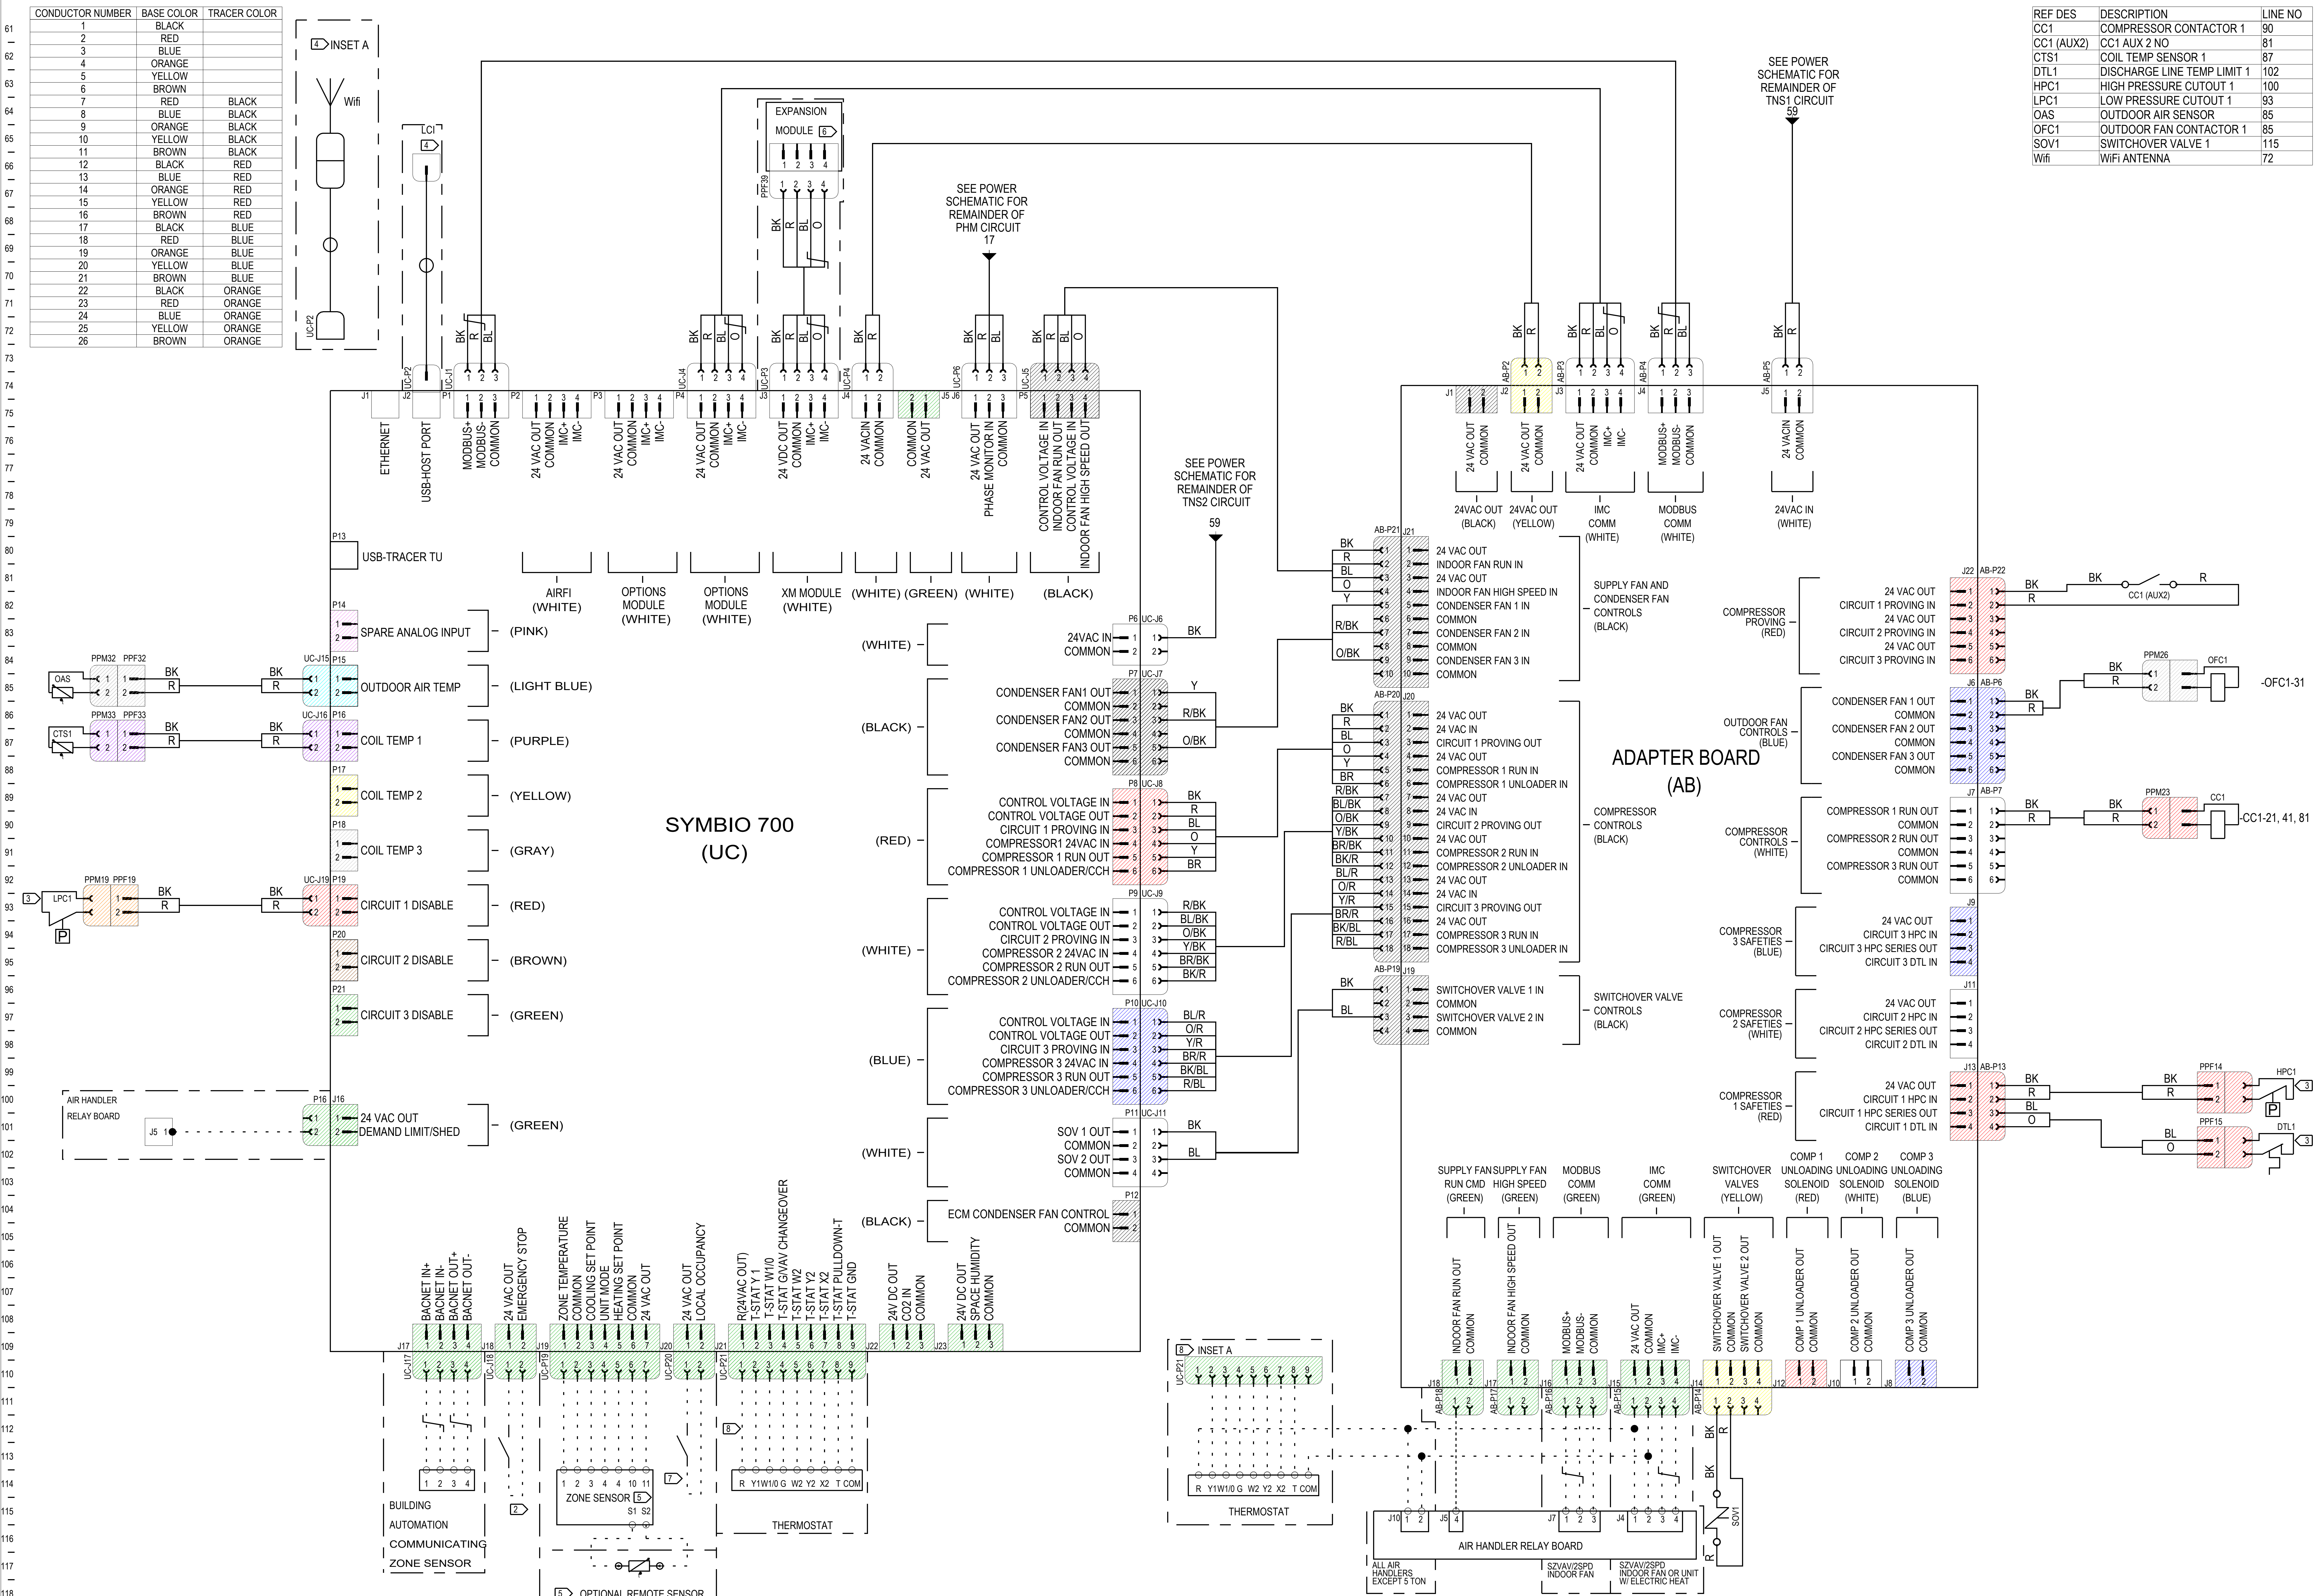

REF DES	DESCRIPTION	LINE NO
CC1	COMPRESSOR CONTACTOR 1	90
CC1 (AUX2)	CC1 AUX 2 NO	81
CTS1	COIL TEMP SENSOR 1	87
DTL1	DISCHARGE LINE TEMP LIMIT 1	102
HPC1	HIGH PRESSURE CUTOUT 1	100
LPC1	LOW PRESSURE CUTOUT 1	93
OAS	OUTDOOR AIR SENSOR	85
OFC1	OUTDOOR FAN CONTACTOR 1	85
SOV1	SWITCHOVER VALVE 1	115
Wifi	WIFI ANTENNA	72

DESIGNER: R JOHNSON
ENGINEER: D MCGREGOR
TRANE © DATE: 8/7/2019
REPLACES:
SIMILAR TO:
REVISION DATE: 12/06/2019
REVISED BY: R JOHNSON
APPROVED BY: D MCGREGOR
CAD SYSTEM USED: CREO SCHEMATIC

TRANE

THIS DRAWING IS PROPRIETARY AND SHALL NOT BE COPIED OR ITS CONTENTS DISCLOSED TO OUTSIDE PARTIES WITHOUT THE WRITTEN CONSENT OF TRANE.

ODYSSEY
DIAGRAM
CONTROLS SCHEMATIC, HEAT PUMP
SINGLE COMPRESSOR
SINGLE FAN

MASTER NUMBER:	DRAWING NUMBER:	SHEET:	REV
	12132982	2 OF 2	B