


1
2
3
60

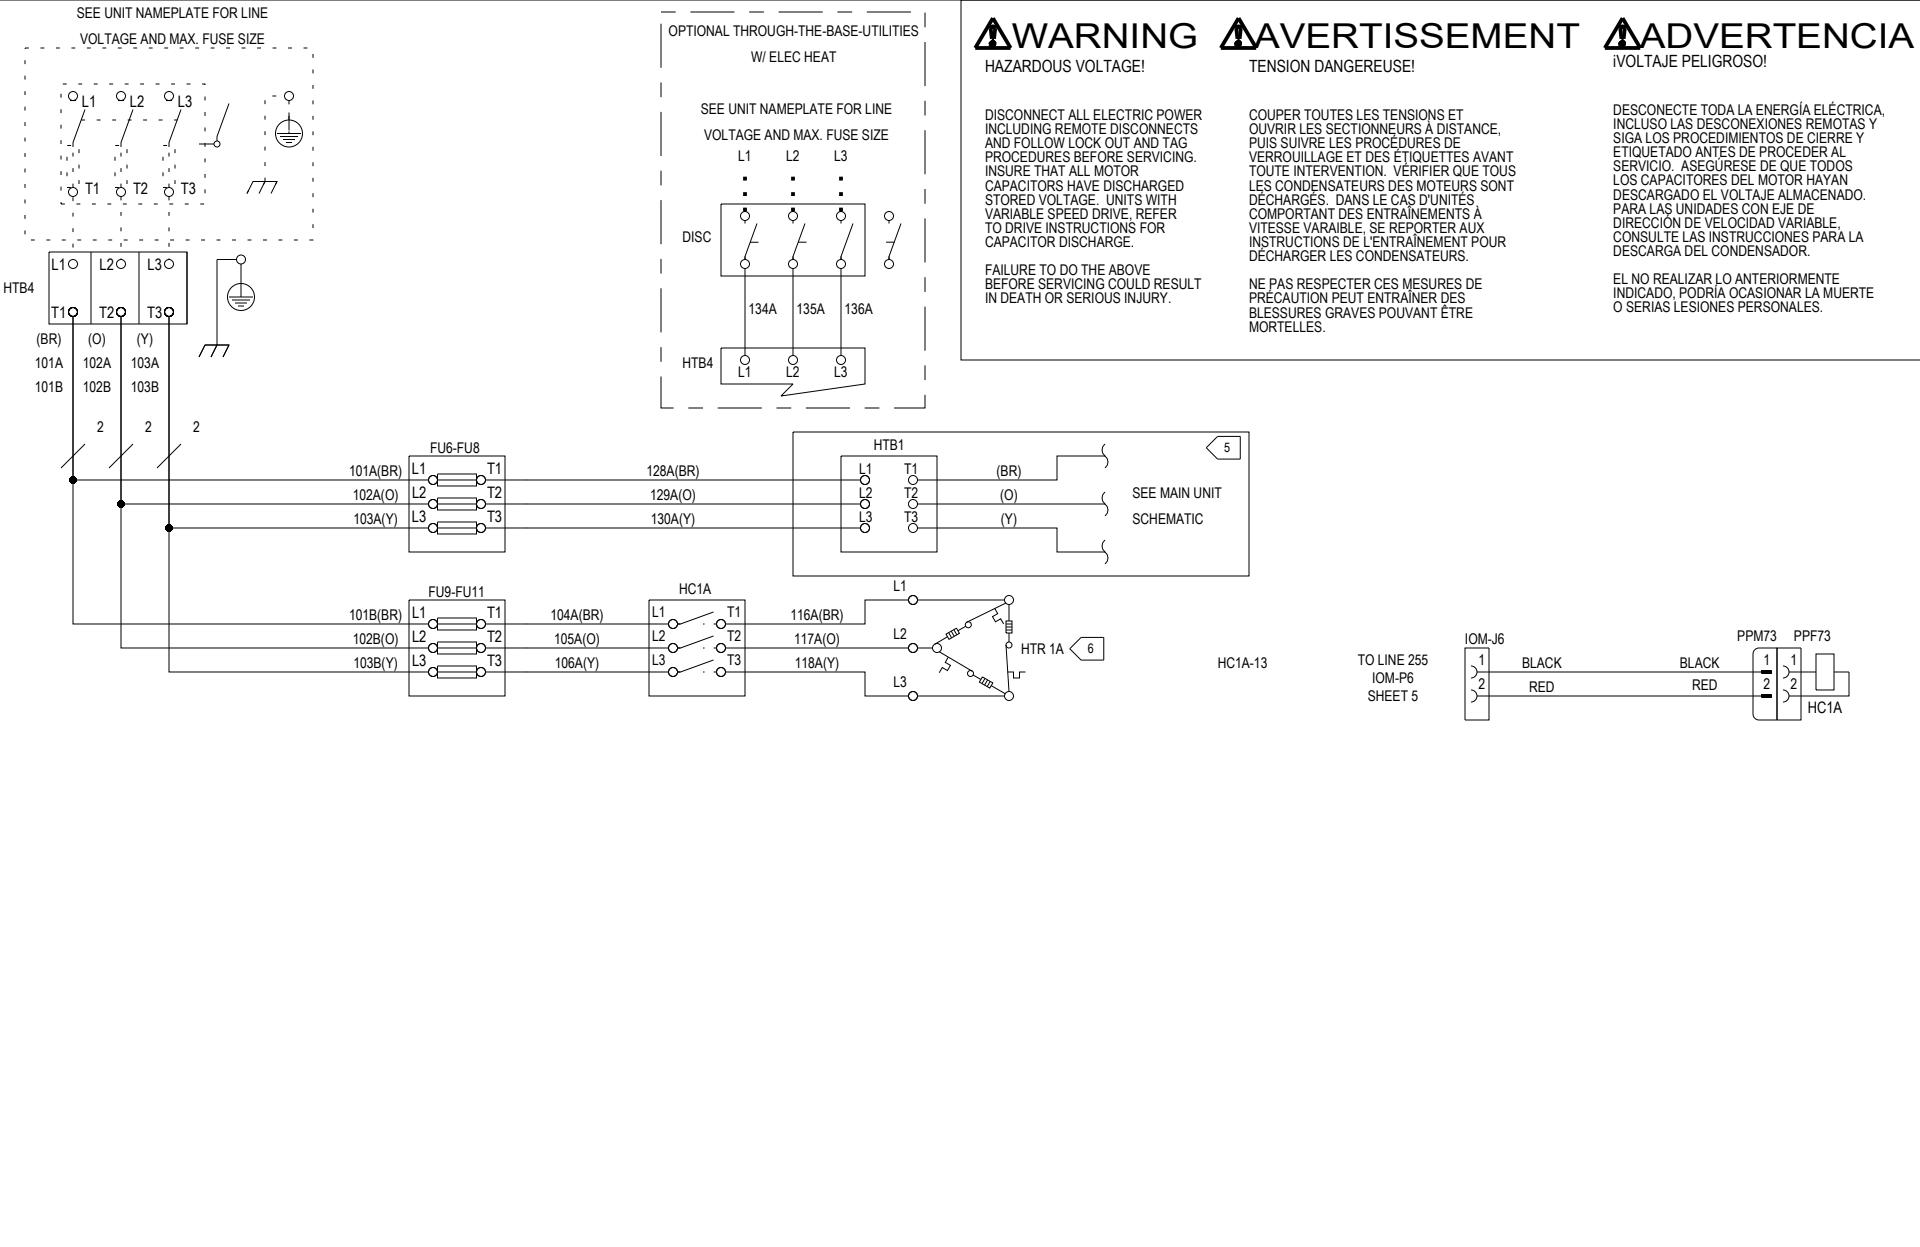

- NOTES:
- UNLESS OTHERWISE NOTED, ALL SWITCHES ARE SHOWN AT 25° C (77° F), AT ATMOSPHERIC PRESSURE, AT 50% RELATIVE HUMIDITY, WITH ALL UTILITIES TURNED OFF, AND AFTER A NORMAL SHUTDOWN HAS OCCURRED.
 - DASHED LINES INDICATE RECOMMENDED FIELD WIRING BY OTHERS. DASHED LINE ENCLOSURES AND/OR DASHED DEVICE OUTLINES INDICATE COMPONENTS PROVIDED BY THE FIELD. PHANTOM LINE ENCLOSURES INDICATE ALTERNATE CIRCUITRY OR AVAILABLE SALES OPTIONS. SOLID LINE INDICATES WIRING BY TRANE CO.
 - NUMBERS ALONG THE RIGHT SIDE OF THE SCHEMATIC DESIGNATE THE LOCATION OF CONTACTS BY THE LINE NUMBER. AN UNDERLINED NUMBER INDICATES A NORMALLY CLOSED CONTACT. AN OPEN ARROW BELOW THE LINE NUMBER POINTING UPWARD INDICATES A TIMED CONTACT WHICH BEGINS TIMING WHEN ENERGIZED.
 - IF ANY OF THE ORIGINAL WIRING AS SUPPLIED WITH THE UNIT MUST BE REPLACED, USE ONLY APPLIANCE WIRING MATERIAL RATED AT 105 DEG C OR EQUIVALENT.
- 5 SEE UNIT CONTROLS DIAGRAM FOR BALANCE OF CIRCUIT.
- 6 THERMOSTAT DEVICES ARE EQUIPPED WITH AUTO-RESETTING THERMAL LIMIT SWITCHES AND ONE-SHOT LIMIT FUSE.

DESIGNER: A. WAELE	TRANE® THIS DRAWING IS PROPRIETARY AND SHALL NOT BE COPIED OR ITS CONTENTS DISCLOSED TO OUTSIDE PARTIES WITHOUT THE WRITTEN CONSENT OF TRANE. IEC DESIGN COMPLIANT	PRECEDENT DIAGRAM SCHEMATIC/COMPONENT LOCATION - ELECTRIC HEAT 18 KW 208/240V					
ENGINEER: R. CERVANTES		MASTER NUMBER:	DRAWING NUMBER: 12134307	SHEET: 1 OF 1	REV B		
TRANE © DATE: 22-NOV-2021							
REPLACES:							
SIMILAR TO:							
REVISION DATE: 30-NOV-2021		APPROVED BY: R. CERVANTES					
REVISED BY: A. WAELE							
CAD SYSTEM USED: CREO SCHEMATICS							