
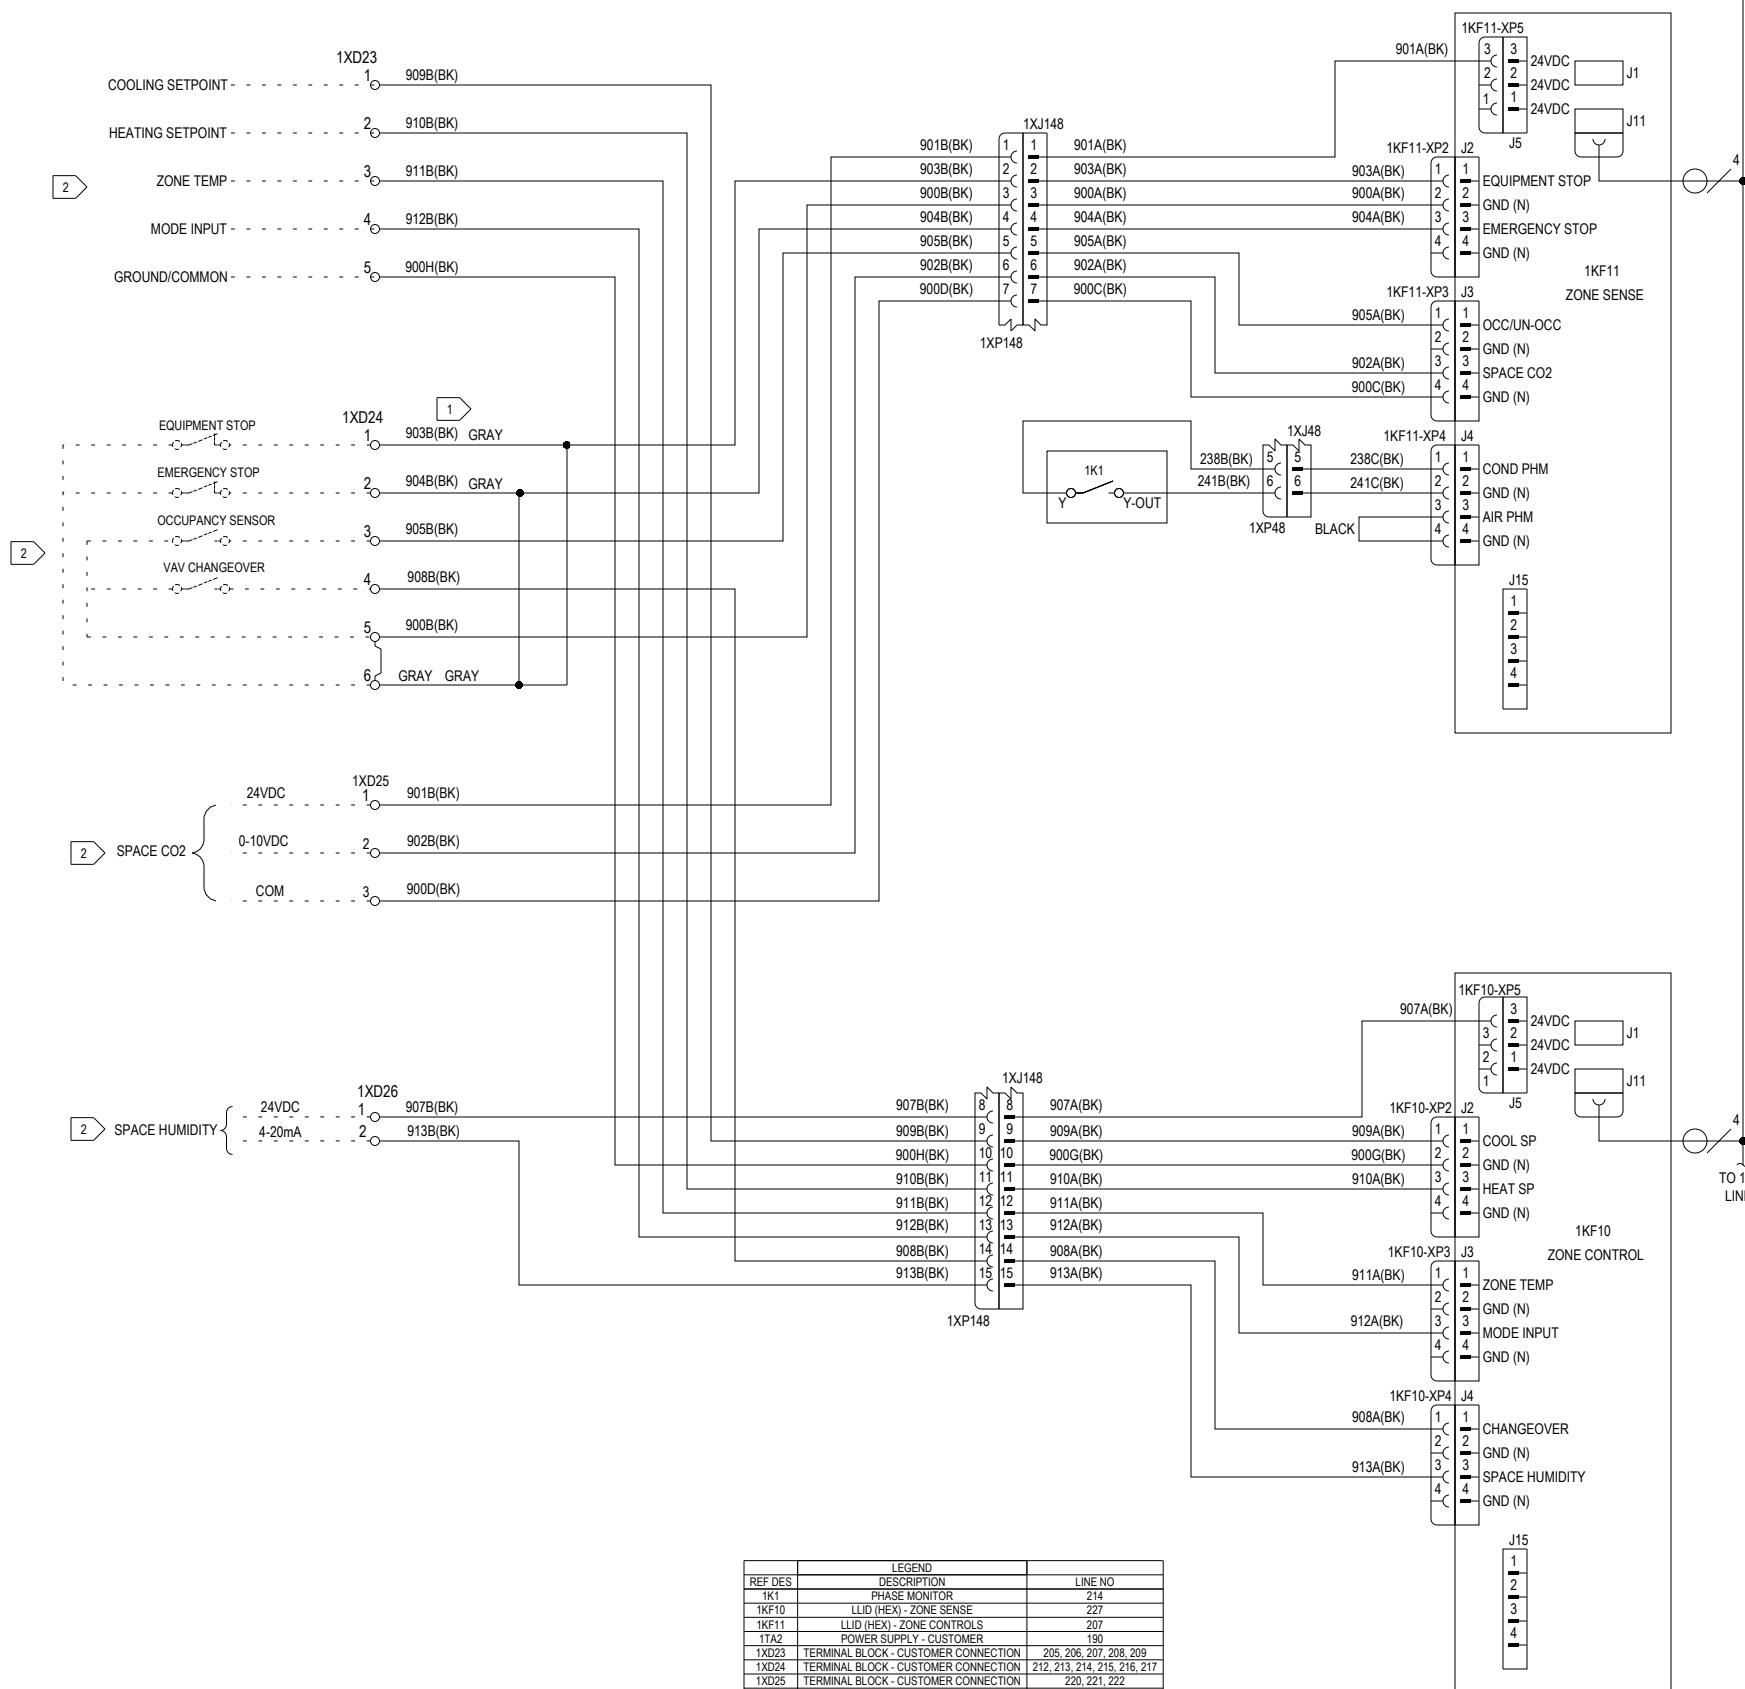


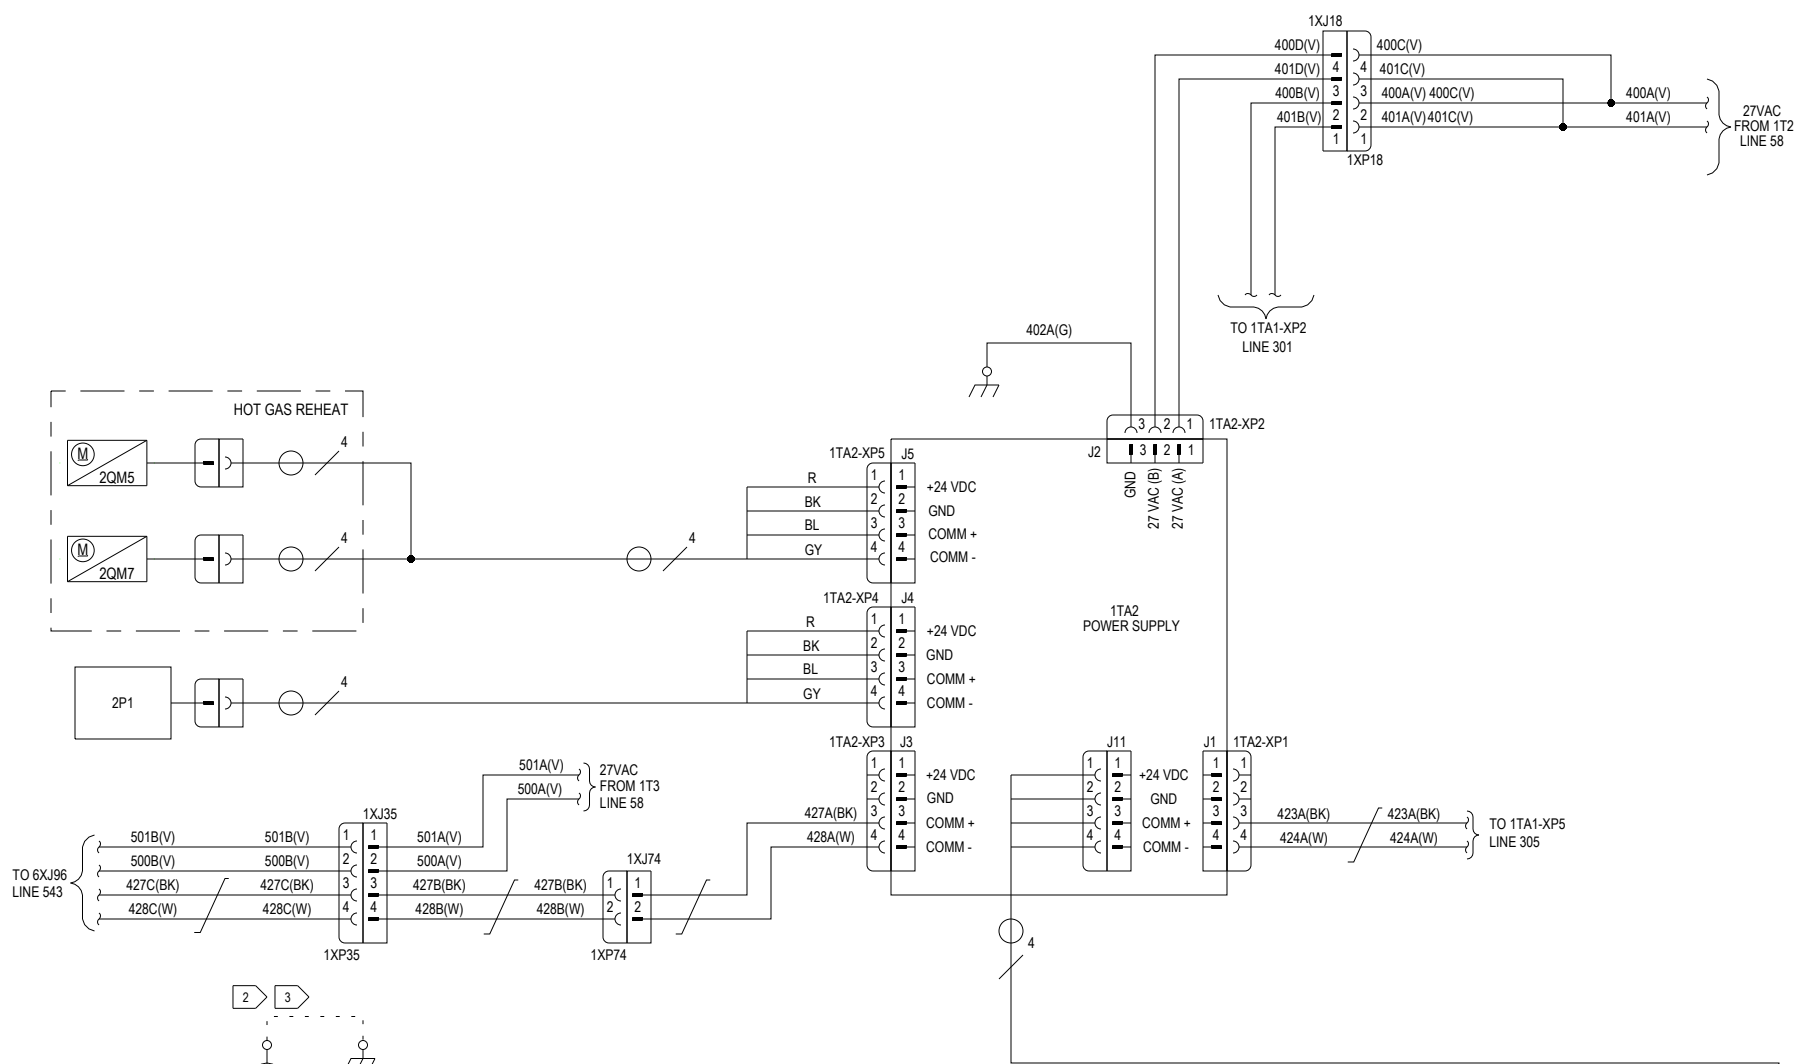

REF DES	LEGEND	LINE NO
1K1	PHASE MONITOR	214
1KF10	LLID (HEX) - ZONE SENSE	227
1KF11	LLID (HEX) - ZONE CONTROLS	207
1TA2	POWER SUPPLY - CUSTOMER	190
1XD23	TERMINAL BLOCK - CUSTOMER CONNECTION	205, 206, 207, 208, 209
1XD24	TERMINAL BLOCK - CUSTOMER CONNECTION	212, 213, 214, 215, 216, 217
1XD25	TERMINAL BLOCK - CUSTOMER CONNECTION	220, 221, 222
1XD26	TERMINAL BLOCK - CUSTOMER CONNECTION	226, 227
2P1	USER INTERFACE	194
2QM5	VALVE - REHEAT	189
2QM7	VALVE - COOLING	191

NOTES

- 1 REMOVE THE APPLICABLE GRAY JUMPER WHEN EMERGENCY OR EQUIPMENT STOP SWITCHES ARE INSTALLED.
- 2 USE CLASS 2 CIRCUIT ONLY
- 3 FUNCTIONAL EARTH TERMINAL PROVIDED FOR CUSTOMER CONTROLS WIRING

DESIGNER: T.PEED
ENGINEER: S. MCKINLEY
TRANE © DATE: 08-AUG-2021
REPLACES:
SIMILAR TO:
REVISION DATE: 2-FEB-2022
REVISED BY: A. WAELE
APPROVED BY: S. MCKINLEY
CAD SYSTEM USED: CREO SCHEMATICS

TRANE®

THIS DRAWING IS PROPRIETARY
AND SHALL NOT BE COPIED OR
ITS CONTENTS DISCLOSED TO
OUTSIDE PARTIES WITHOUT THE
WRITTEN CONSENT OF TRANE.

IPAK 1
CONTROLS SCHEMATIC
20-75T
CUSTOMER CONNECTIONS #

MASTER NUMBER:	DRAWING NUMBER:	SHEET:	REV
	12134363	4 OF 17	B