


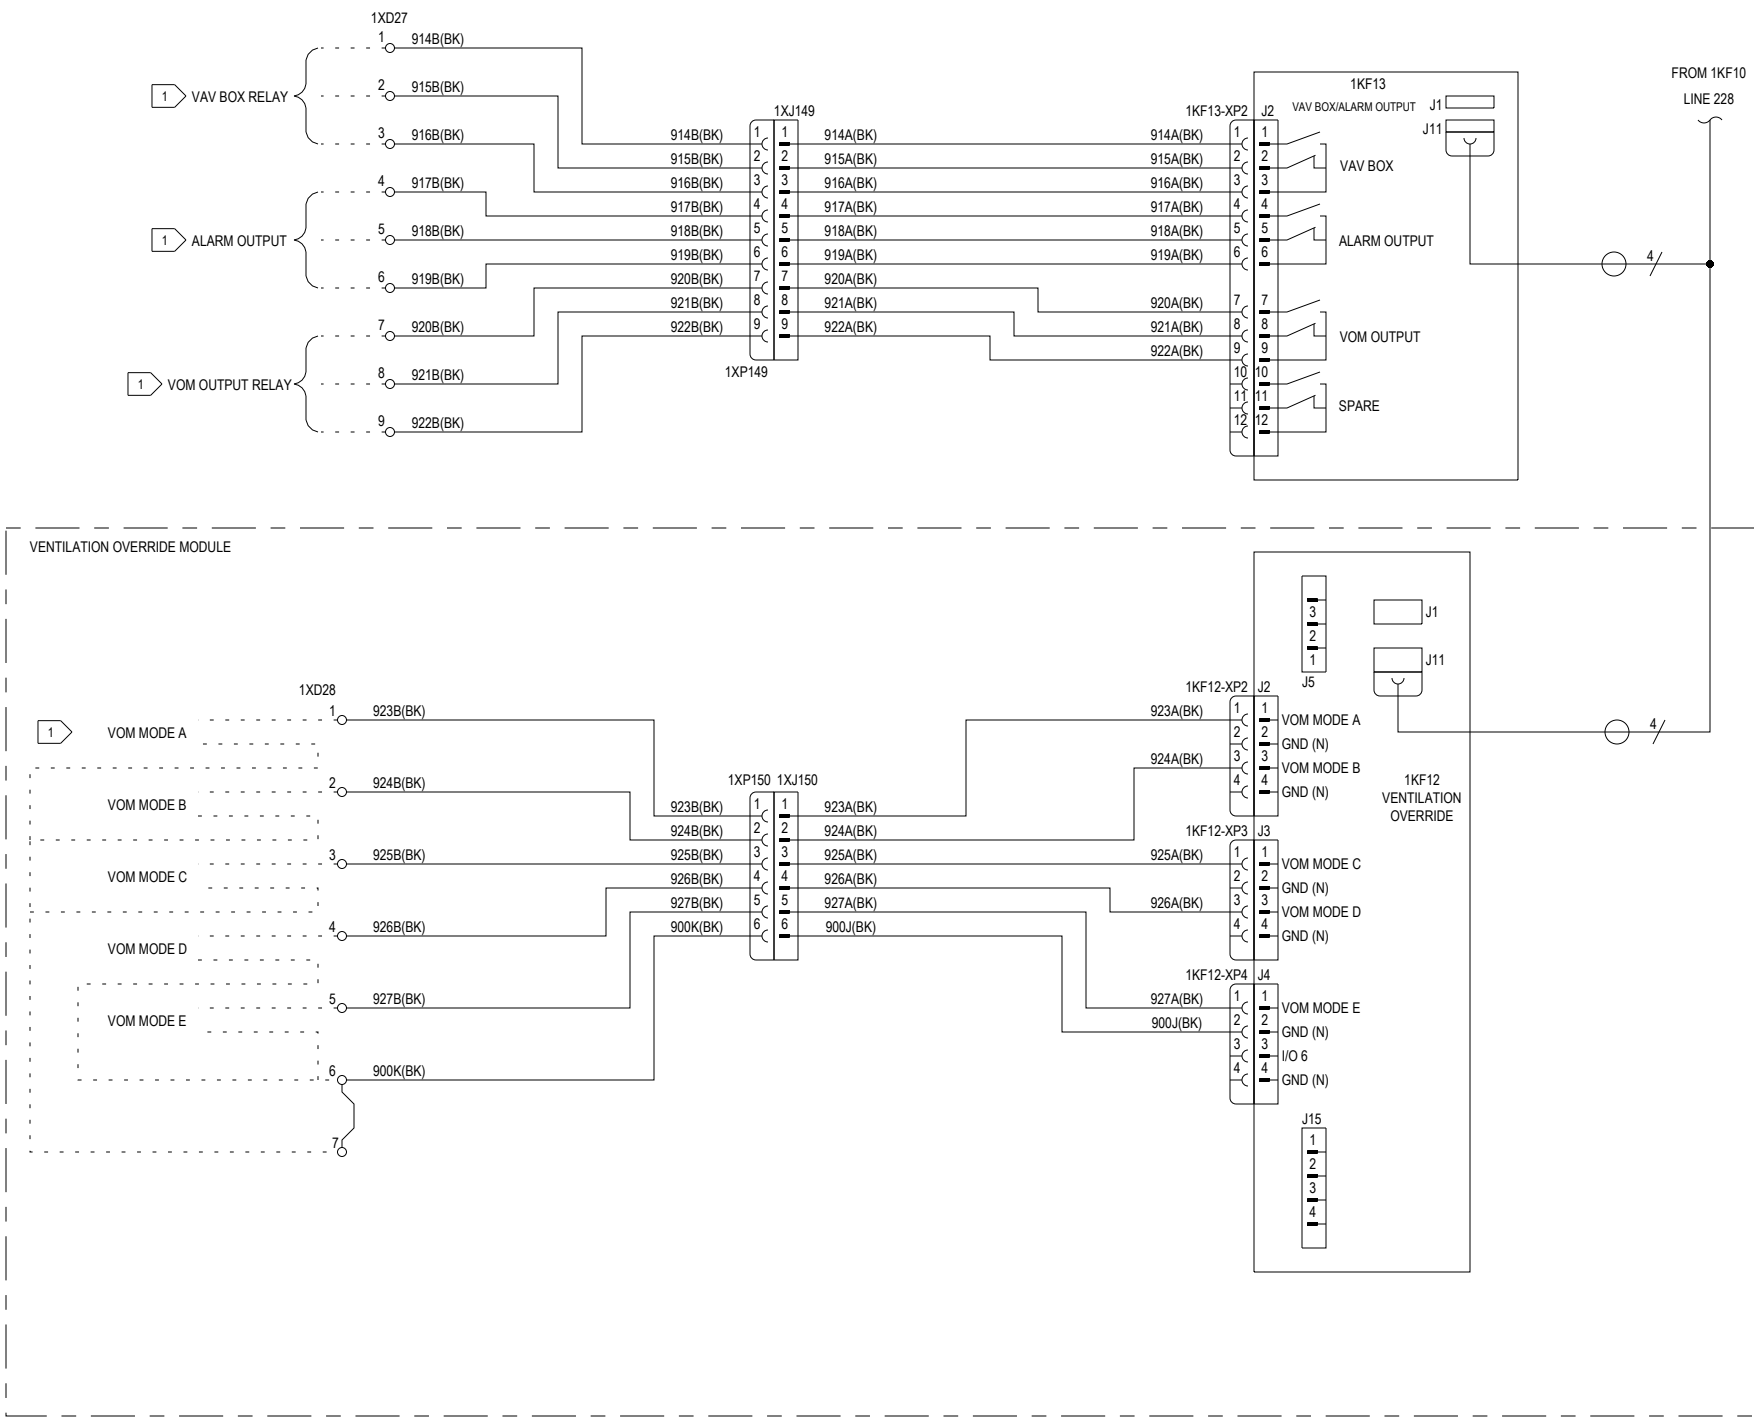

NOTES:

1 USE CLASS 2 CIRCUIT ONLY

REF DES	LEGEND	LINE NO
1KF12	VENTILATION OVERRIDE	270
1KF13	LLID (HEX) - VAV BOX / ALARM OUTPUT	261
1XD27	TERMINAL BLOCK - CUSTOMER CONNECTION	256, 257, 258, 259, 260, 261, 262, 263, 264
1XD28	TERMINAL BLOCK - CUSTOMER CONNECTION	270, 272, 273, 274, 276, 277, 279

DESIGNER:	A. WAELE
ENGINEER:	S. MCKINLEY
TRANE © DATE:	08-AUG-2021
REPLACES:	
SIMILAR TO:	
REVISION DATE:	02-FEB-2022
REVISED BY:	A. WAELE
APPROVED BY:	S. MCKINLEY
CAD SYSTEM USED:	CREO SCHEMATICS

TRANE®

THIS DRAWING IS PROPRIETARY AND SHALL NOT BE COPIED OR ITS CONTENTS DISCLOSED TO OUTSIDE PARTIES WITHOUT THE WRITTEN CONSENT OF TRANE.

IPAK 1 CONTROLS SCHEMATIC 20-130T CUSTOMER CONNECTIONS #2			
MASTER NUMBER:	DRAWING NUMBER:	SHEET:	REV
	12134365	5 OF 17	B