


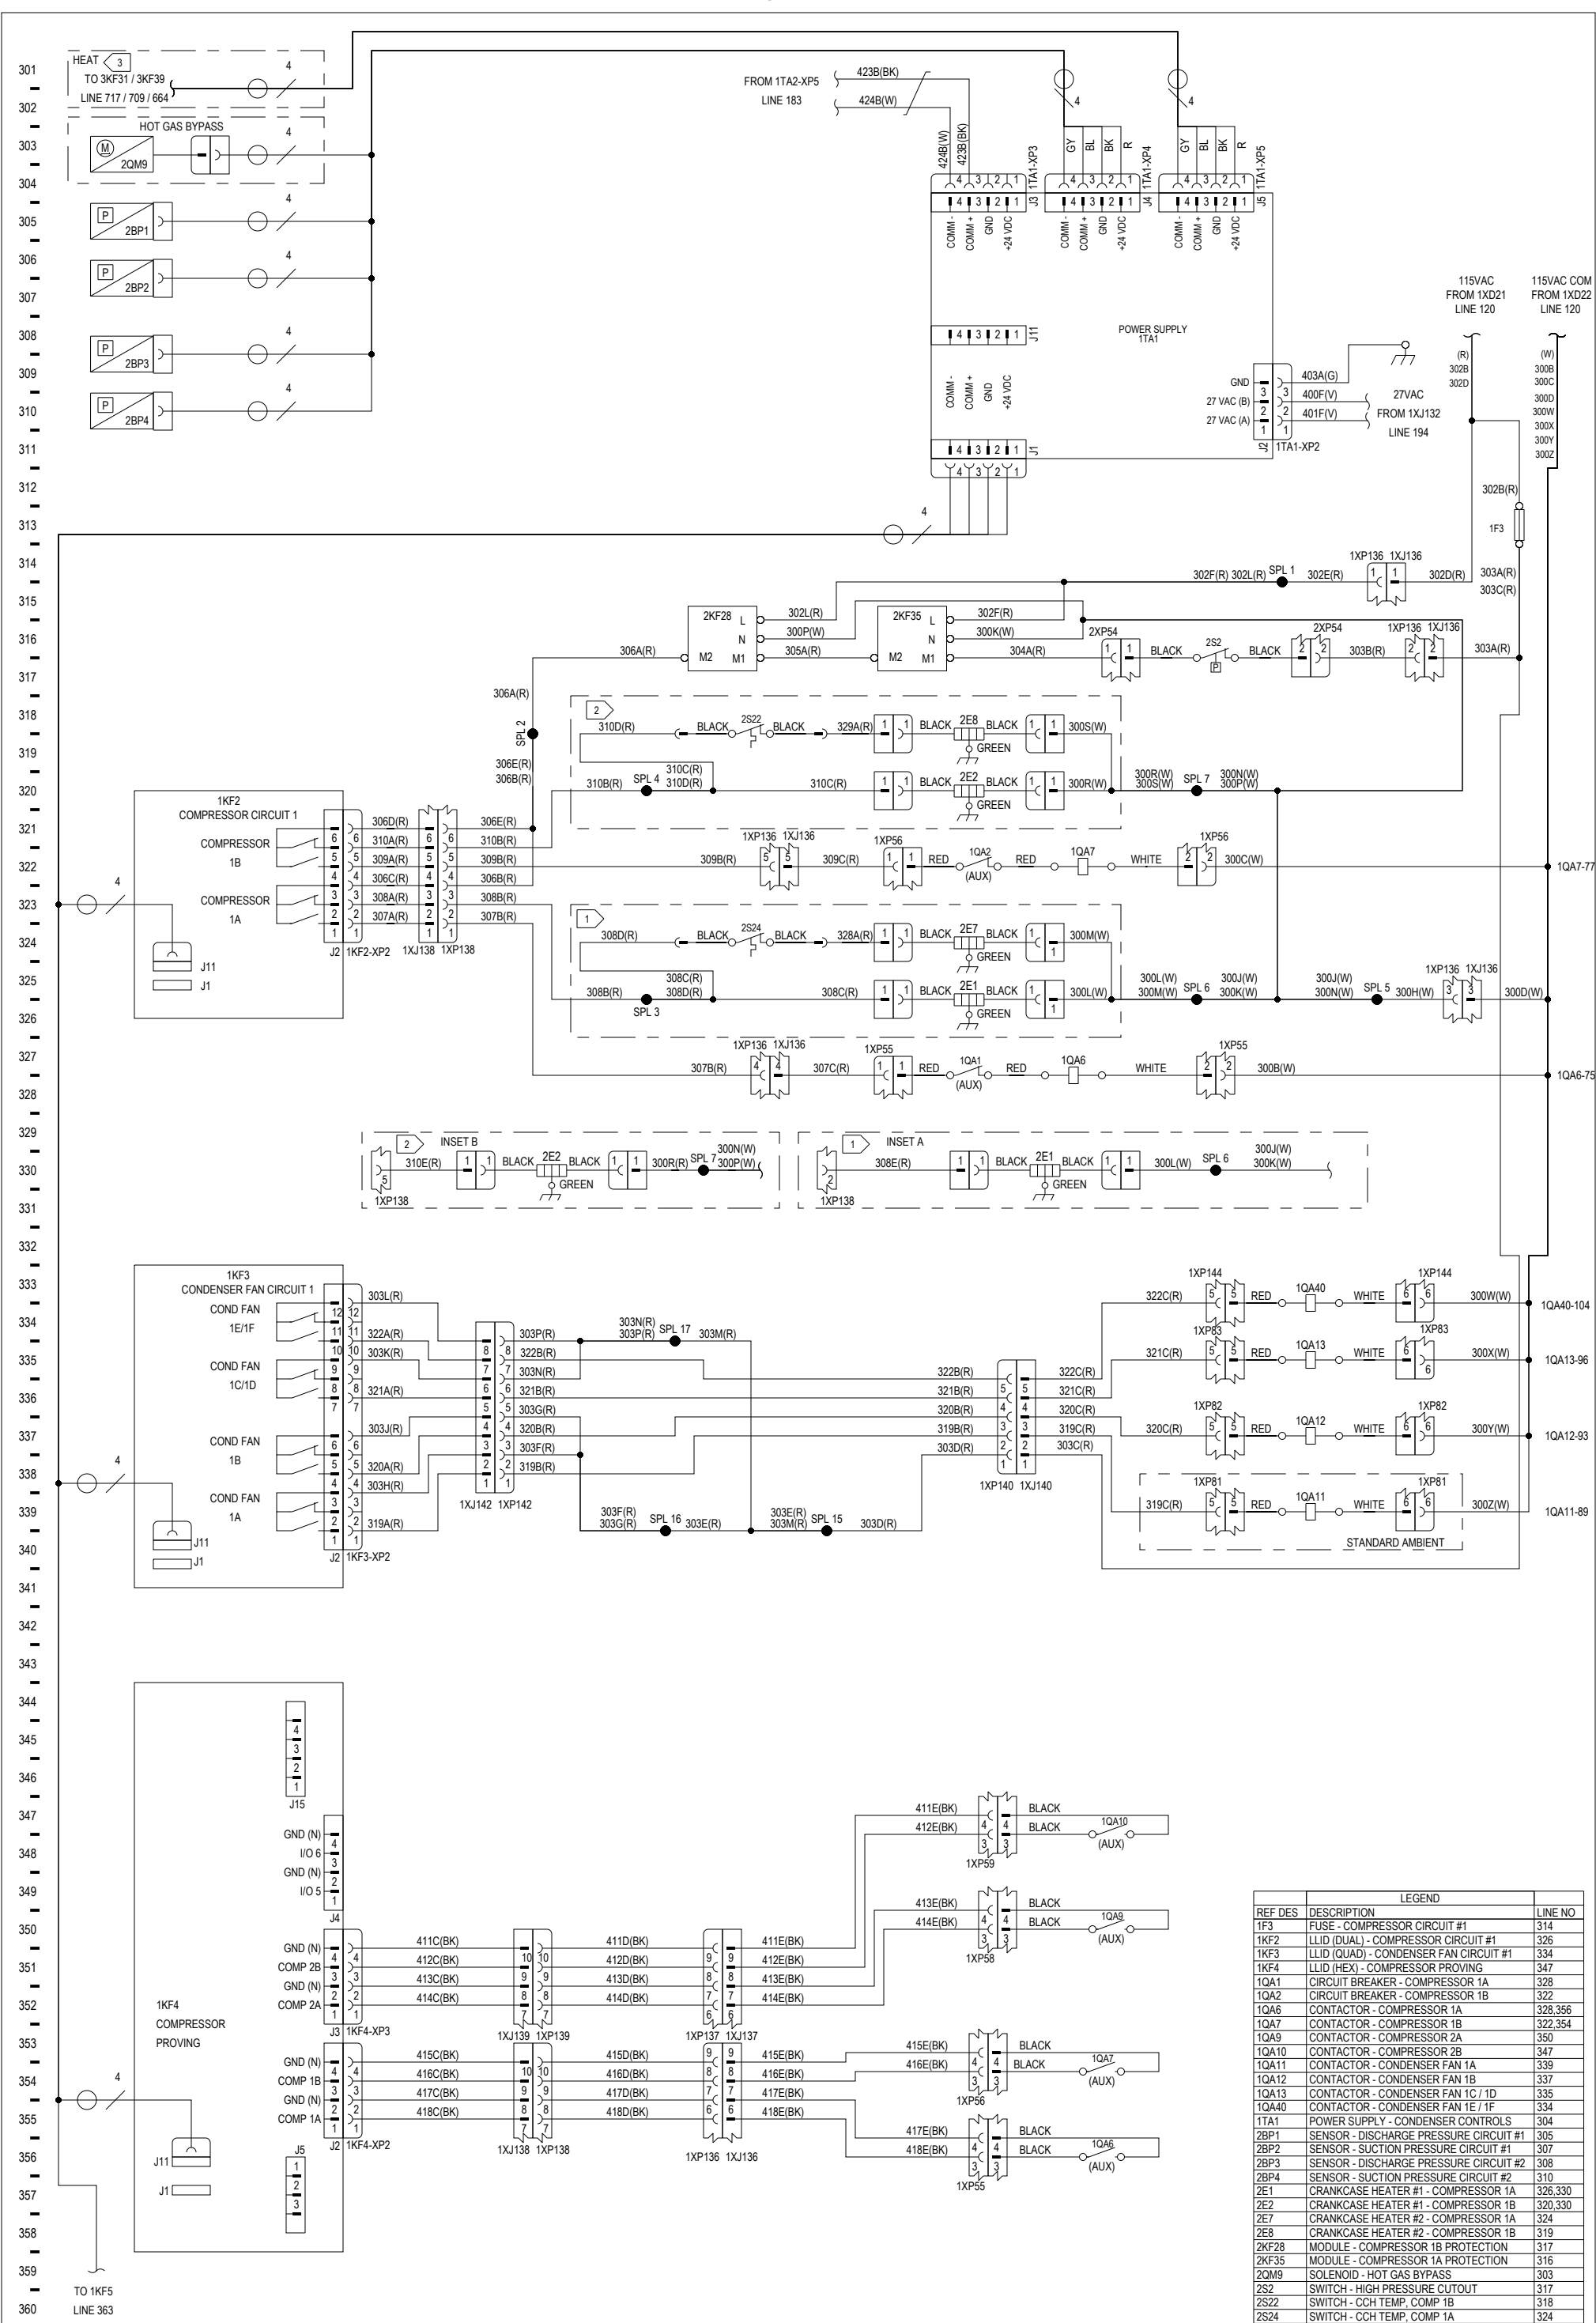

- NOTES:
- 1 WIRING SHOWN FOR 130T UNITS. SEE INSET A FOR 90-115T UNITS.
 - 2 WIRING SHOWN FOR 105-130T UNITS. SEE INSET B FOR 90T UNITS.
 - 3 FOR GAS HEAT, REFER TO 3KF31 ON LINE 717. FOR ELECTRIC HEAT, REFER TO 3KF31 ON LINE 709. FOR HYDRONIC HEAT, REFER TO 3KF39 ON LINE 664.

DESIGNER:	R JOHNSON
ENGINEER:	S MCKINLEY
TRANE © DATE:	14 JAN 2022
REPLACES:	
SIMILAR TO:	
REVISION DATE:	14 JAN 2022
REVISED BY:	R JOHNSON
APPROVED BY:	S MCKINLEY
CAD SYSTEM USED:	CREO SCHEMATICS

TRANE®

THIS DRAWING IS PROPRIETARY AND SHALL NOT BE COPIED OR ITS CONTENTS DISCLOSED TO OUTSIDE PARTIES WITHOUT THE WRITTEN CONSENT OF TRANE.

IPAK 1 CONTROLS SCHEMATIC 90-130T REF SYSTEM #1		MASTER NUMBER:	DRAWING NUMBER:	SHEET:	REV
			12134368	6 OF 17	B