
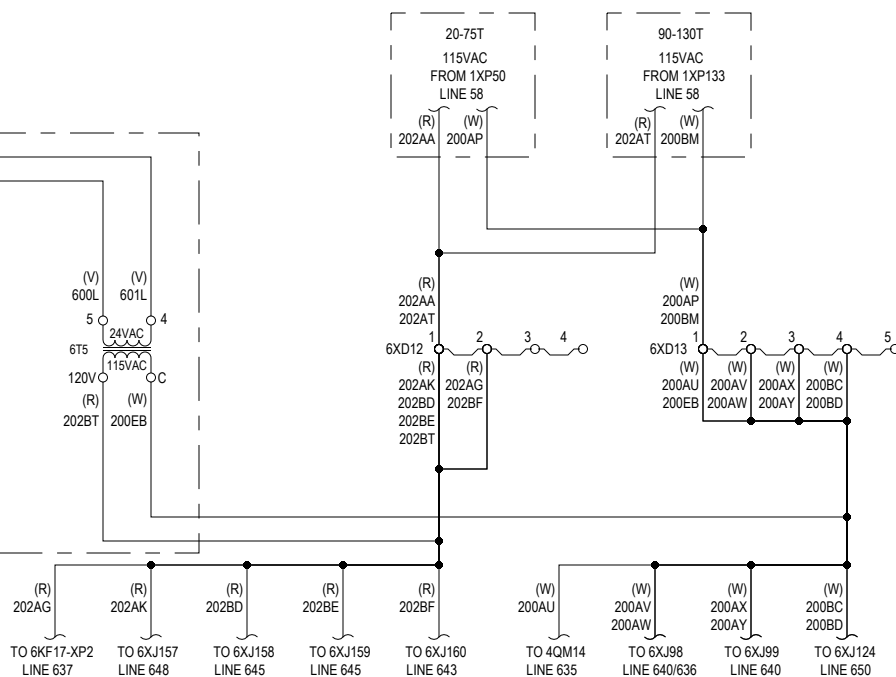
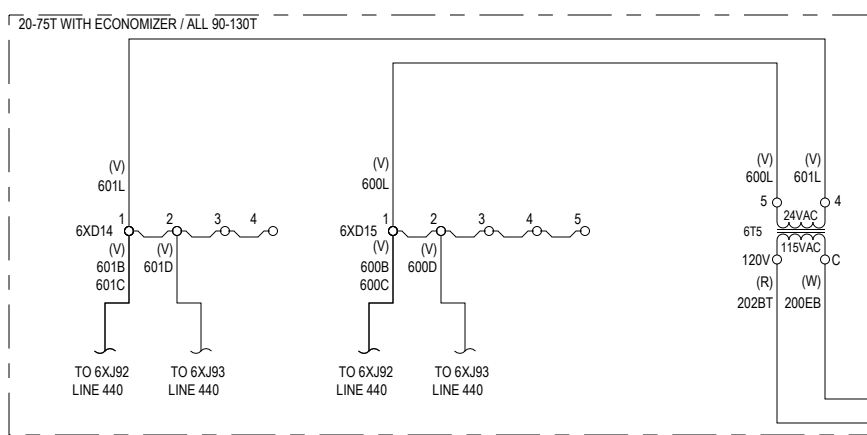


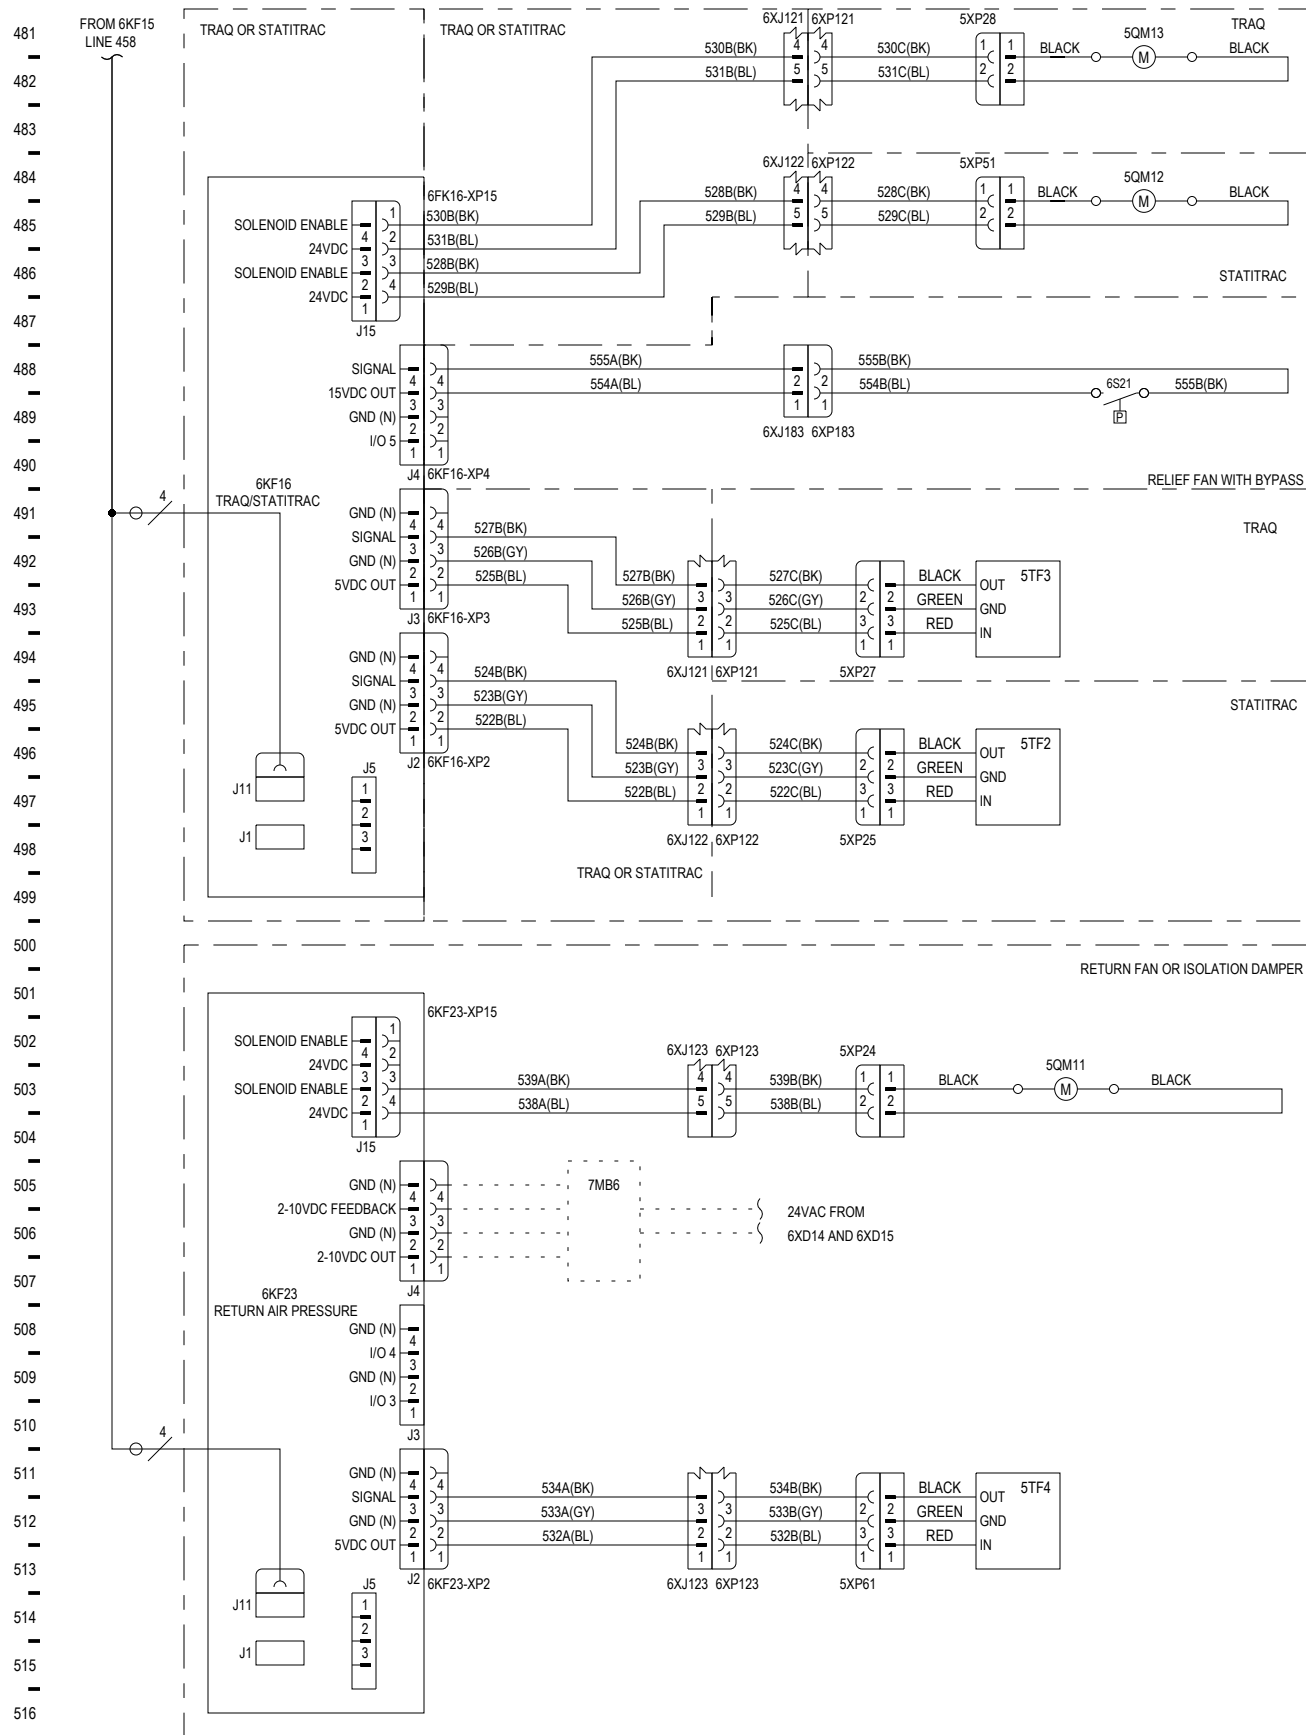

REF DES	LEGEND	LINE NO
5QM11	SOLENOID - RETURN PRESSURE CALIBRATION	503
5QM12	SOLENOID - SPACE PRESSURE CALIBRATION	485
5QM13	SOLENOID - TRAQ PRESSURE CALIBRATION	481
5TF2	TRANSDUCER - STATITRAQ (SPACE PRESSURE)	496
5TF3	TRANSDUCER - TRAQ (OUTDOOR AIRFLOW)	493
5TF4	TRANSDUCER - RETURN PRESSURE	482
6KF16	LLID (HEX) - SPACE PRESSURE/TRAQ	515
6KF23	LLID (HEX) - RETURN PRESSURE	502
6S21	SWITCH - RELIEF FAN PROVING	408
6T5	TRANSFORMER - 24V ACTUATORS	524
6XD12	TERMINAL BLOCK - 115VAC	524
6XD13	TERMINAL BLOCK - 115VAC COMMON	524
6XD14	TERMINAL BLOCK - 24VAC	524
6XD15	TERMINAL BLOCK - 24VAC COMMON	524
7MB6	ACTUATOR - RETURN ISOLATION DAMPER	506

DESIGNER:	R JOHNSON
ENGINEER:	S MCKINLEY
TRANE @ DATE:	28 JAN 2022
REPLACES:	
SIMILAR TO:	
REVISION DATE:	28 JAN 2022
REVISED BY:	R JOHNSON
APPROVED BY:	S MCKINLEY
CAD SYSTEM USED:	CREO SCHEMATICS

TRANE®

THIS DRAWING IS PROPRIETARY
AND SHALL NOT BE COPIED OR
ITS CONTENTS DISCLOSED TO
OUTSIDE PARTIES WITHOUT THE
WRITTEN CONSENT OF TRANE.

IPAK 1
CONTROLS SCHEMATIC
20-130T AIR HANDLER CONTROLS #2

MASTER NUMBER:	DRAWING NUMBER: 12134372	SHEET: 9 OF 17	REV B
----------------	------------------------------------	--------------------------	-----------------