

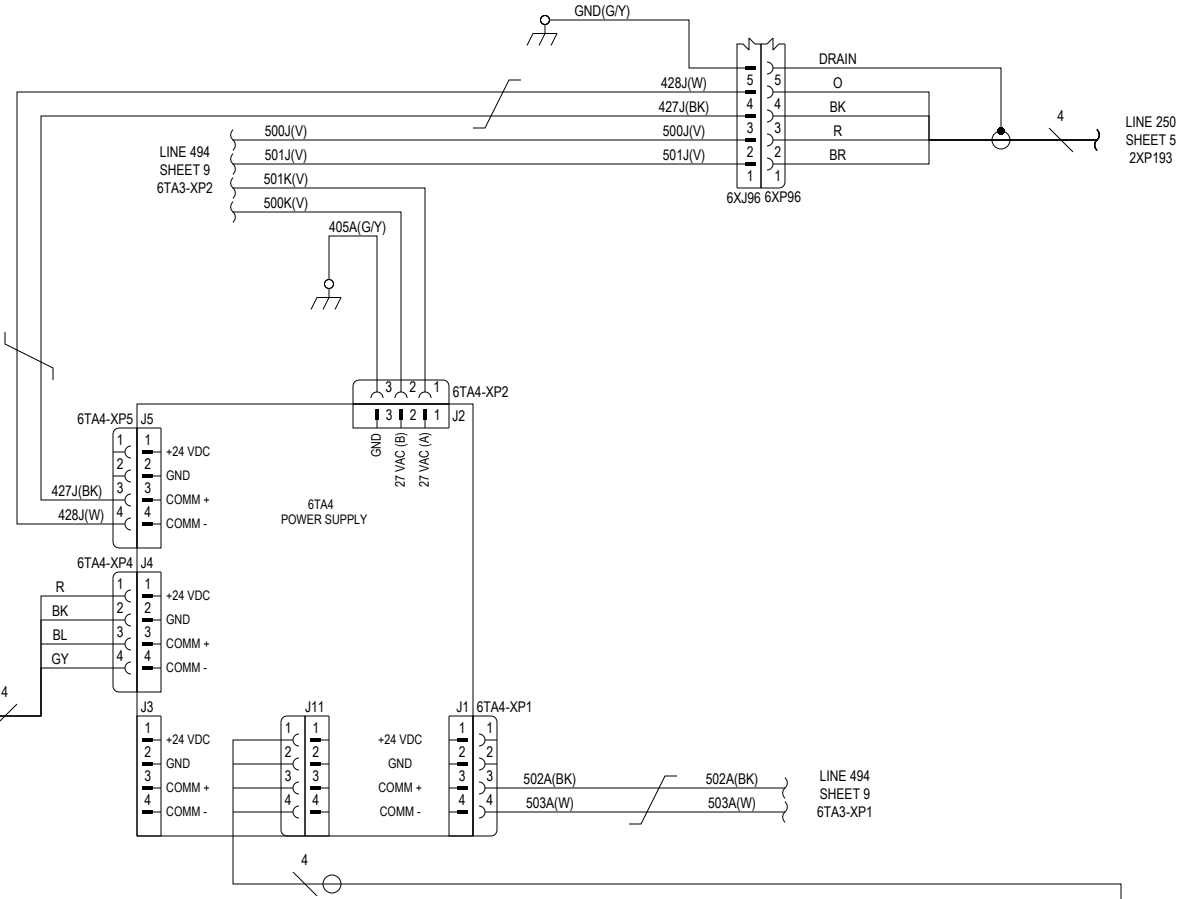
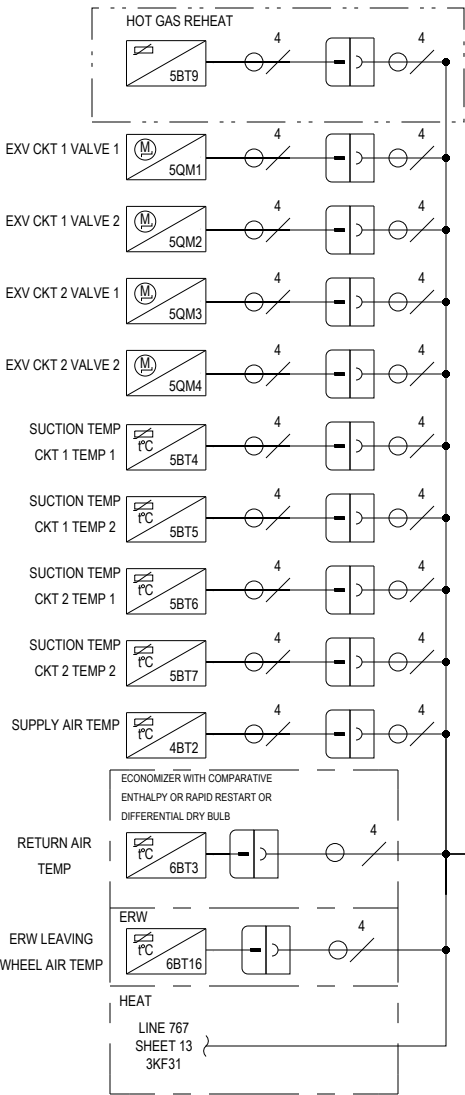


601
602
603
660

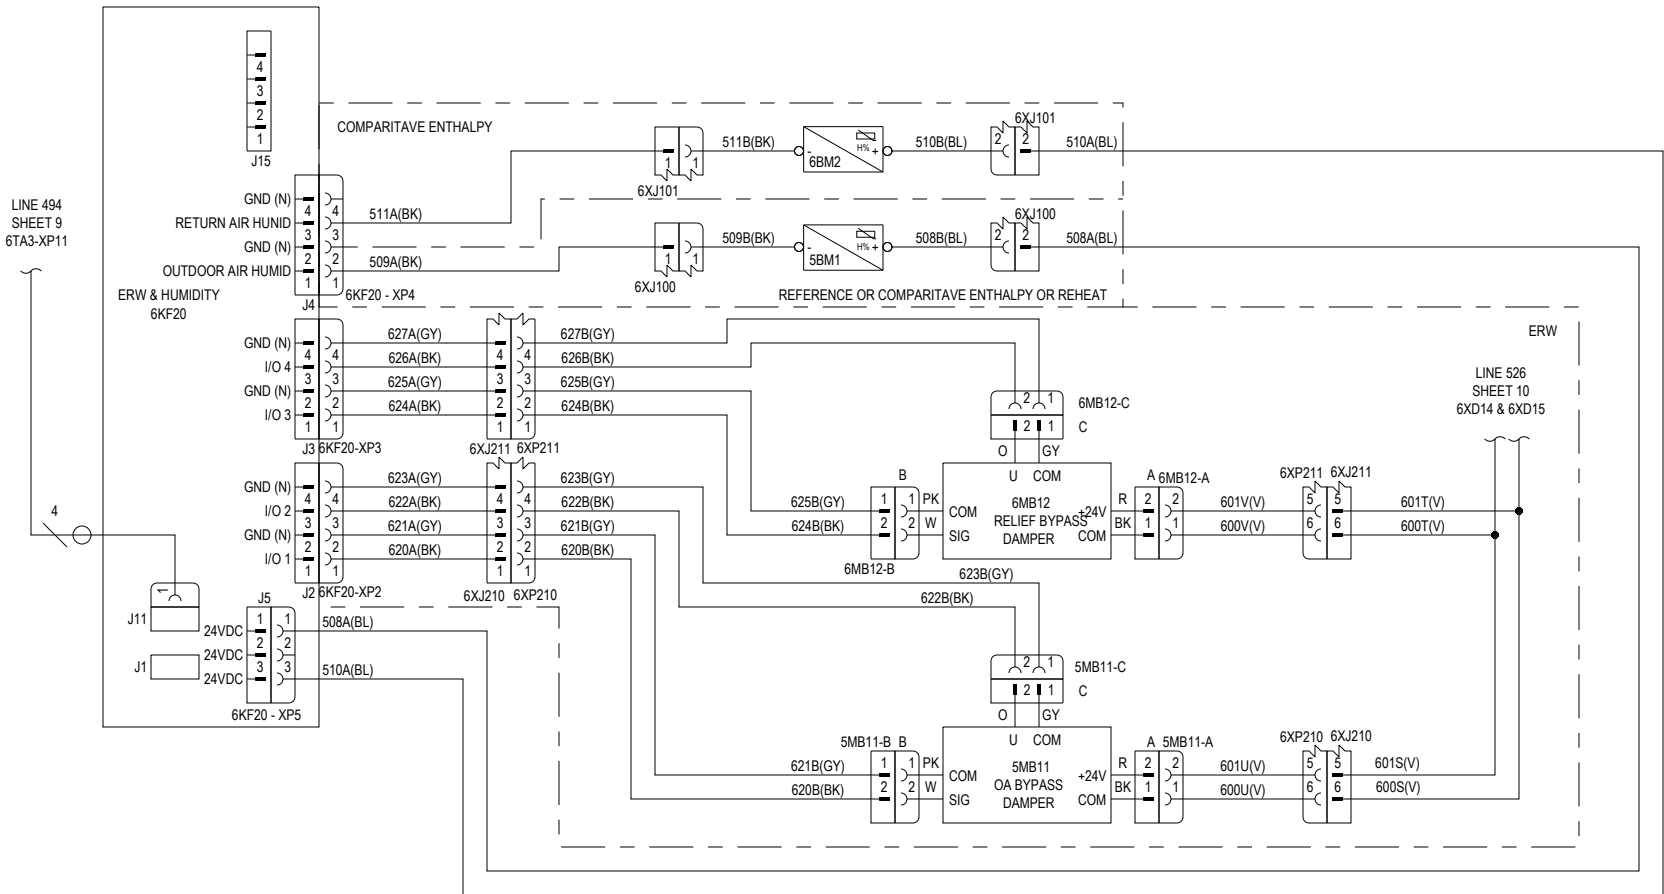

LEGEND		
REF DES	DESCRIPTION	LINE NO
4BT2	SENSOR - SUPPLY AIR TEMP	635
5BM1	SENSOR - OUTDOOR AIR HUMIDITY	605
5BT4	SENSOR - SUCTION TEMP CKT 1 TEMP 1	629
5BT5	SENSOR - SUCTION TEMP CKT 1 TEMP 2	630
5BT6	SENSOR - SUCTION TEMP CKT 2 TEMP 1	632
5BT7	SENSOR - SUCTION TEMP CKT 2 TEMP 2	633
5BT8	SENSOR - MIXED AIR TEMP	653
5BT9	SENSOR - LEAVING EVAP AIR TEMP	621
5MB11	ACTUATOR - OUTDOOR AIR BYPASS	616
5QM1	SENSOR- EXV CKT 1 VALVE 1	622
5QM2	SENSOR- EXV CKT 1 VALVE 2	624
5QM3	SENSOR- EXV CKT 2 VALVE 1	626
5QM4	SENSOR- EXV CKT 2 VALVE 2	627
6BM2	SENSOR - RETURN AIR HUMIDITY	603
6BT3	SENSOR - RETURN AIR TEMP	637
6BT16	SENSOR - ERW LEAVING WHEEL AIR TEMP	639
6KF20	LLID (HEX) - ERW & HUMIDITY	601
6KF21	LLID (HEX) - FILTER STATUS #1	657
6MB12	DAMPER - RELIEF BYPASS	611
6TA4	POWER SUPPLY #4 - RETURN SECTION	632
6TF10	TRANSDUCER - PRE FINAL FILTER PRESSURE	649

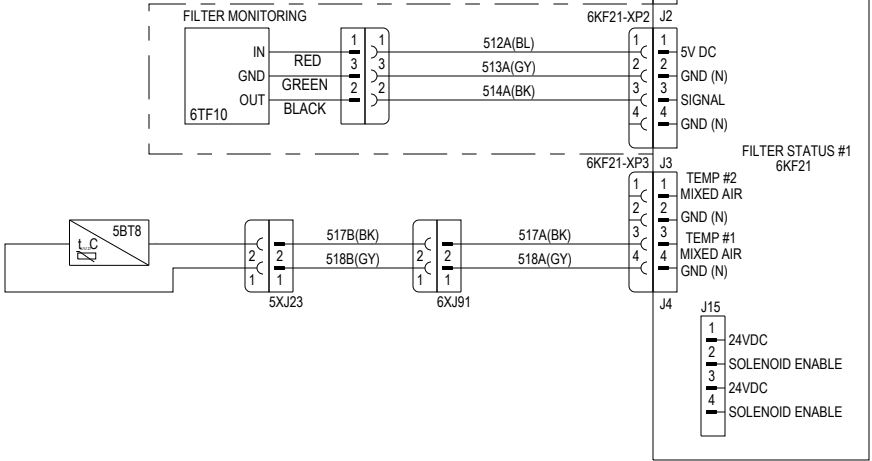

DESIGNER: A. WAELE
ENGINEER: E. CAROTA
TRANE © DATE: 29-SEP-2022
REPLACES:
SIMILAR TO:
REVISION DATE: 18-OCT-2022
REVISED BY: A. WAELE
APPROVED BY: E. CAROTA
CAD SYSTEM USED: CREO SCHEMATICS

TRANE®

THIS DRAWING IS PROPRIETARY AND SHALL NOT BE COPIED OR ITS CONTENTS DISCLOSED TO OUTSIDE PARTIES WITHOUT THE WRITTEN CONSENT OF TRANE.

IPAK 2
CONTROLS SCHEMATIC
90-150T AIR HANDLER CONTROLS #3

MASTER NUMBER:	DRAWING NUMBER:	SHEET:	REV
	12134647	11 OF 17	B