
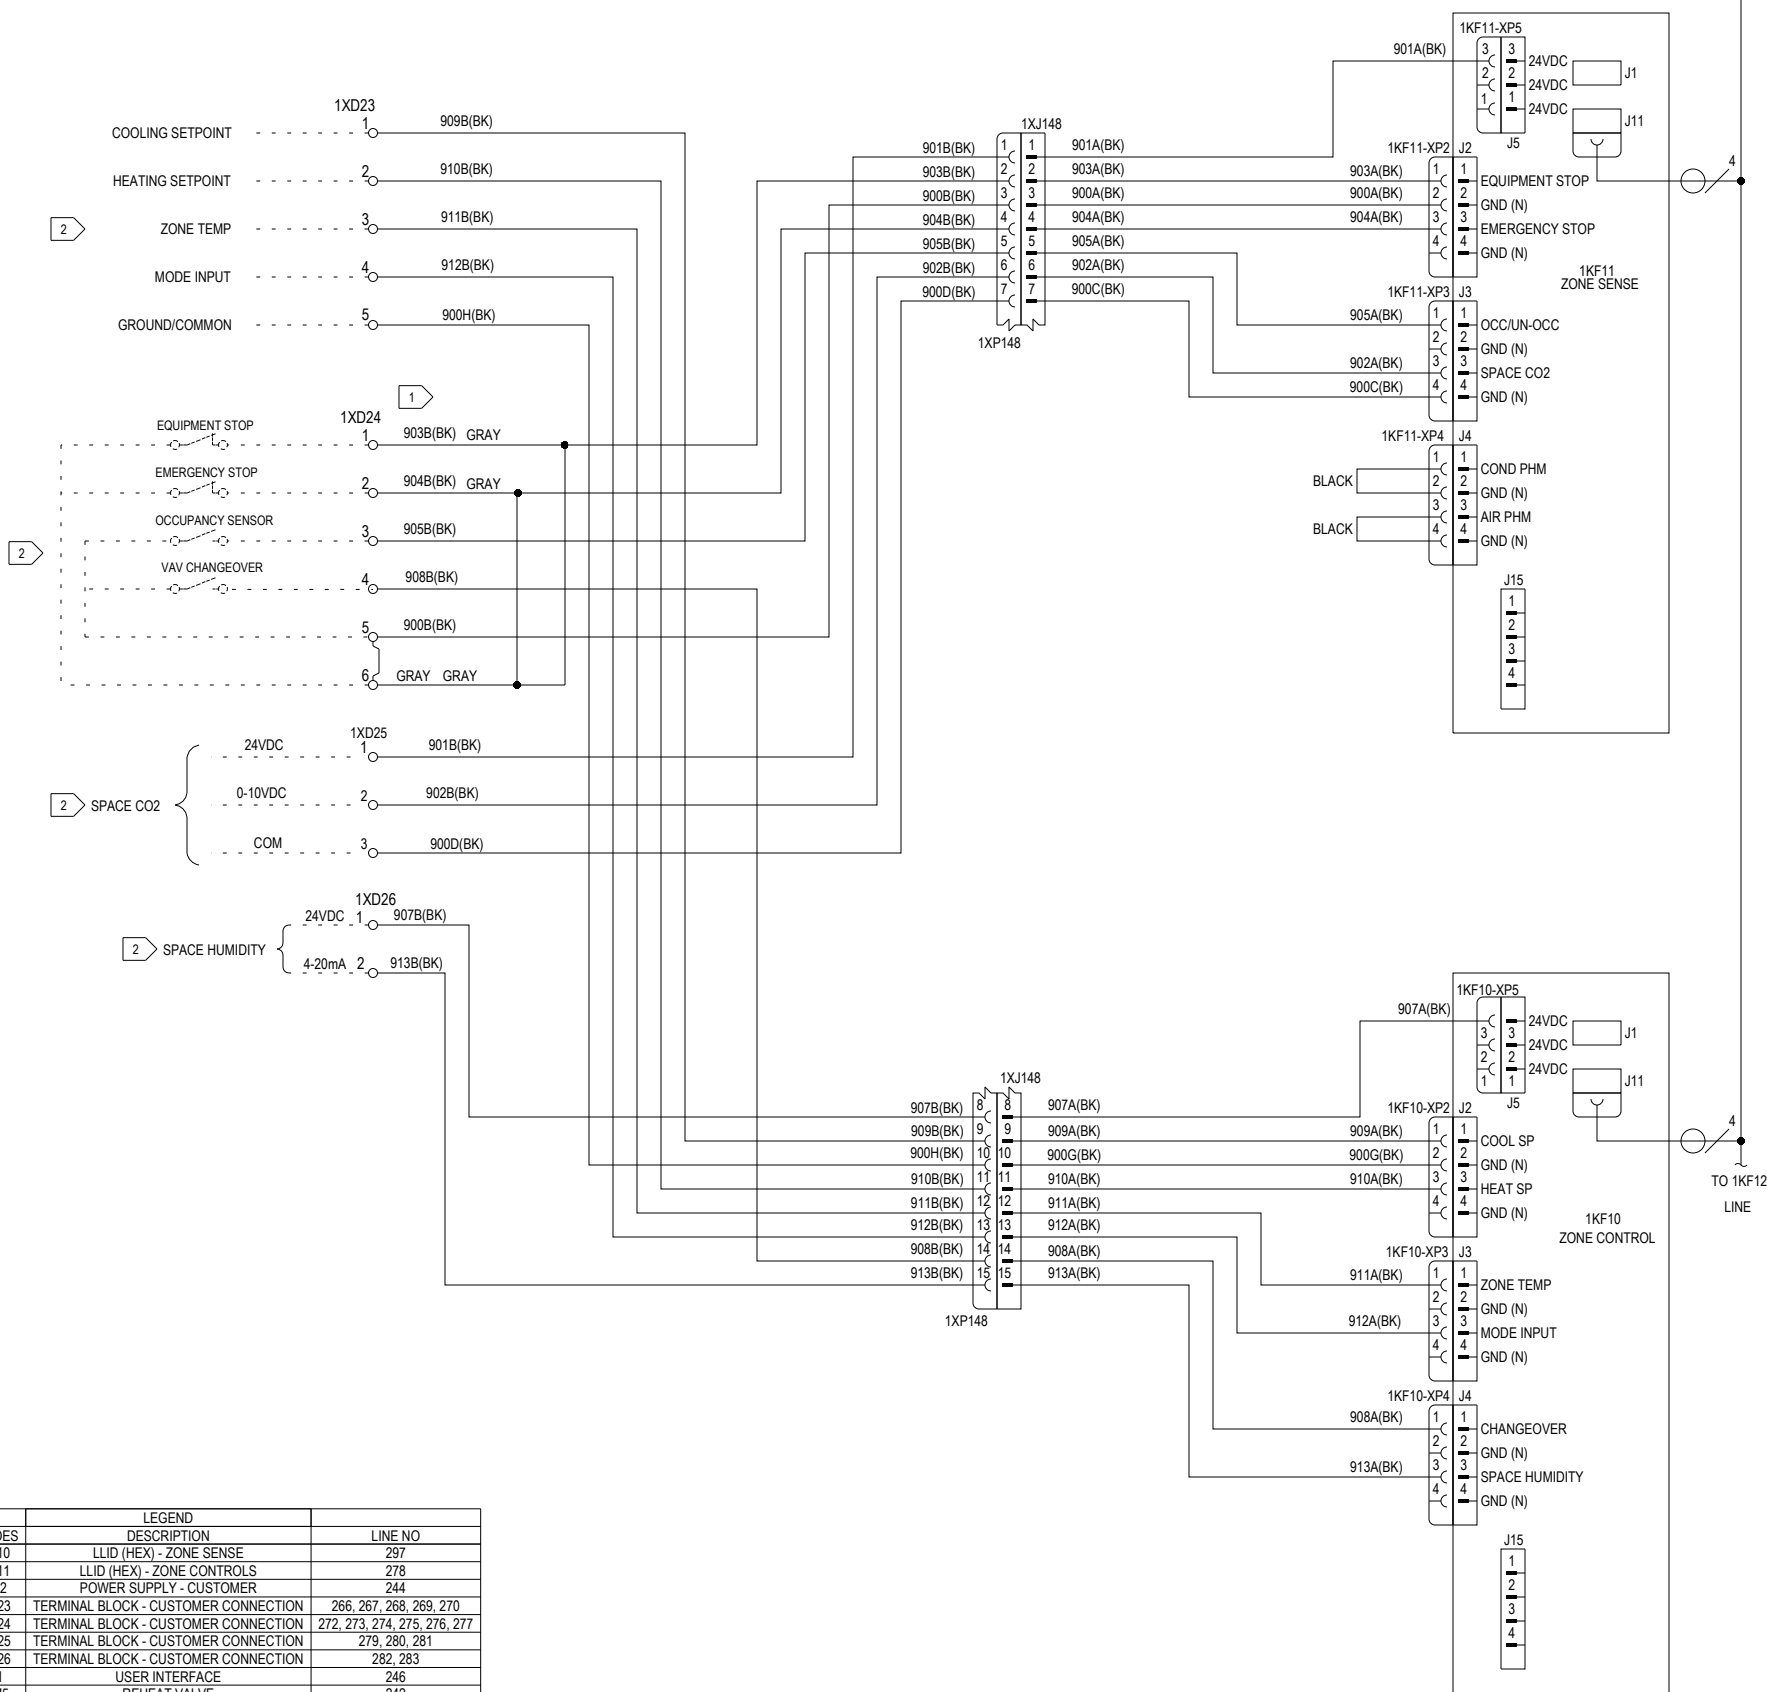


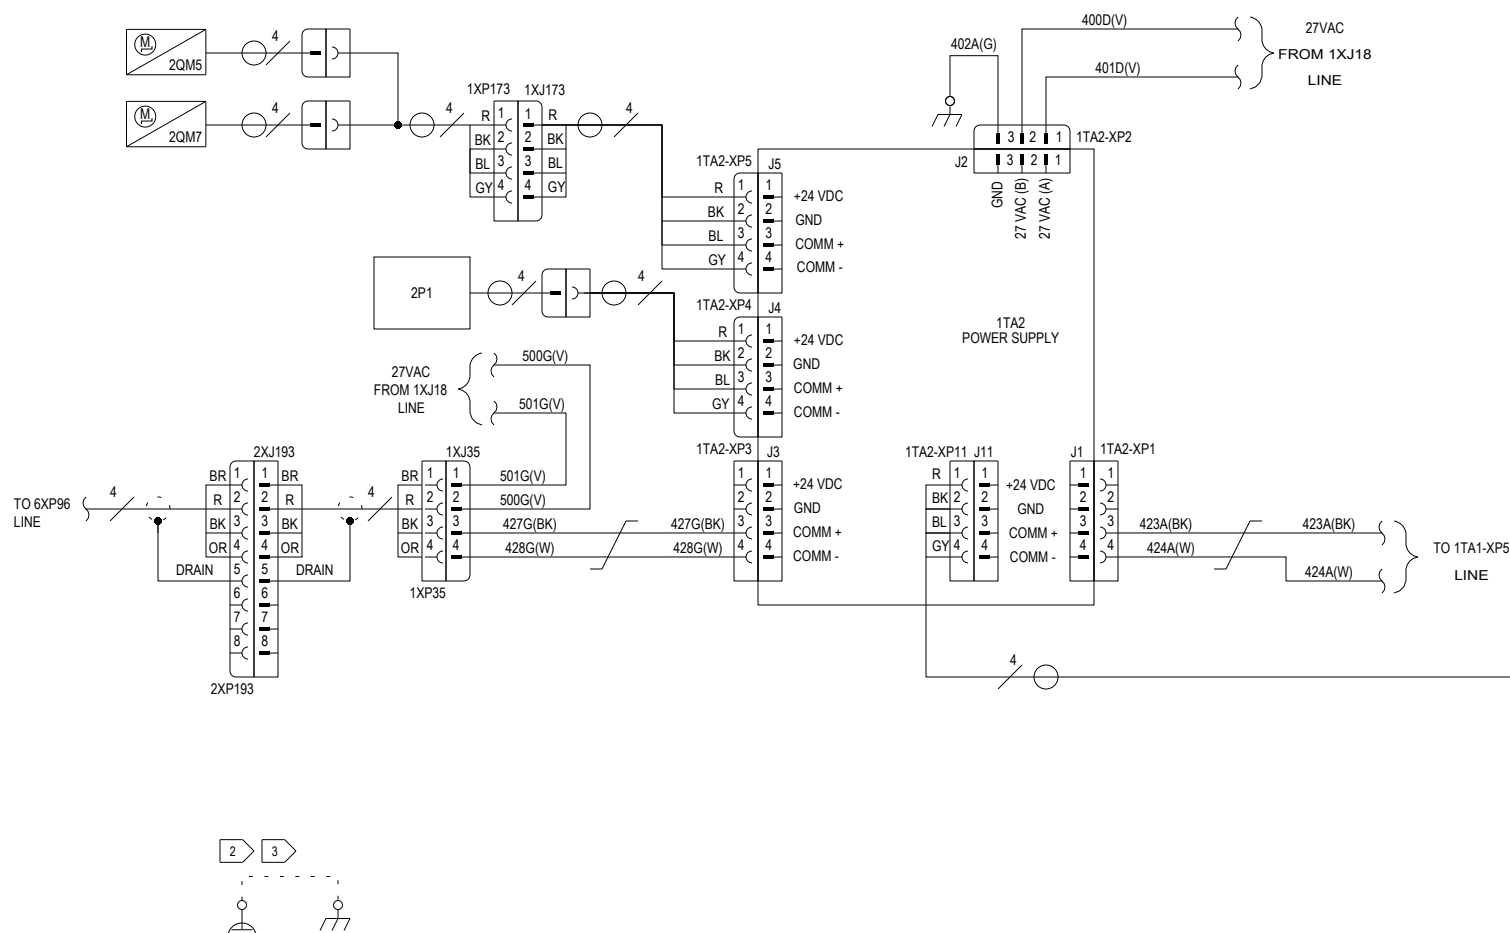

REF DES	LEGEND	LINE NO
1KF10	LLID (HEX) - ZONE SENSE	297
1KF11	LLID (HEX) - ZONE CONTROLS	278
1TA2	POWER SUPPLY - CUSTOMER	244
1XD23	TERMINAL BLOCK - CUSTOMER CONNECTION	266, 267, 268, 269, 270
1XD24	TERMINAL BLOCK - CUSTOMER CONNECTION	272, 273, 274, 275, 276, 277
1XD25	TERMINAL BLOCK - CUSTOMER CONNECTION	279, 280, 281
1XD26	TERMINAL BLOCK - CUSTOMER CONNECTION	282, 283
2P1	USER INTERFACE	246
2QM5	REHEAT VALVE	242
2QM7	COOLING VALVE	243

NOTES:

- 1 REMOVE THE APPLICABLE GRAY JUMPER WHEN EMERGENCY OR EQUIPMENT STOP SWITCHES ARE INSTALLED.
- 2 USE CLASS 2 CIRCUIT ONLY
- 3 FUNCTIONAL EARTH TERMINAL PROVIDED FOR CUSTOMER CONTROLS WIRING

DESIGNER:	C.CATHCART
ENGINEER:	E.CAROTA
TRANE ® DATE:	09-SEP-2022
REPLACES:	
SIMILAR TO:	
REVISION DATE:	29-NOV-22
REVISED BY:	C.CATHCART
APPROVED BY:	E. CAROTA
CAD SYSTEM USED:	CREO SCHEMATICS

TRANE®

THIS DRAWING IS PROPRIETARY
AND SHALL NOT BE COPIED OR
ITS CONTENTS DISCLOSED TO
OUTSIDE PARTIES WITHOUT THE
WRITTEN CONSENT OF TRANE.

IPAK 2
CONTROLS SCHEMATIC
90-150T
CUSTOMER CONNECTIONS #

MASTER NUMBER:	DRAWING NUMBER:	SHEET:	REV
	12134650	5 OF 17	B