


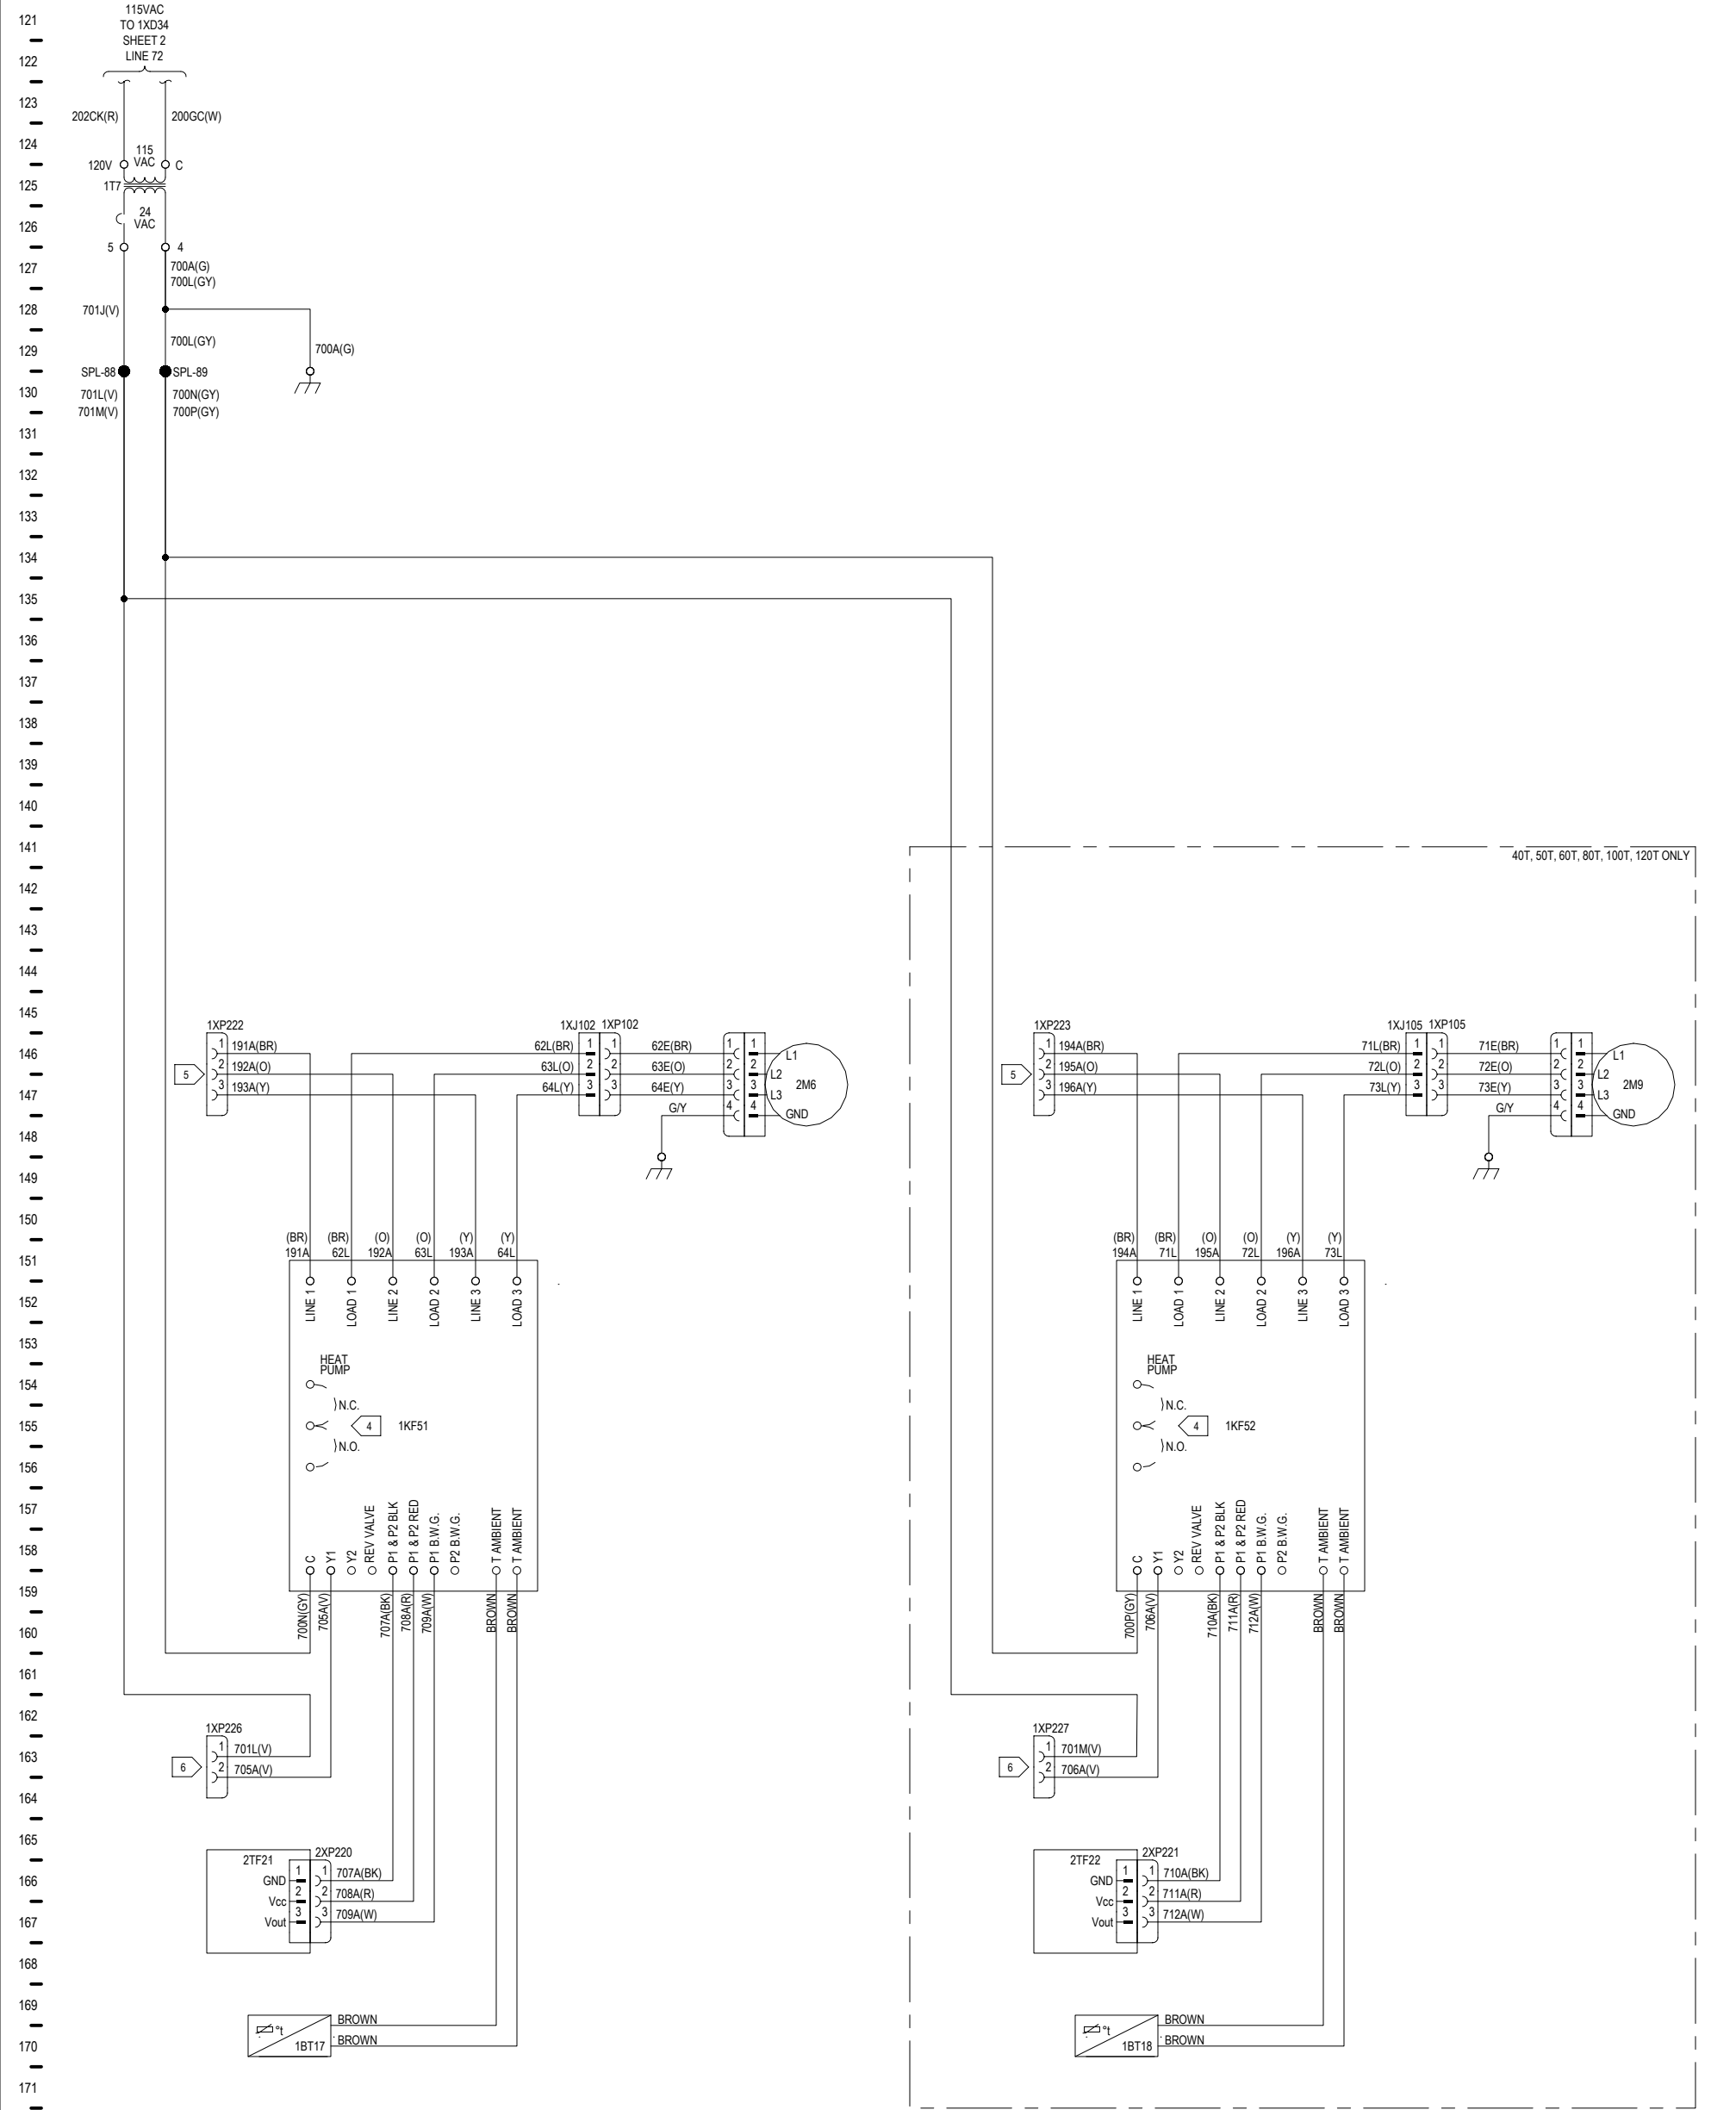

LEGEND		
REF DES	DESCRIPTION	LINE NO
1BT17	SENSOR - TEMPERATURE, CIRCUIT 1	170
1BT18	SENSOR - TEMPERATURE, CIRCUIT 2	170
1KF51	LOW AMBIENT CONTROLLER, CIRCUIT 1	152
1KF52	LOW AMBIENT CONTROLLER, CIRCUIT 2	152
1T7	TRANSFORMER - 24VAC	124
2M6	CONDENSER FAN MOTOR 1A	146
2M9	CONDENSER FAN MOTOR 2A	146
2TF21	TRANSDUCER - PRESSURE, CIRCUIT 1	166
2TF22	TRANSDUCER - PRESSURE, CIRCUIT 2	166

NOTES: (SEE SHEET 1 FOR STANDARD NOTES 1-3, WIRE COLOR & SYMBOL LEGEND TABLES.)

- 4 JUMPER SHOULD BE PLACED IN N.O. POSITION.
- 5 SEE UNIT POWER SCHEMATIC FOR BALANCE OF CIRCUIT.
- 6 SEE UNIT CONTROLS SCHEMATIC FOR BALANCE OF CIRCUIT.

DESIGNER:	R. JOHNSON
ENGINEER:	S. MCKINLEY
TRANE © DATE:	19-SEP-2023
REPLACES:	
SIMILAR TO:	
REVISION DATE:	16-JUL-2024
REVISED BY:	A. BREWINGTON
APPROVED BY:	S. MCKINLEY
CAD SYSTEM USED:	CREO SCHEMATICS

TRANE®

THIS DRAWING IS PROPRIETARY AND SHALL NOT BE COPIED OR ITS CONTENTS DISCLOSED TO OUTSIDE PARTIES WITHOUT THE WRITTEN CONSENT OF TRANE.

INTELLICORE CA
SCHEMATIC
OPTIONAL LOW AMBIENT CONTROLS

MASTER NUMBER:	DRAWING NUMBER:	SHEET:	REV
	12134880	3	B