


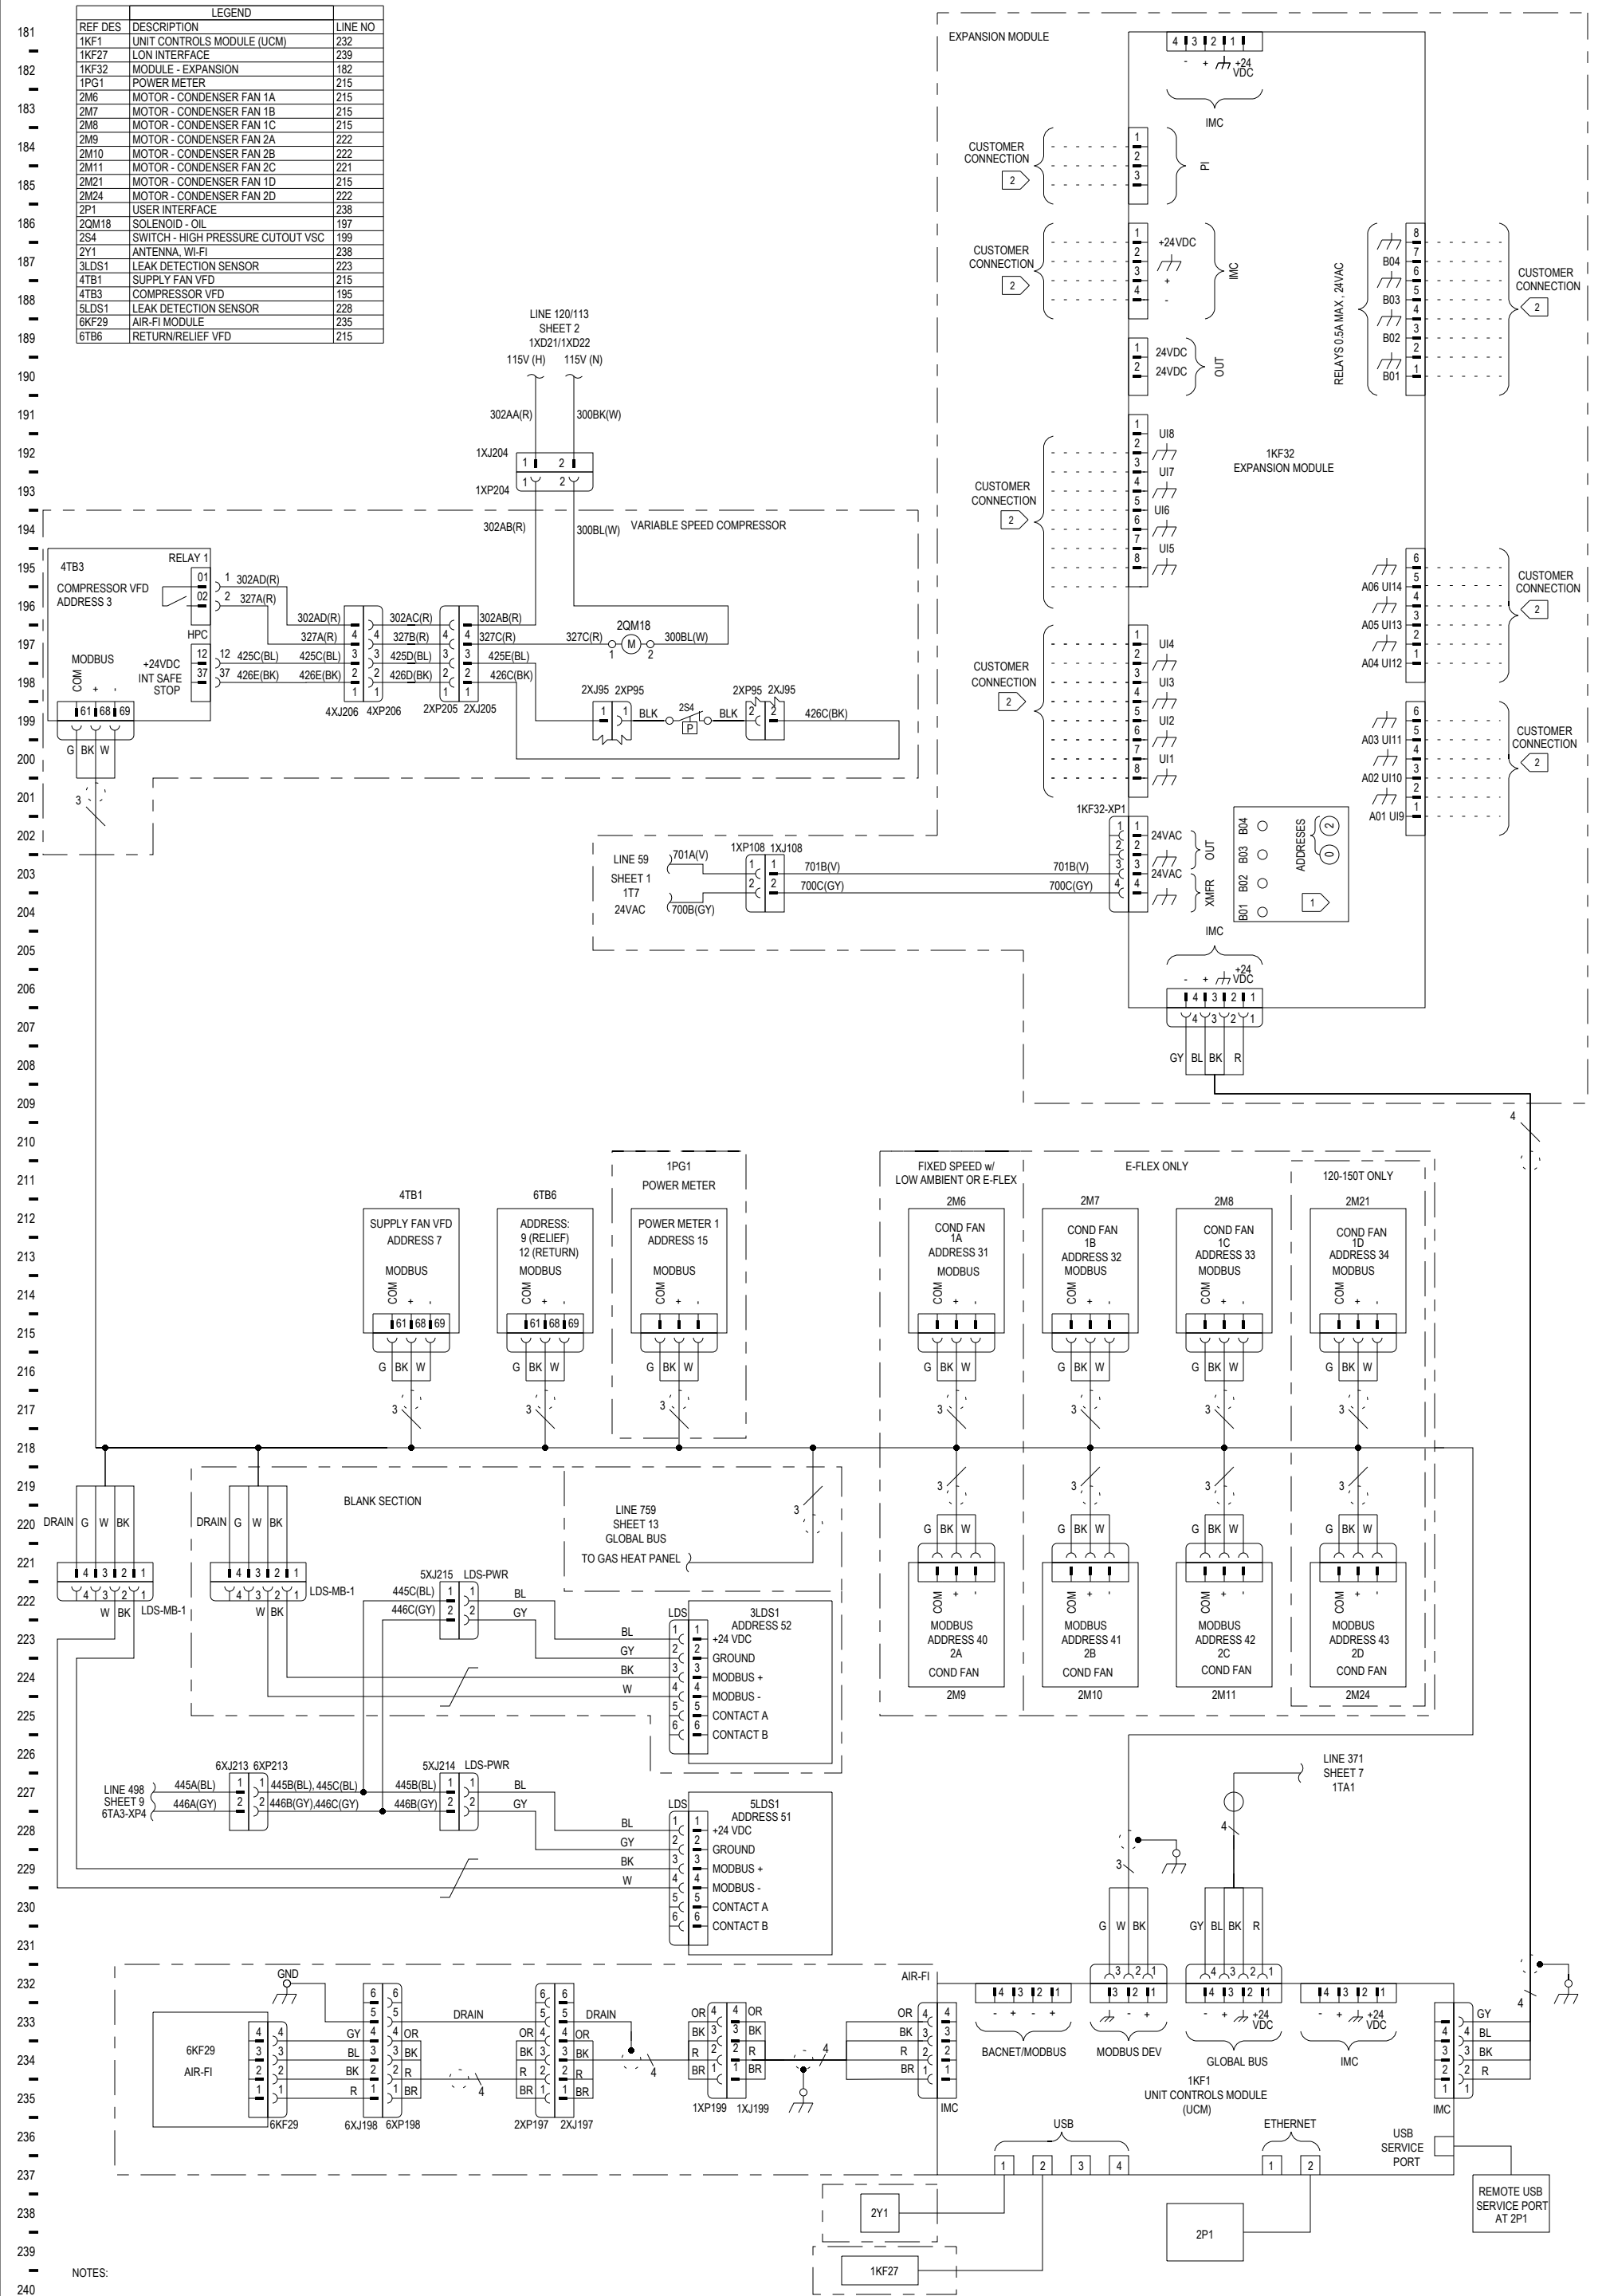

- NOTES:
- 1 1KF32 ADDRESS DIALS MUST BE SET TO "02".
 - 2 CUSTOMER PROVIDED DRY CONTACTS SHOULD BE RATED FOR 5VDC / 5mA CONTROL CIRCUIT. USE CLASS 2 CIRCUIT ONLY.

DESIGNER:	T. PEED
ENGINEER:	J. PLUMMER
TRANE © DATE:	11/1/2023
REPLACES:	
SIMILAR TO:	
REVISION DATE:	04/10/2024
REVISED BY:	A. WAELDE
APPROVED BY:	J. PLUMMER
CAD SYSTEM USED:	CREO SCHEMATICS

TRANE®

THIS DRAWING IS PROPRIETARY AND SHALL NOT BE COPIED OR ITS CONTENTS DISCLOSED TO OUTSIDE PARTIES WITHOUT THE WRITTEN CONSENT OF TRANE.

IPAK 2
CONTROLS SCHEMATIC
90-150T
UNIT CONTROLS

MASTER NUMBER:	DRAWING NUMBER:	SHEET:	REV
	12134899	4 OF 17	C