


61 -
62 -
63 -
120 -

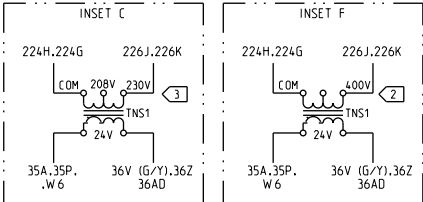


CAUTION
USE COPPER CONDUCTORS ONLY!
UNIT TERMINALS ARE NOT DESIGNED TO ACCEPT OTHER TYPES OF CONDUCTORS.
FAILURE TO DO SO MAY CAUSE DAMAGE TO THE EQUIPMENT.

ATTENTION
N'UTILISER QUE DES CONDUCTEURS EN CUIVRE!
LES BORNES DE L'UNITÉ NE SONT PAS CONÇUES POUR RECEVOIR D'AUTRES TYPES DE CONDUCTEURS.
L'UTILISATION DE TOUT AUTRE CONDUCTEUR PEUT ENDOMMAGER L'EQUIPEMENT.

PRECAUCIÓN
¡UTILICE ÚNICAMENTE CONDUCTORES DE COBRE!
LAS TERMINALES DE LA UNIDAD NO ESTÁN DISEÑADAS PARA ACEPTAR OTROS TIPOS DE CONDUCTORES.
SI NO LO HACE, PUEDE OCASIONAR DAÑO AL EQUIPO.

LEGEND		
DEVICE DESIG	DESCRIPTION	LINE NUMBER
ODF37	OUTDOOR FAN RELAY	98
ODF38	OUTDOOR FAN RELAY	99
RTRM	REFRIGERATION MODULE	98
TNS1	CONTROLS POWER TRANSFORMER	94

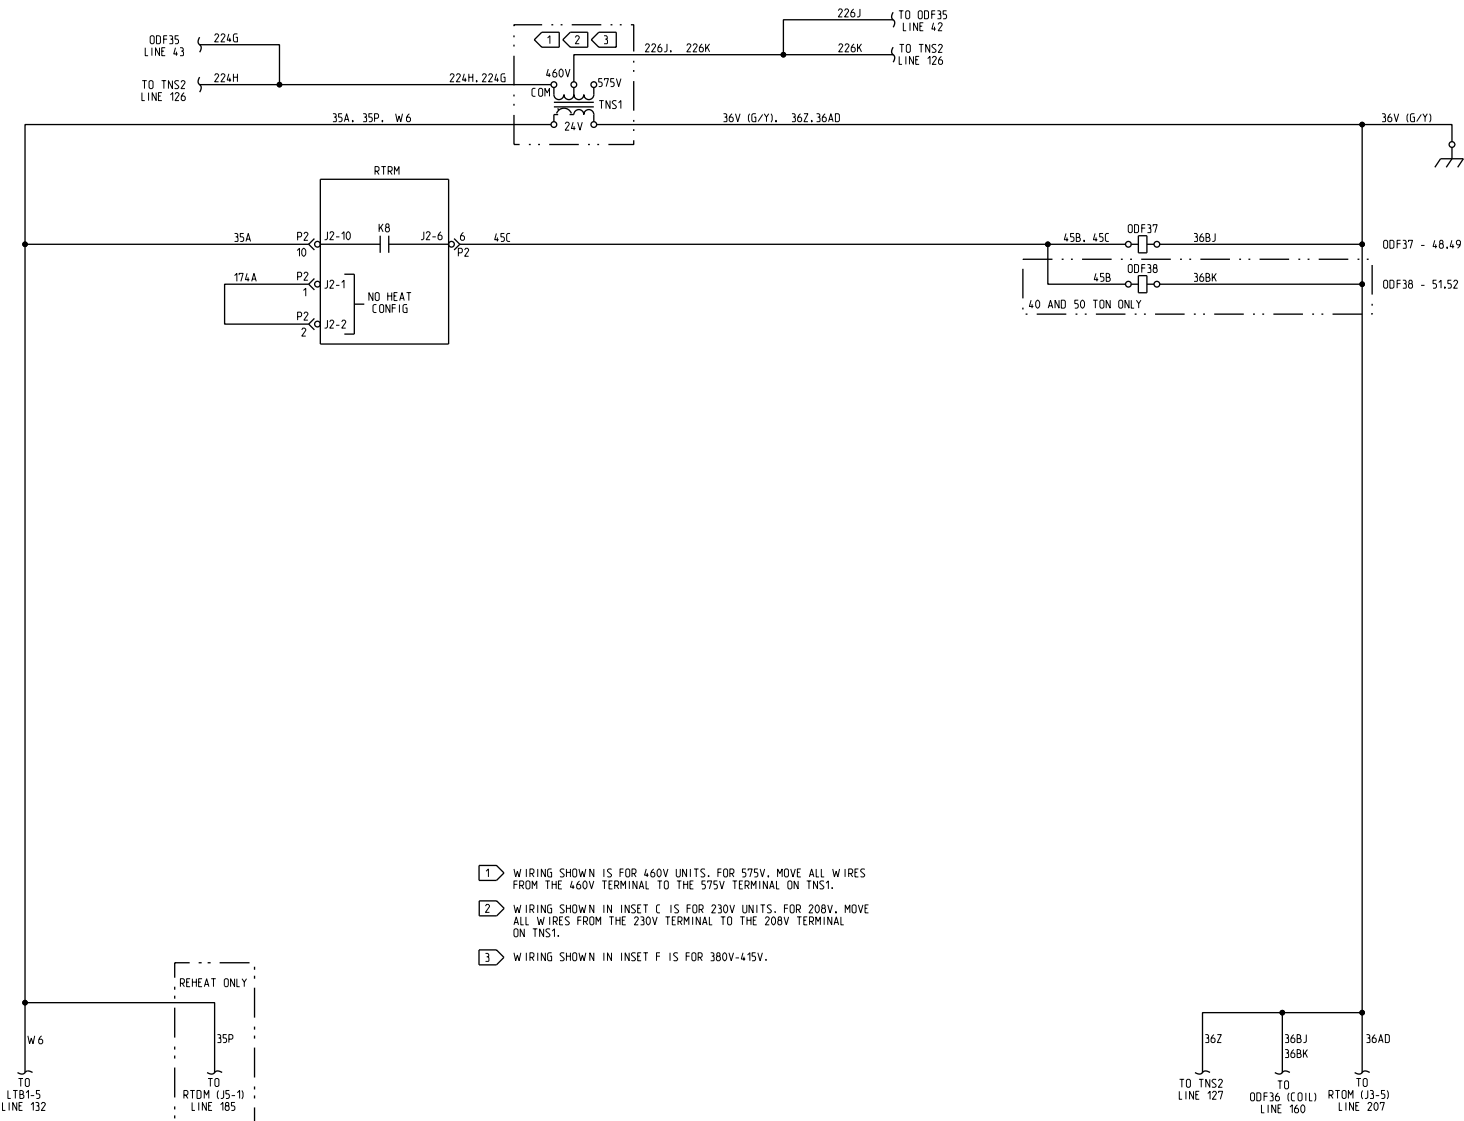

- 1 WIRING SHOWN IS FOR 460V UNITS. FOR 575V, MOVE ALL WIRES FROM THE 460V TERMINAL TO THE 575V TERMINAL ON TNS1.
- 2 WIRING SHOWN IN INSET C IS FOR 230V UNITS. FOR 208V, MOVE ALL WIRES FROM THE 230V TERMINAL TO THE 208V TERMINAL ON TNS1.
- 3 WIRING SHOWN IN INSET F IS FOR 380V-415V.

TRAN				FILE NUMBER	DRAWING NUMBER	SHEET	REV
THIS DRAWING IS FOR THE UNIT ONLY. IT DOES NOT INCLUDE THE WIRING FOR THE PARTS OF THE UNIT WHICH ARE NOT SHOWN IN THIS DRAWING.				1213-0328	1213-0336	1 OF 1	A
DRAWN BY: J. MC CAULEY CHECKED BY: J. MC CAULEY DATE: 07/24/14 REVISION DATE: 07/24/14 PROJ/DRAWING: 2313-1279				VOYAGER 3 HEAT POWER AND CONTROLS SCHEMATIC (COOLING ONLY - HIGH EFFICIENCY)			