


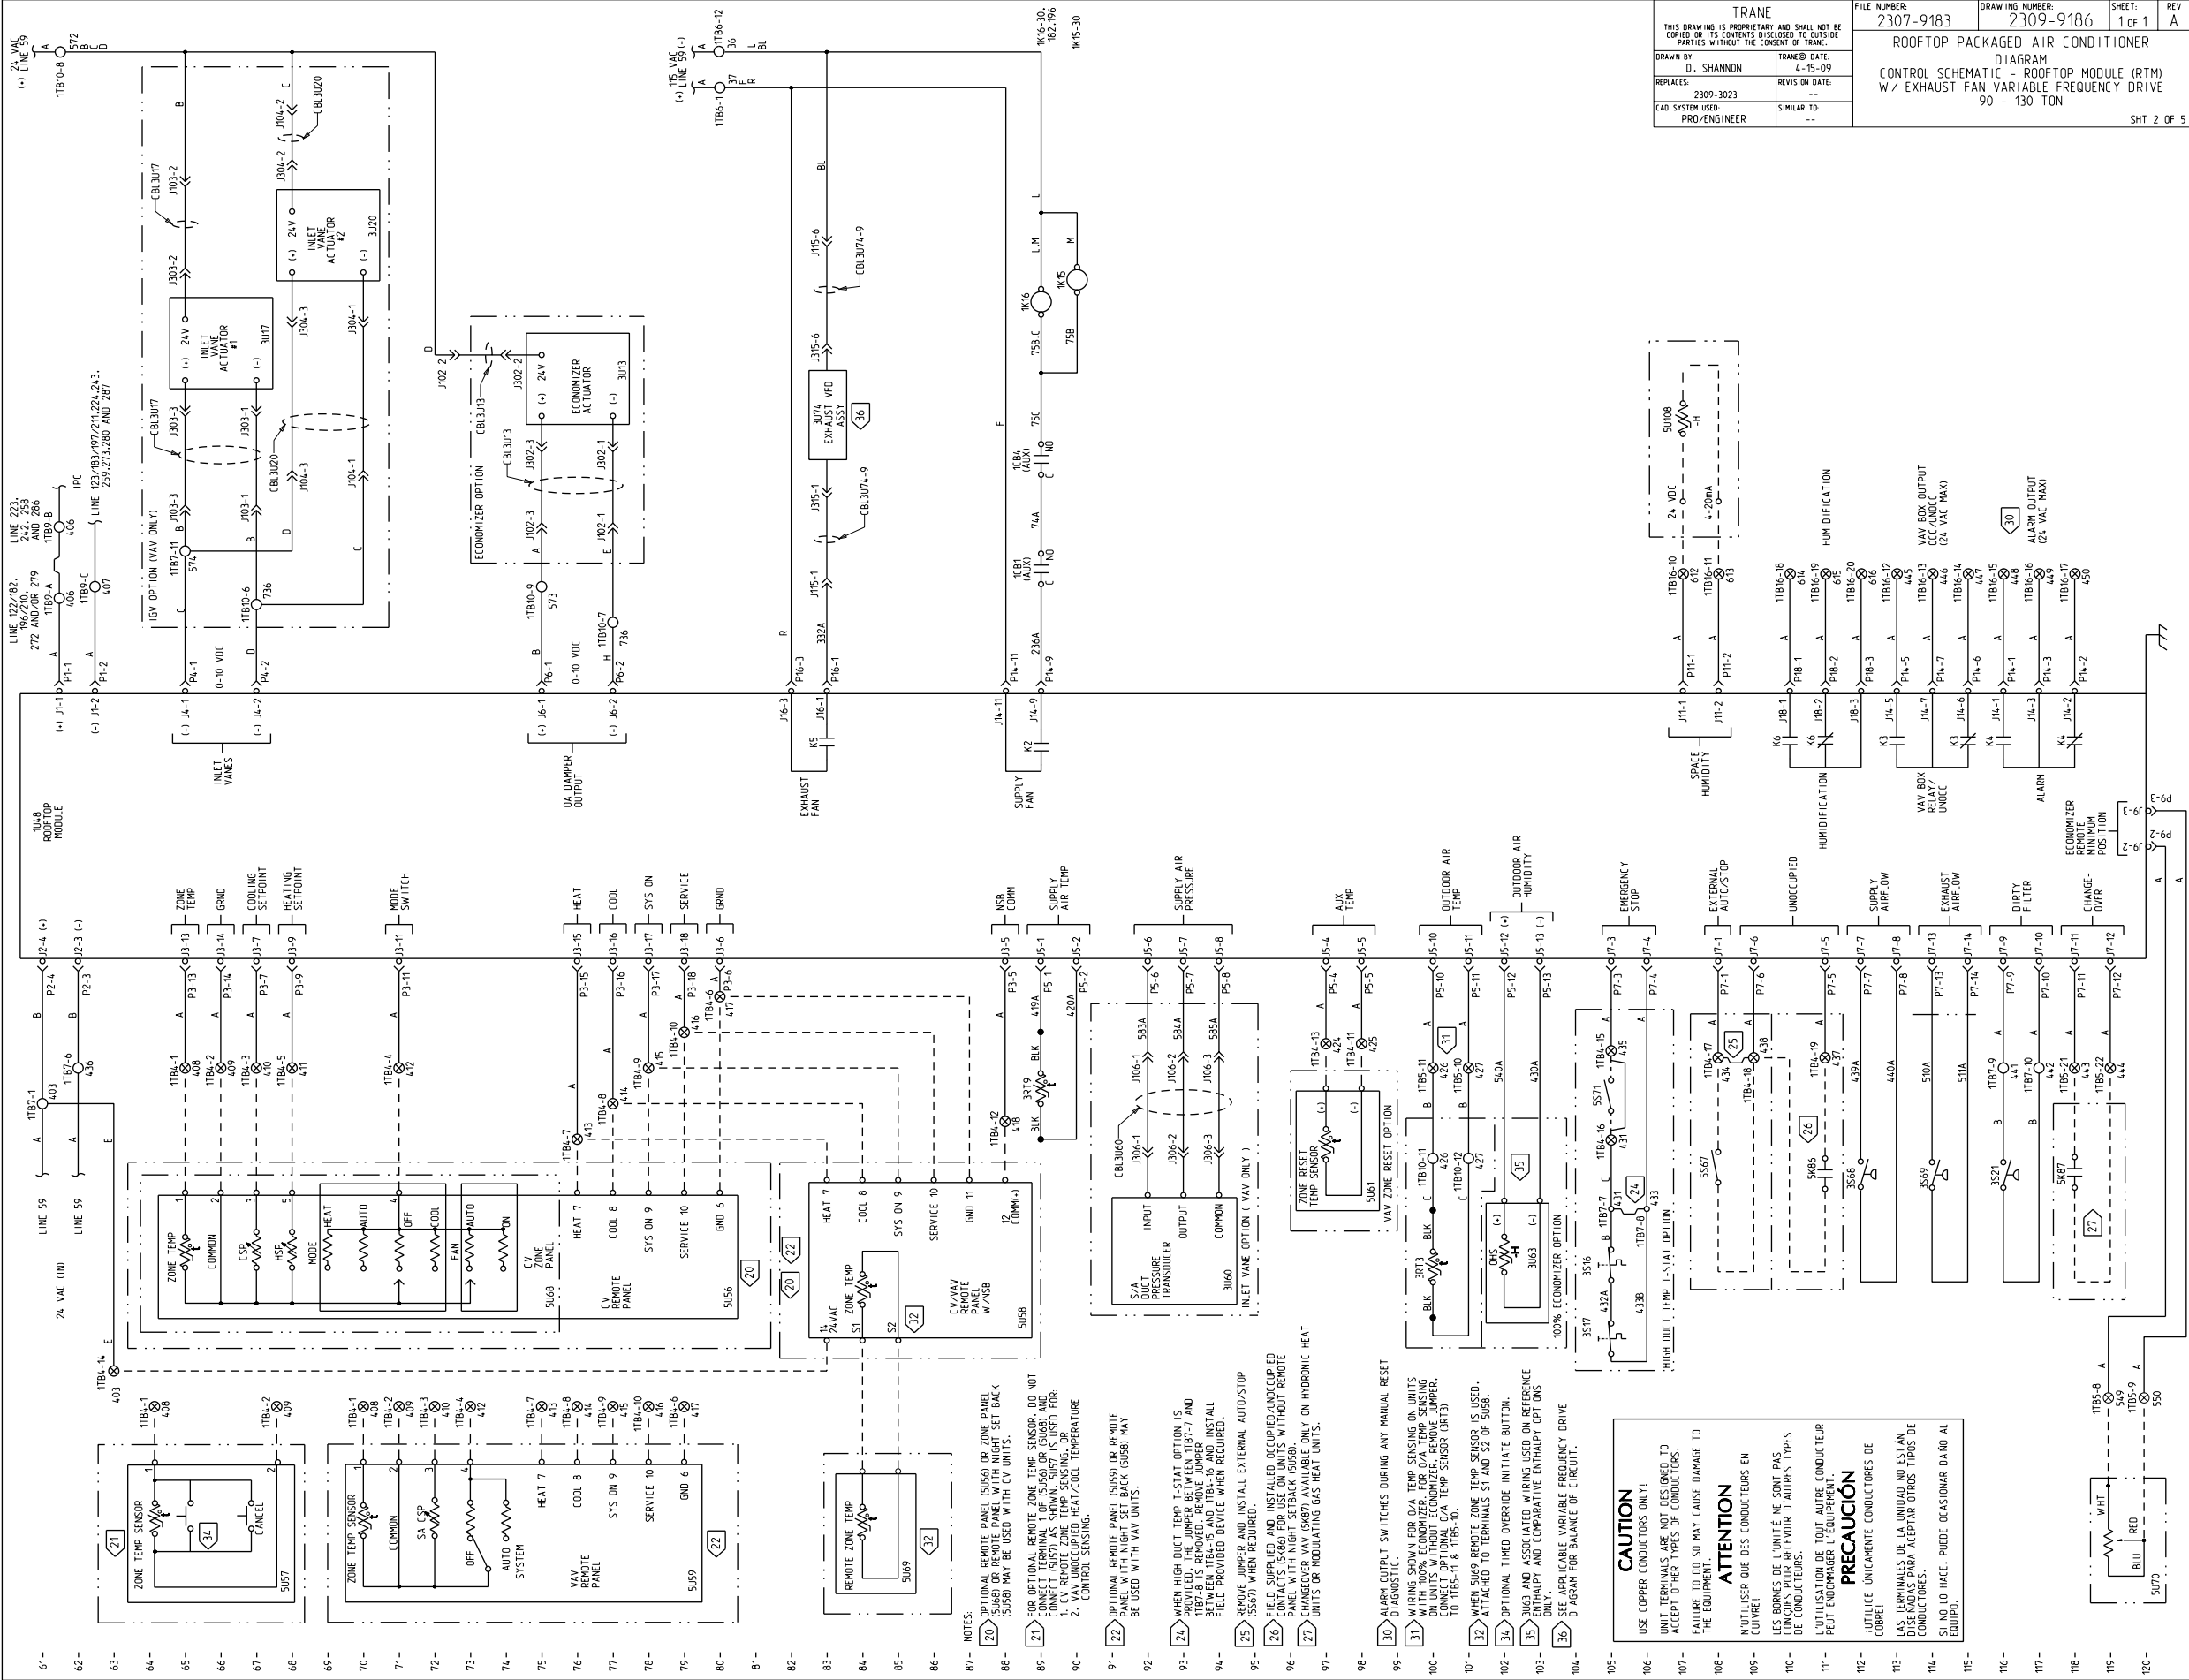

TRANE		FILE NUMBER:	DRAWING NUMBER:	SHEET:	REV
THIS DRAWING IS PROPRIETARY AND SHALL NOT BE COPIED OR ITS CONTENTS DISCLOSED TO THIRD PARTIES WITHOUT THE CONSENT OF TRANE.		2307-9183	2309-9186	1 OF 1	A
DRAWN BY:		ROOFTOP PACKAGED AIR CONDITIONER			
D. SHANNON		DIAGRAM			
REPLACES:		CONTROL SCHEMATIC - ROOFTOP MODULE (RTM)			
2309-3023		W/ EXHAUST FAN VARIABLE FREQUENCY DRIVE			
CAD SYSTEM USED:		90 - 130 TON			
PRO/ENGINEER		SHT 2 OF 5			