

NOTES:

- 1 WIRING SHOWN IS FOR 230V. FOR 208V MOVE ALL WIRES FROM 230V TERMINAL TO 208V TERMINAL ON TNS1,TNS2 AND TNS5.
- 3 WIRE NUMBER 36AE IS NOT USED FOR TC-600.
- 4 REQUIRED FOR OPTIONAL REFERENCE ENTHALPY CONTROL
- 5 REQUIRED FOR OPTIONAL COMPARATIVE ENTHALPY CONTROL
- 6 LPC1, LPC2 ARE LOW PRESSURE CUTOUT SWITCHES USED FOR COMPRESSOR PROTECTION. CAUTION!! DO NOT JUMPER ACROSS SWITCHES UNDER ANY CIRCUMSTANCES. TO DISABLE COMPRESSORS, REMOVE JUMPERS AND CONNECT FIELD SUPPLIED DEVICE.
- 9 XFR CAN BE FOUND ON LINES 20,21 & 115.
- 10 REMOVE JUMPER BETWEEN LTB-5 AND LTB-6 AND INSTALL FIELD PROVIDE DEVICE WHEN REQUIRED.
- 11 TO ENABLE COMPRESSOR LEAD/LAG OPERATION, CUT WIRE 36AG.

- 16 TERMINALS 7,8,9 & 10 ARE FOR OPTIONAL INDICATORS.
- 17 INSET D IS FOR OPTIONAL PROGRAMMABLE ZONE SENSOR.
- 18 AUXILIARY RELAY ENERGIZED DURING OCCUPIED PERIODS.
- 19 0-10 VDC DUCT MOUNTED SENSOR ONLY.
- 21 PROVIDE CONTACT CLOSURE BETWEEN RTRM J6-11 & RTRM J6-12 TO ENABLE UNOCCUPIED MODE WHEN NOT USING PROGRAMMABLE ZSM/REMOTE PANEL OR BMS.
- 22 EBA REQUIRED FOR OPTIONAL FRESH AIR TRACKING EXHAUST.
- 23 OPTIONAL VENTILATION OVERRIDE

WARNING

HAZARDOUS VOLTAGE!
DISCONNECT ALL ELECTRIC POWER INCLUDING REMOTE DISCONNECTS BEFORE SERVICING.
FAILURE TO DISCONNECT POWER BEFORE SERVICING CAN CAUSE SEVERE PERSONAL INJURY OR DEATH.



AVERTISSEMENT

VOLTAGE HASARDEUX!
DECONNECTEZ TOUTES LES SOURCES ELECTRIQUES INCLUANT LES DISJONCTEURS SITUÉS A DISTANCE AVANT D'EFFECTUER L'ENTRETIEN.
FAUTE DE DECONNECTER LA SOURCE ELECTRIQUE AVANT D'EFFECTUER L'ENTRETIEN PEUT ENTRAINER DES BLESSURES CORPORELLES SEVERES OU LA MORT.


CAUTION

USE COPPER CONDUCTORS ONLY!
UNIT TERMINALS ARE NOT DESIGNED TO ACCEPT OTHER TYPES OF CONDUCTORS.
FAILURE TO DO SO MAY CAUSE DAMAGE TO THE EQUIPMENT.

• • LEGEND • •		
DEVICE DESIGNATION	DESCRIPTION	LINE NUMBER
CC1	COMPRESSOR CONTACTOR #1	76
CC2	COMPRESSOR CONTACTOR #2	77
CC3	COMPRESSOR CONTACTOR #3	78
CFS	CLOGGED FILTER SWITCH	111
CO2 SENSOR	CO2 SENSOR	115
COMM	COMMUNICATIONS MODULE	99
DTS	DISCHARGE TEMP SENSOR	105
ECA	ECONOMIZER ACTUATOR	107
F	IDM FAN CONTACTOR	75
FFS	FAN FAILURE SWITCH	113
FIRE PANEL	FIRE PANEL	115
FOS1	FROSTAT 1	119
FOS2	FROSTAT 2	119
HPC1	HIGH PRESSURE CUTOUT #1	76
HPC2	HIGH PRESSURE CUTOUT #2	77
LPC1	LOW PRESSURE CUTOUT #1	81
LPC2	LOW PRESSURE CUTOUT #2	83
MAS	MIXED AIR SENSOR	107
OAS	OUTSIDE AIR SENSOR	79
ODF20	OUTDOOR FAN RELAY #20	83

• • LEGEND • •		
DEVICE DESIGNATION	DESCRIPTION	LINE NUMBER
ODF34	OUTDOOR FAN RELAY #34	84
OHS	OUTSIDE HUMIDITY SENSOR	113
RAS	RETURN AIR SENSOR	109
RHS	RETURN HUMIDITY SENSOR	111
RHT	RETURN HIGH TEMP.	79
RMP	REMOTE MINIMUM POSITION	111
RTOM	OPTIONS MODULE	93
RTRM	REFRIGERATION MODULE	74,108
SHT	SUPPLY HIGH TEMP.	79
THERMOSTAT	THERMOSTAT	88
TNS1	CONTROL TRANSFORMER	70
TNS2	CONTROL TRANSFORMER	74
TNS5	CONTROL TRANSFORMER	72
WTL1	WINDING TEMP LIMIT #1	76
WTL2	WINDING TEMP LIMIT #2	77
WTL3	WINDING TEMP LIMIT #3	77
XFR	EXHAUST FAN RELAY	115
ZSM	ZONE SENSOR MODULE	96,108
EBA	EXHAUST BLADE ACTUATOR	113

- 15 INSTALL OPTIONAL REMOTE SENSOR TO TERMINALS S1 AND S2 WHEN REQUIRED. SEE PROGRAMMABLE ZONE SENSOR / REMOTE PANEL W/NSB LITERATURE FOR OPTION CONFIGURATION.

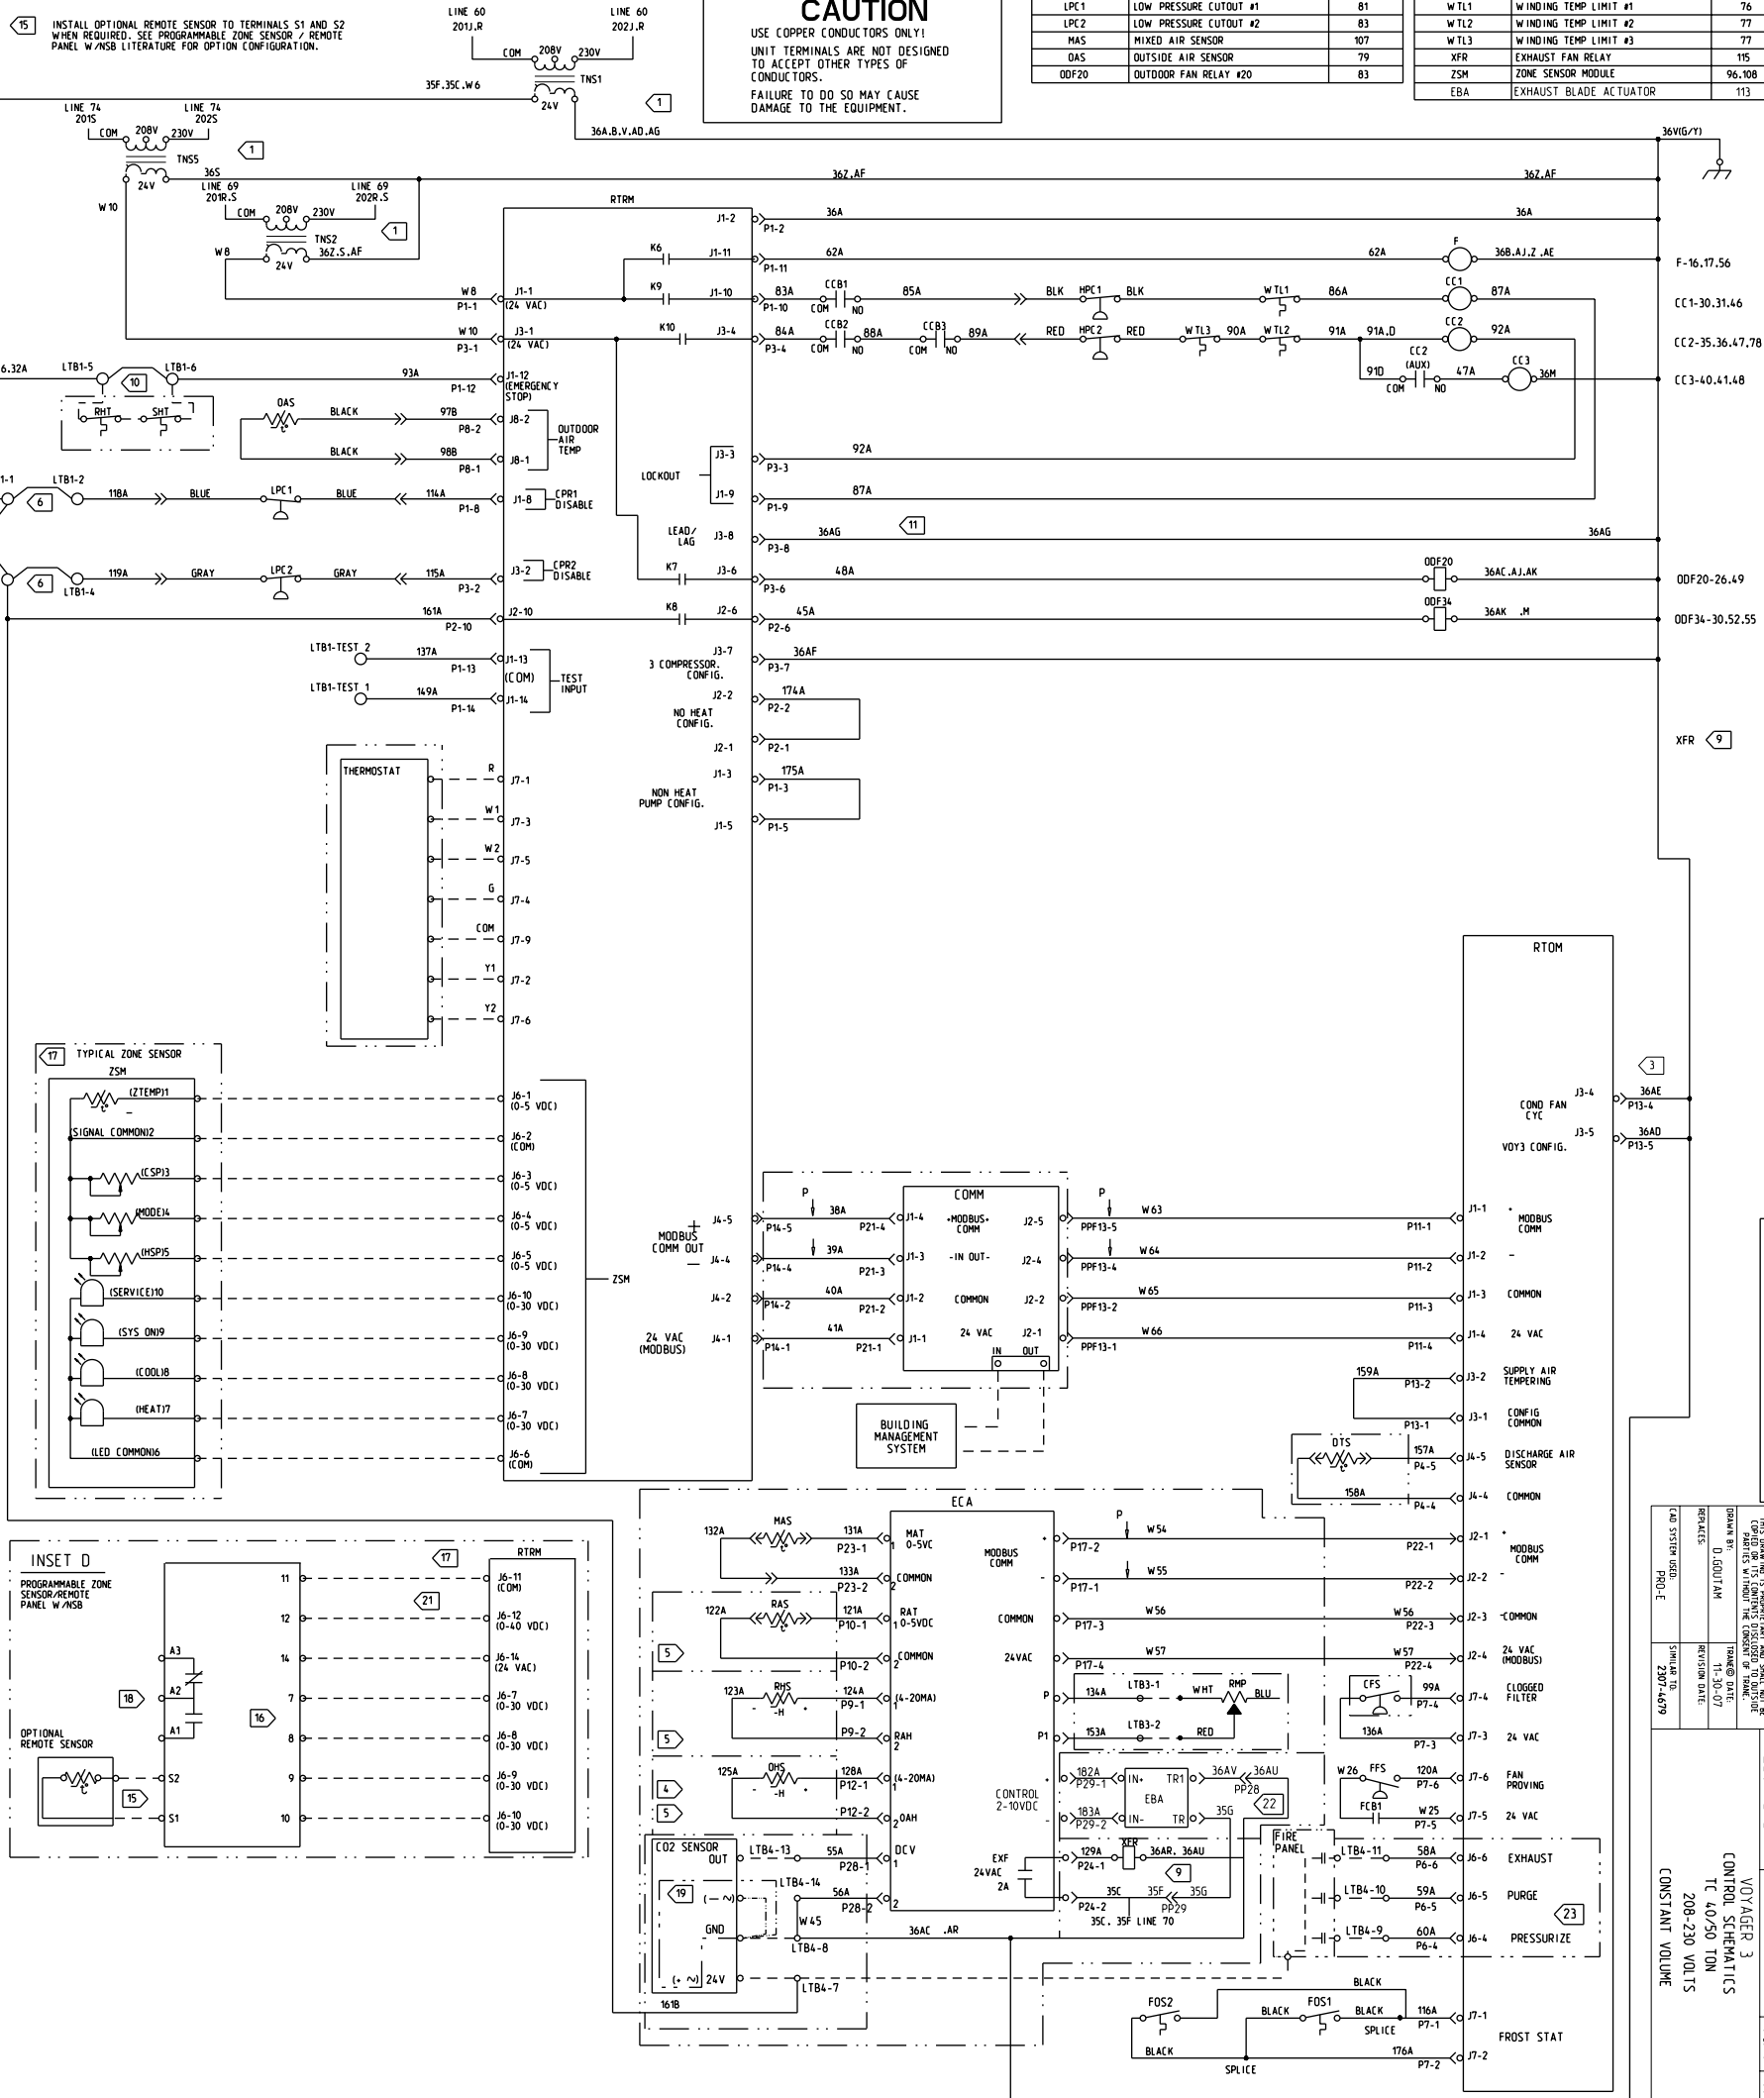

METAL PLATE 11 X 17

TRANSFORMER

FILE NUMBER

2309-3439

DRAWING NUMBER

2309-3452

SHEET

1 OF 1

REV

A

THIS DRAWING IS A PROPERTY OF THE COMPANY AND SHALL NOT BE REPRODUCED OR TRANSMITTED IN ANY FORM OR BY ANY MEANS, ELECTRONIC OR MECHANICAL, INCLUDING PHOTOCOPYING, RECORDING, OR BY ANY INFORMATION STORAGE AND RETRIEVAL SYSTEM, WITHOUT THE WRITTEN PERMISSION OF THE COMPANY.			
DRAWN BY:	DATE:	TRACED DATE:	DATE:
REVISIONS:	DATE:	REVISION DATE:	DATE:
CAD SYSTEM USED:	PROJ. NO.	SHEET NO.	DATE:

VOYAGER 3
CONTROL SCHEMATICS
TC 40/50 TON
208-230 VOLTS
CONSTANT VOLUME