


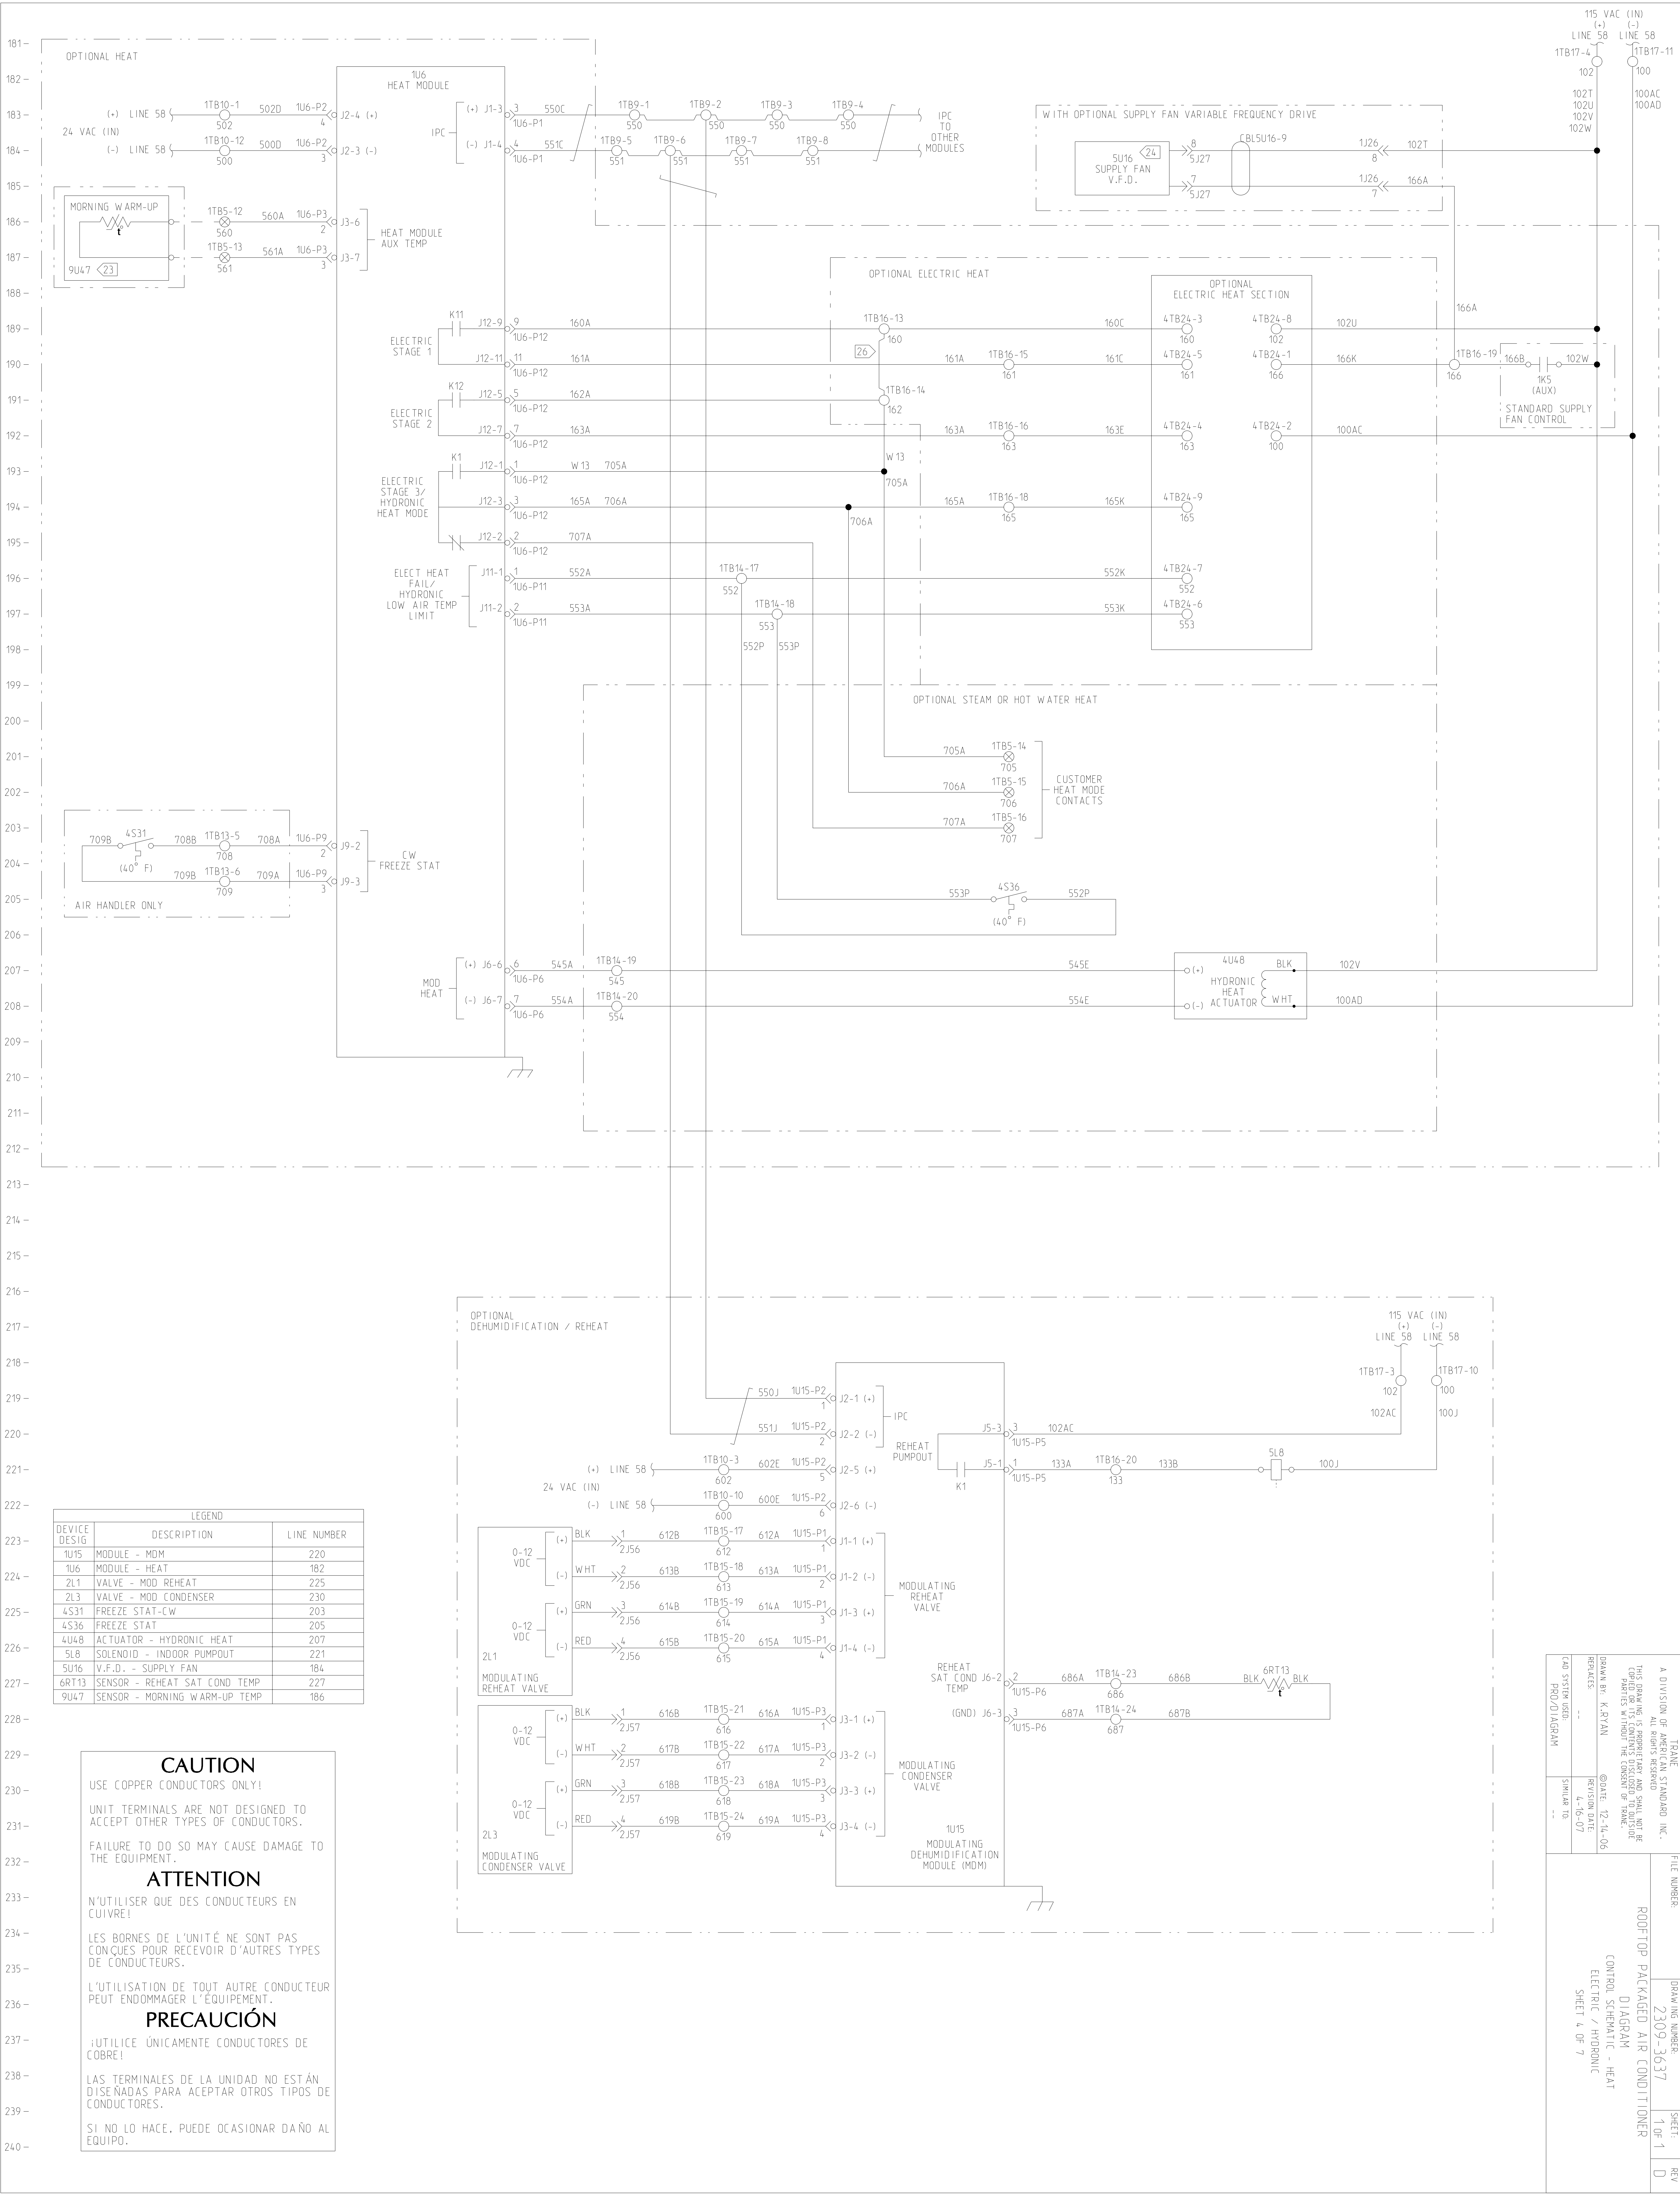

A DIVISION OF AMERICAN STANDARD, INC.		FILE NUMBER:	DRAWING NUMBER:	SHEET:	REV:
THIS DRAWING IS THE PROPERTY OF AMERICAN STANDARD, INC. AND IS NOT TO BE REPRODUCED OR COPIED IN ANY MANNER WITHOUT THE WRITTEN CONSENT OF AMERICAN STANDARD, INC.		2309-3637	1 OF 1	D	
DRAWN BY: K. RYAN		ROOF-TOP PACKAGED AIR CONDITIONER			
REVISION DATE: 4-16-07		CONTROL SCHEMATIC - HEAT			
PRO-D SYSTEM USED		ELECTRIC / HYDRONIC			
SIMILAR TO: --		SHEET 4 OF 7			