


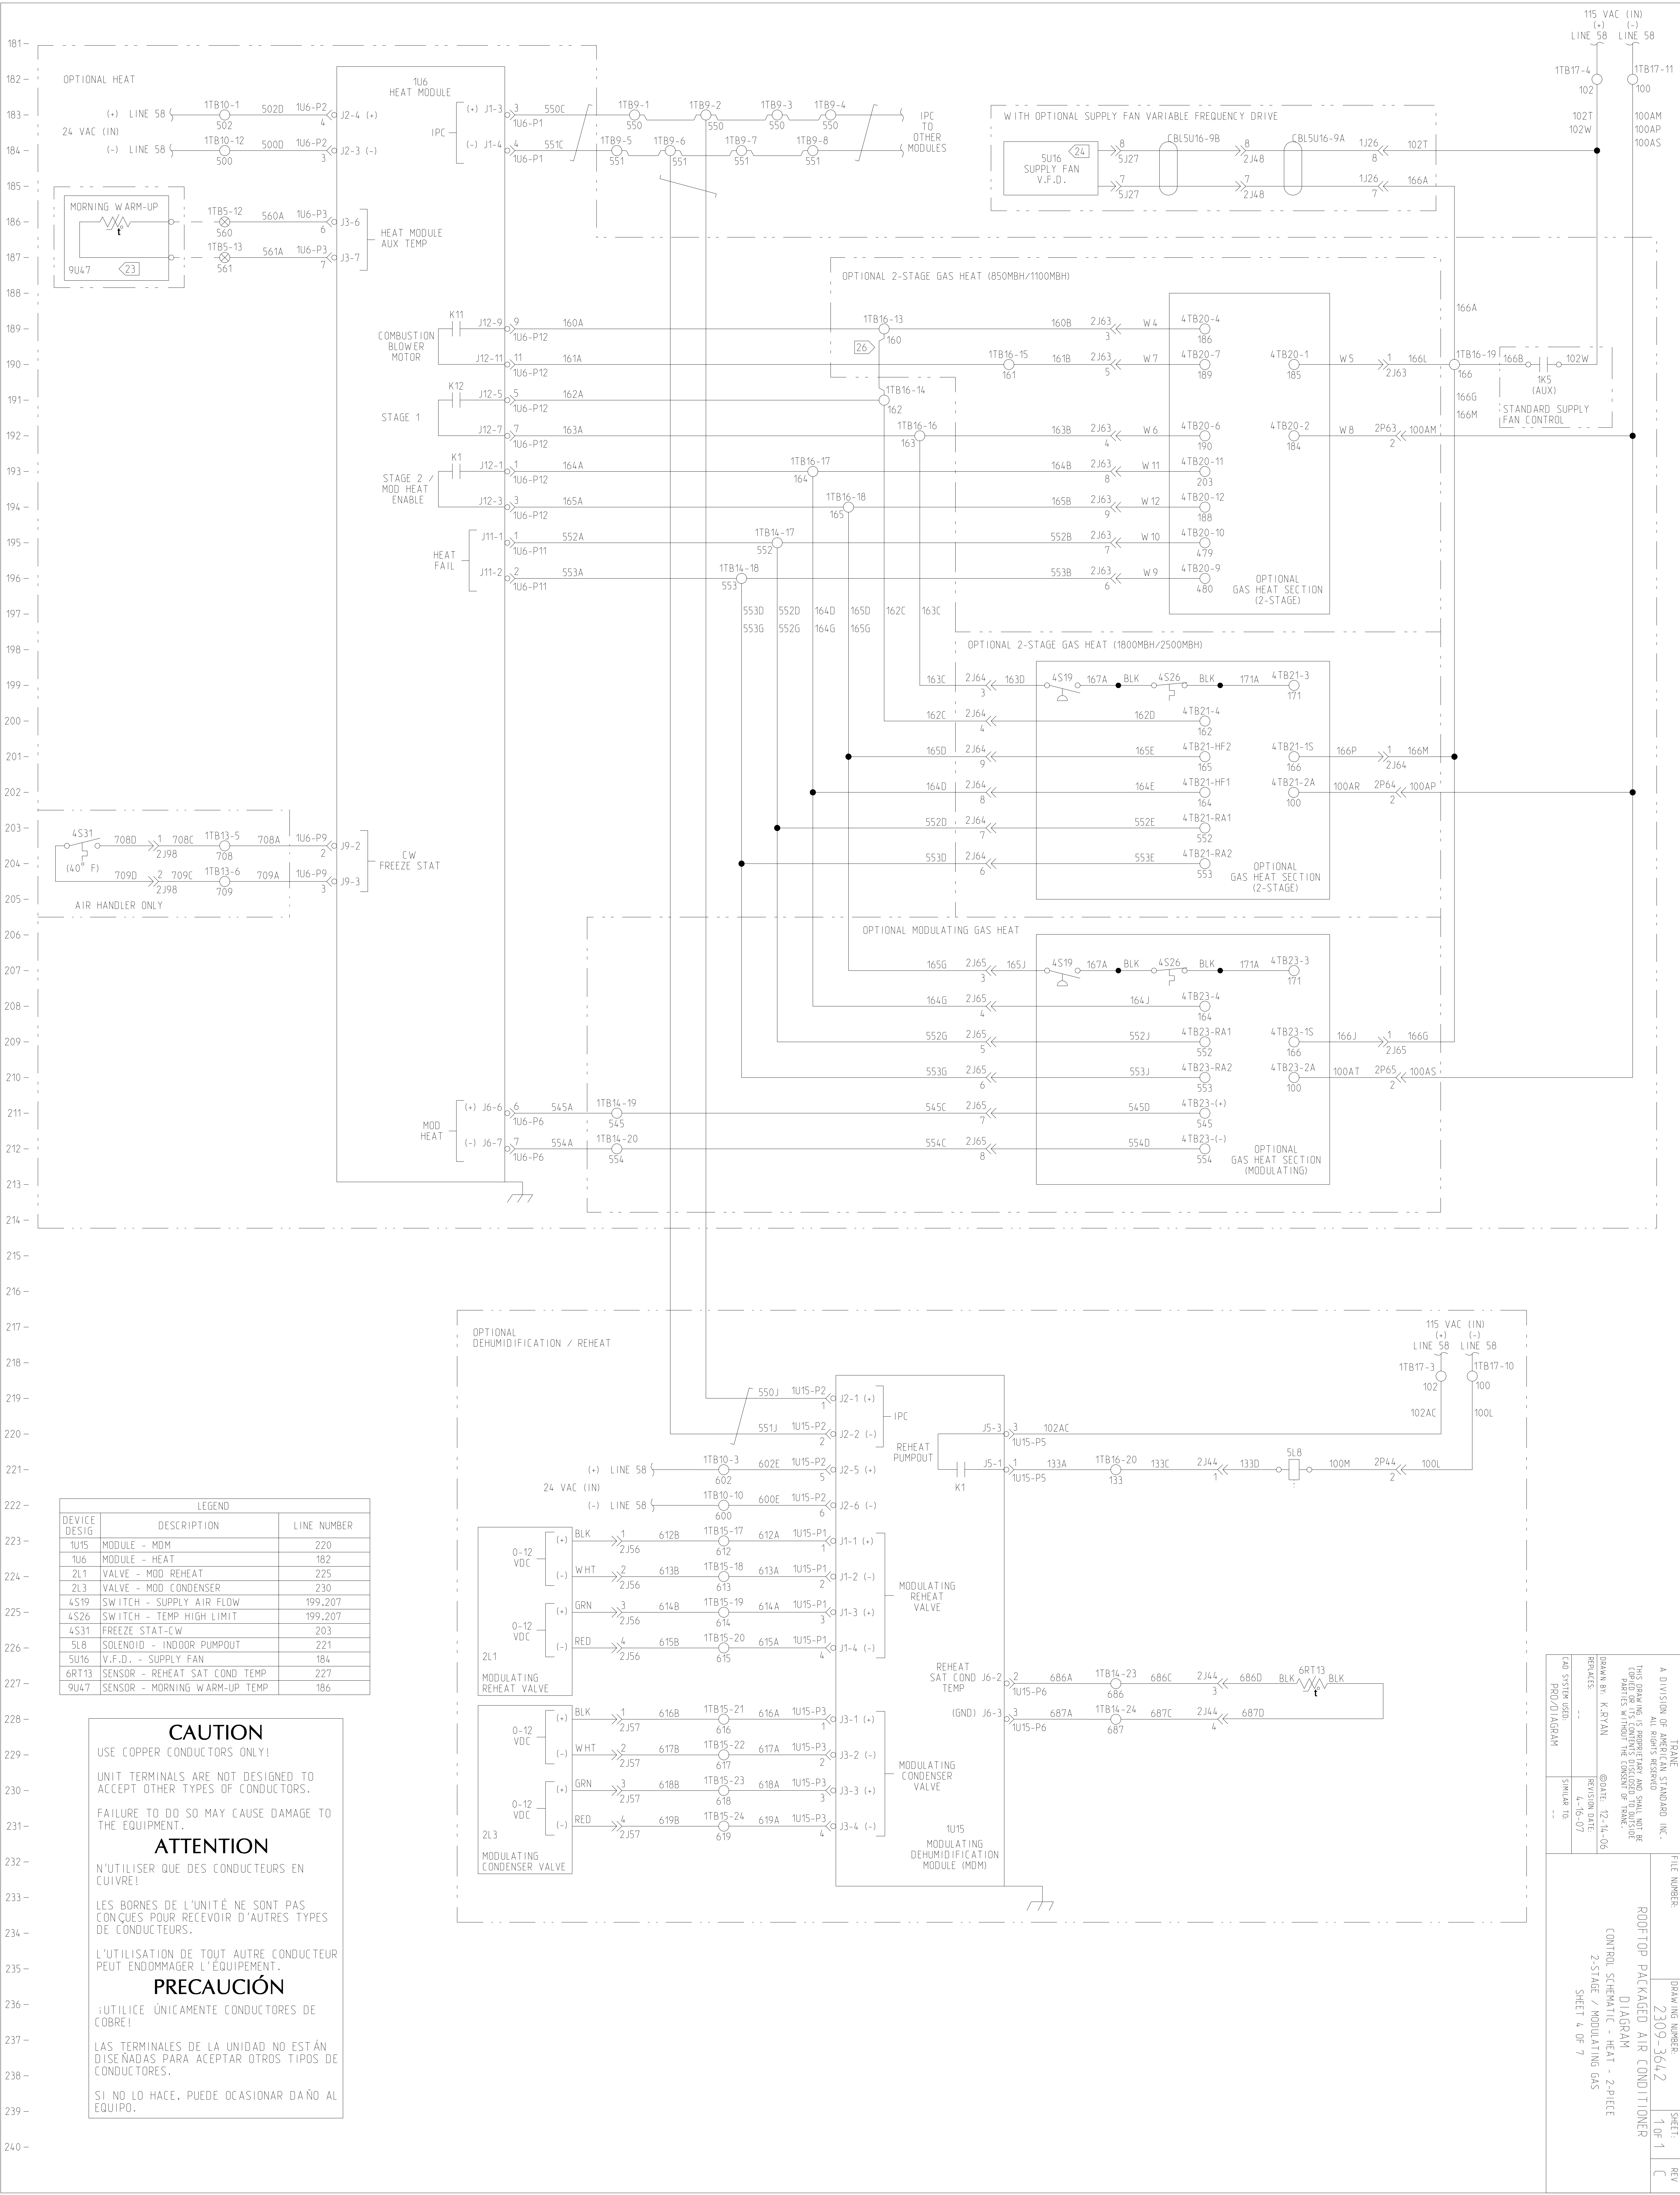

A DIVISION OF AMERICAN STANDARD, INC.		FILE NUMBER:	DRAWING NUMBER:	SHEET:	REV:
TEANE			2309-3642	1 OF 1	C
THIS DRAWING IS THE PROPERTY OF AMERICAN STANDARD, INC. AND IS NOT TO BE COPIED OR ITS CONTENTS DISCLOSED TO OTHERS WITHOUT THE WRITTEN CONSENT OF TRANE.					
DRAWN BY: K. RYAN		ROOF-TOP PACKAGED AIR CONDITIONER			
@DATE: 12-14-06		DIAGRAM			
REVISIONS:		CONTROL SCHEMATIC - HEAT - 2-PIECE			
--		2-STAGE / MODULATING GAS			
REVISION DATE:		SHEET 4 OF 7			
4-16-07					
TWO SYSTEM USED					
PRO-DIAGRAM					