


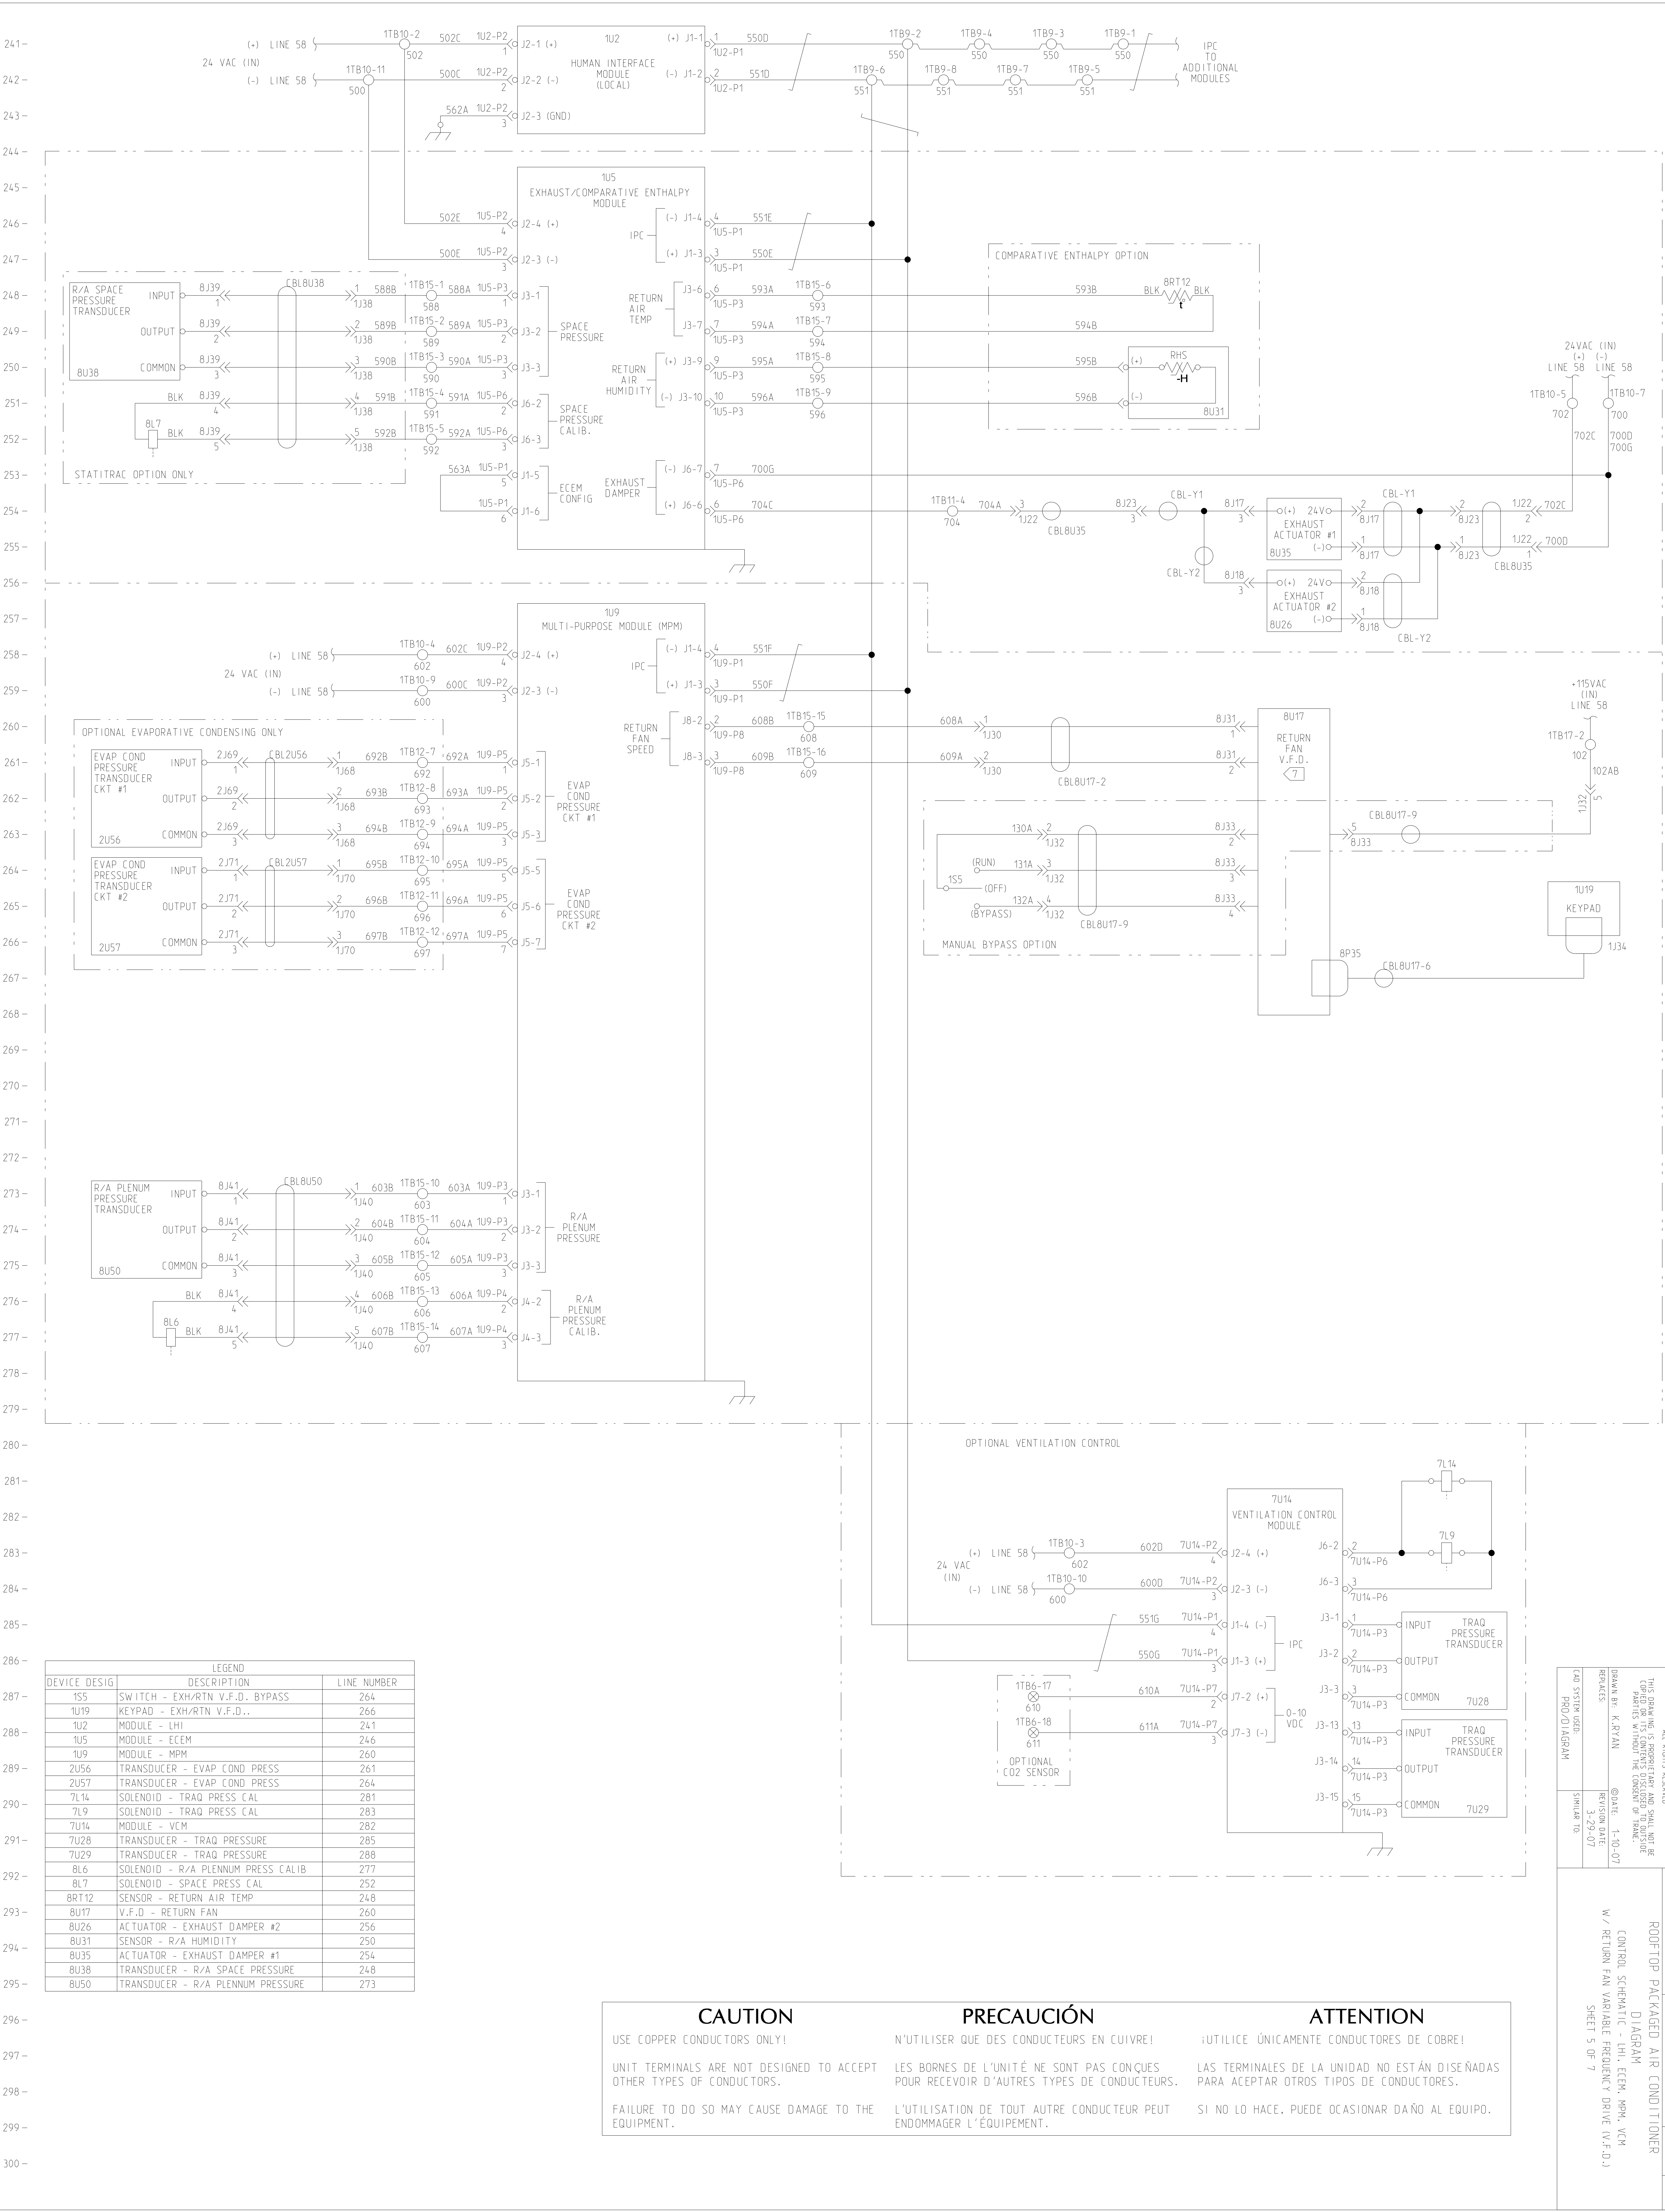

LEGEND		
DEVICE DESIG	DESCRIPTION	LINE NUMBER
1S5	SWITCH - EXH/RTN V.F.D. BYPASS	264
1U19	KEYPAD - EXH/RTN V.F.D..	266
1U2	MODULE - LHI	241
1U5	MODULE - ECEM	246
1U9	MODULE - MPM	260
2U56	TRANSDUCER - EVAP COND PRESS	261
2U57	TRANSDUCER - EVAP COND PRESS	264
7L14	SOLENOID - TRAQ PRESS CAL	281
7L9	SOLENOID - TRAQ PRESS CAL	283
7U14	MODULE - VCM	282
7U28	TRANSDUCER - TRAQ PRESSURE	285
7U29	TRANSDUCER - TRAQ PRESSURE	288
8L6	SOLENOID - R/A PLENUM PRESS CALIB	277
8L7	SOLENOID - SPACE PRESS CAL	252
8RT12	SENSOR - RETURN AIR TEMP	248
8U17	V.F.D. - RETURN FAN	260
8U26	ACTUATOR - EXHAUST DAMPER #2	256
8U31	SENSOR - R/A HUMIDITY	250
8U35	ACTUATOR - EXHAUST DAMPER #1	254
8U38	TRANSDUCER - R/A SPACE PRESSURE	248
8U50	TRANSDUCER - R/A PLENUM PRESSURE	273

A DIVISION OF AMERICAN STANDARD, INC. THIS DRAWING AND ITS CONTENTS SHALL BE FOR THE EXCLUSIVE USE OF THE CLIENT. PARTS WITHOUT THE CONSENT OF TRANE. DRAWN BY: K. RYAN REVISION DATE: 1-10-07 3-29-07 PRO/DIAGRAM SIMILAR TO:	TRANE FILE NUMBER: DRAWING NUMBER: 2309-3646 SHEET: 1 OF 1 REV: B
	ROOF-TOP PACKAGED AIR CONDITIONER DIAGRAM CONTROL SCHEMATIC - LHI, ECEM, MPM, VCM W/ RETURN FAN VARIABLE FREQUENCY DRIVE (V.F.D.) SHEET 5 OF 7