


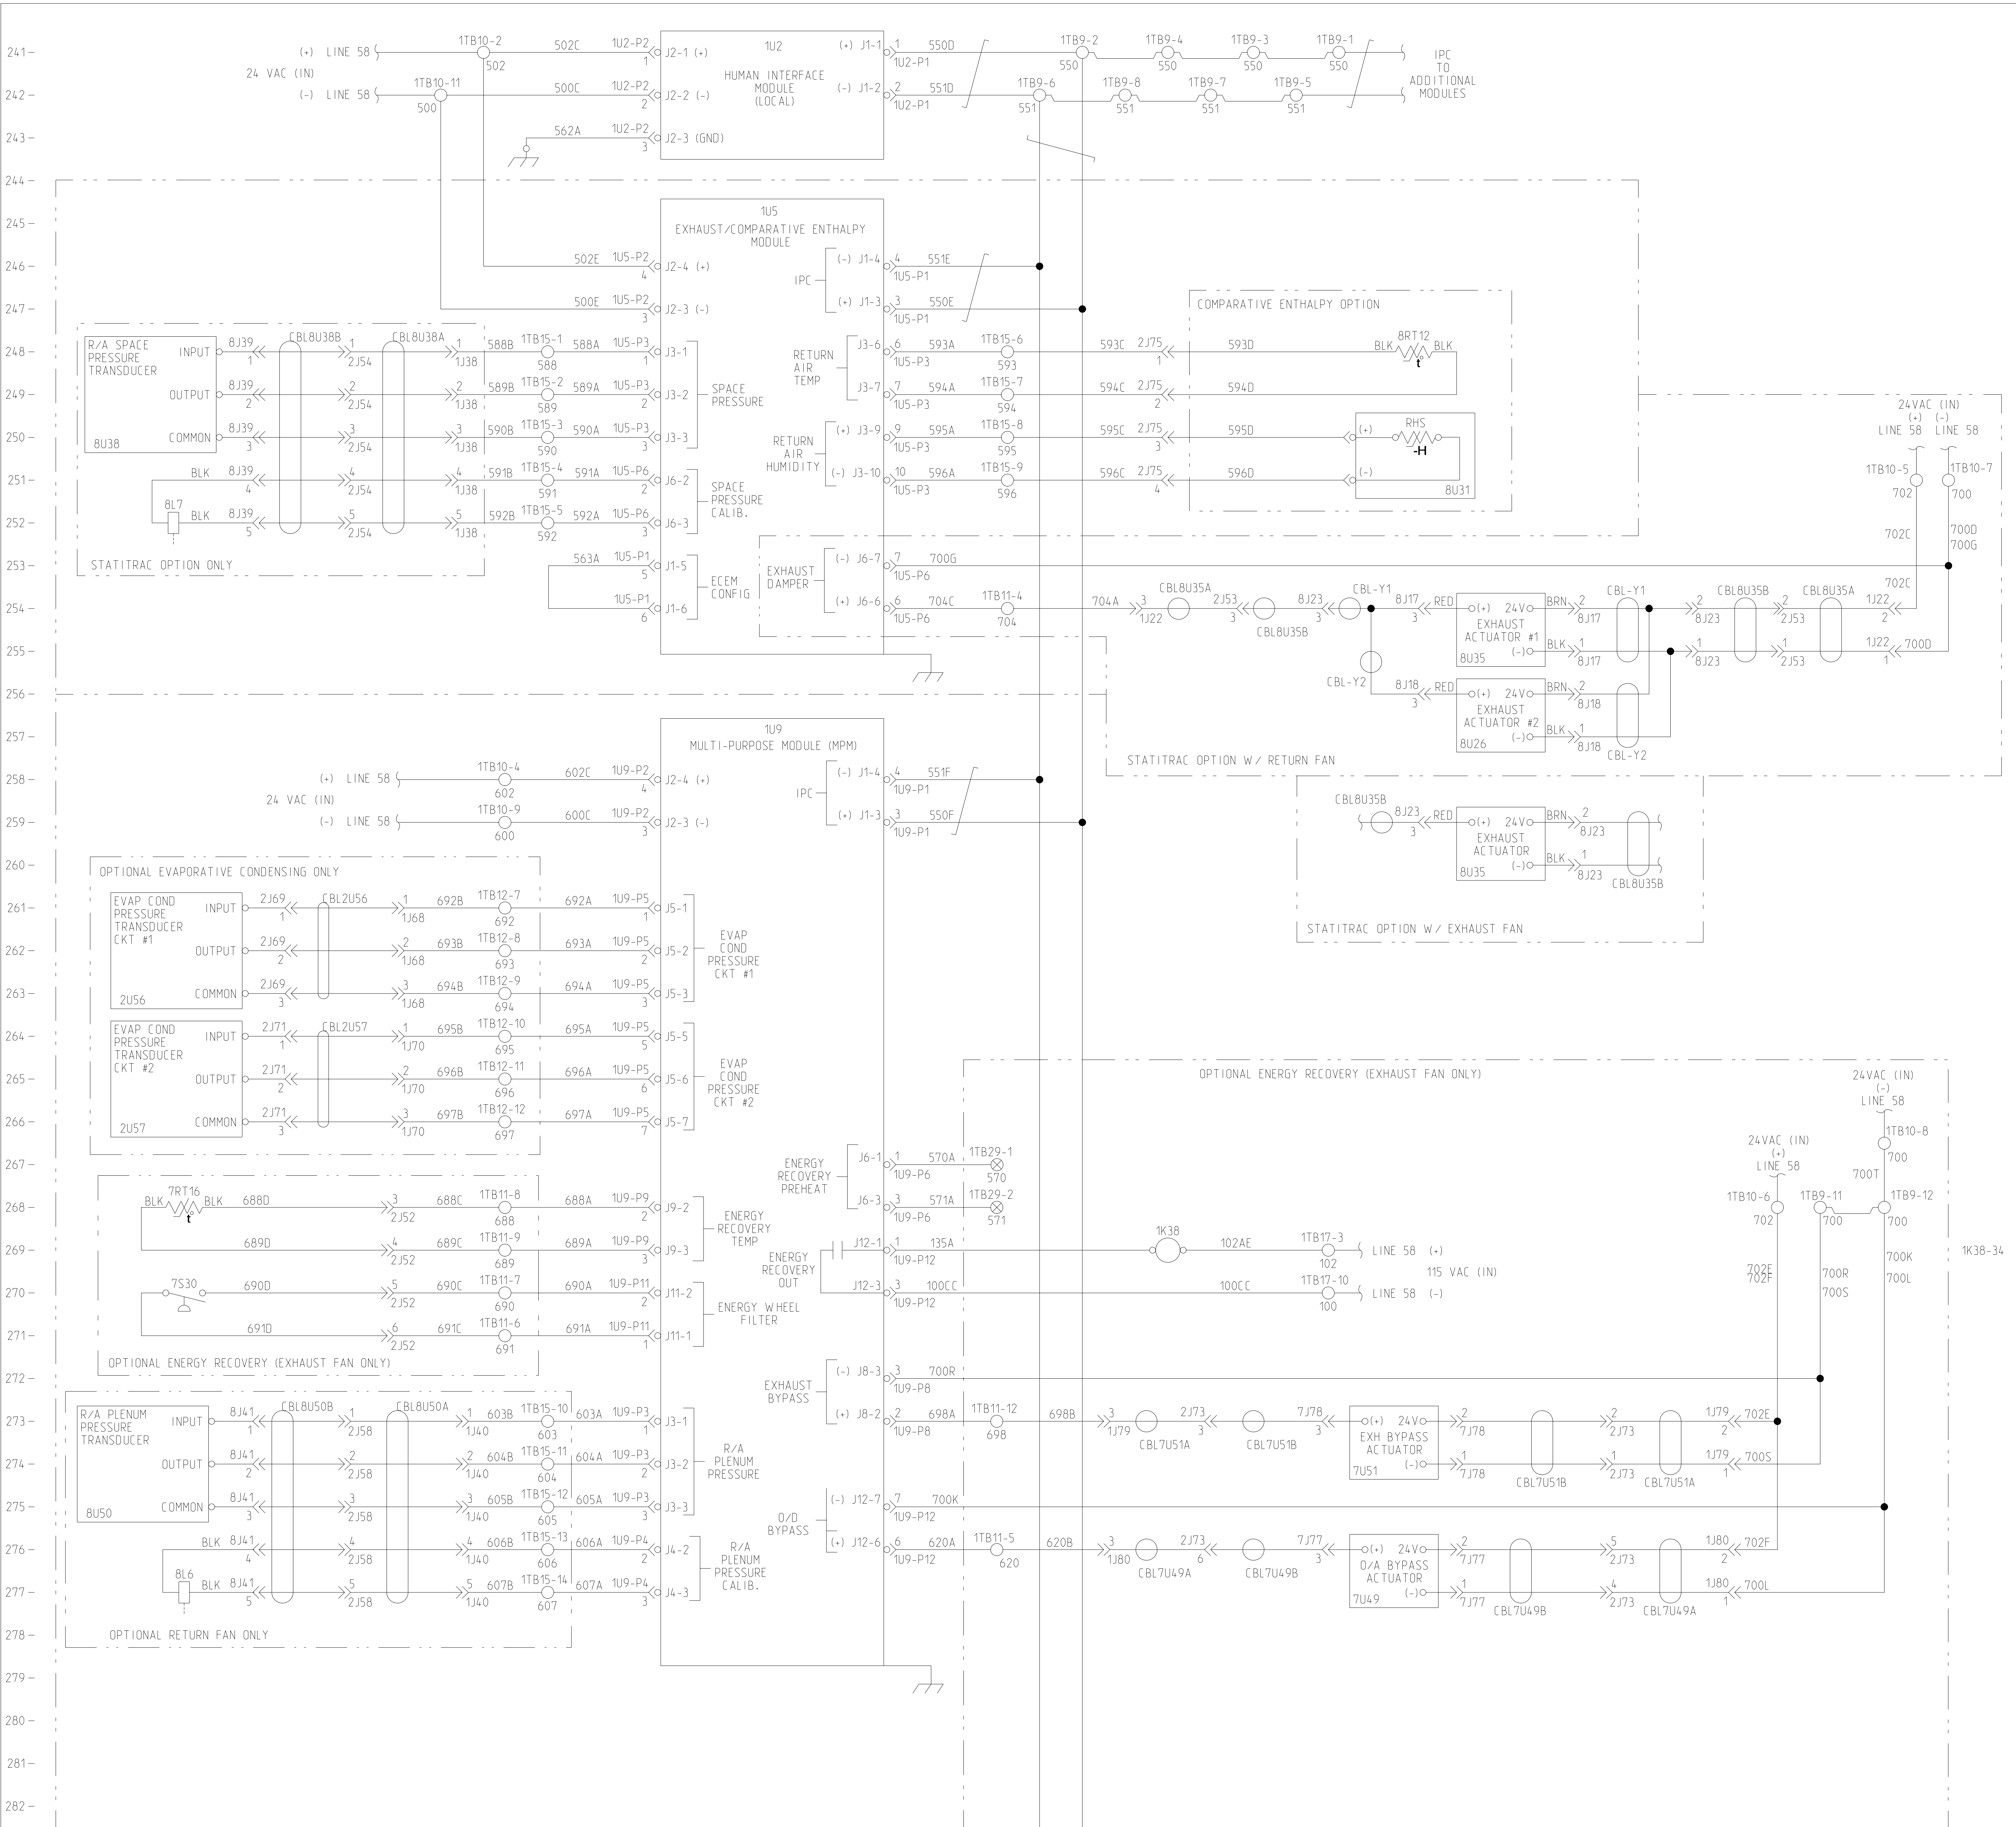

REF	DES	DESCRIPTION	LINE NO.
1K38	CONTACTOR	- ENERGY RECOVERY	269

DEVICE DESIG	DESCRIPTION	LINE NUMBER
1U2	MODULE - LHI	241
1U5	MODULE - ECEM	246
1U9	MODULE - MPM	260
2U56	TRANSDUCER - EVAP COND. PRESS	261
2U57	TRANSDUCER - EVAP COND. PRESS	264
7L14	SOLENOID - TRAQ PRESS. CAL	284
7L9	SOLENOID - TRAQ PRESS. CAL	286
7RT16	SENSOR - ENERGY WHEEL TEMP	268
7S30	SWITCH - CLOGGED FILTER	270
7U14	MODULE - VCM	285
7U28	TRANSDUCER - TRAQ PRESSURE	288
7U29	TRANSDUCER - TRAQ PRESSURE	291
7U49	ACTUATOR - EXHAUST BYPASS	276
7U51	ACTUATOR - O/A BYPASS	273
8L6	SOLENOID - R/A PLENUM PRESS CALIB	277
8L7	SOLENOID - SPACE PRESS CAL	252
8RT12	SENSOR - RETURN AIR TEMP	248
8U26	ACTUATOR - EXHAUST DAMPER #2	256
8U31	SENSOR - R/A HUMIDITY	250
8U35	ACTUATOR - EXHAUST DAMPER #1	254,259
8U38	TRANSDUCER - R/A SPACE PRESSURE	248
8U50	TRANSDUCER - R/A PLENUM PRESSURE	273

CAUTION
USE COPPER CONDUCTORS ONLY!

UNIT TERMINALS ARE NOT DESIGNED TO ACCEPT OTHER TYPES OF CONDUCTORS.

FAILURE TO DO SO MAY CAUSE DAMAGE TO THE EQUIPMENT.

PRECAUCIÓN
N'UTILISER QUE DES CONDUCTEURS EN CUIVRE!

LES BORNES DE L'UNITÉ NE SONT PAS CONÇUES POUR RECEVOIR D'AUTRES TYPES DE CONDUCTEURS.

L'UTILISATION DE TOUT AUTRE CONDUCTEUR PEUT ENDOMMAGER L'ÉQUIPEMENT.

ATTENTION
¡UTILICE ÚNICAMENTE CONDUCTORES DE COBRE!

LAS TERMINALES DE LA UNIDAD NO ESTÁN DISEÑADAS PARA ACEPTAR OTROS TIPOS DE CONDUCTORES.

SI NO LO HACE, PUEDE OCASIONAR DAÑO AL EQUIPO.

OPTIONAL VENTILATION CONTROL

CONTACTOR COIL LOCATIONS

REF	DES	DESCRIPTION	LINE NO.
1K38	CONTACTOR	- ENERGY RECOVERY	269

LEGEND

DEVICE DESIG	DESCRIPTION	LINE NUMBER
1U2	MODULE - LHI	241
1U5	MODULE - ECEM	246
1U9	MODULE - MPM	260
2U56	TRANSDUCER - EVAP COND. PRESS	261
2U57	TRANSDUCER - EVAP COND. PRESS	264
7L14	SOLENOID - TRAQ PRESS. CAL	284
7L9	SOLENOID - TRAQ PRESS. CAL	286
7RT16	SENSOR - ENERGY WHEEL TEMP	268
7S30	SWITCH - CLOGGED FILTER	270
7U14	MODULE - VCM	285
7U28	TRANSDUCER - TRAQ PRESSURE	288
7U29	TRANSDUCER - TRAQ PRESSURE	291
7U49	ACTUATOR - EXHAUST BYPASS	276
7U51	ACTUATOR - O/A BYPASS	273
8L6	SOLENOID - R/A PLENUM PRESS CALIB	277
8L7	SOLENOID - SPACE PRESS CAL	252
8RT12	SENSOR - RETURN AIR TEMP	248
8U26	ACTUATOR - EXHAUST DAMPER #2	256
8U31	SENSOR - R/A HUMIDITY	250
8U35	ACTUATOR - EXHAUST DAMPER #1	254,259
8U38	TRANSDUCER - R/A SPACE PRESSURE	248
8U50	TRANSDUCER - R/A PLENUM PRESSURE	273

OPTIONAL VENTILATION CONTROL

FILE NUMBER: 2309-3648

DRAWING NUMBER: 2309-3648

SHEET: 1 OF 1

REV: D

TRAQ

A DIVISION OF AMERICAN STANDARD, INC.

THIS DRAWING AND ITS CONTENTS SHALL BE THE PROPERTY OF AMERICAN STANDARD, INC. AND SHALL NOT BE REPRODUCED OR USED IN ANY MANNER WITHOUT THE WRITTEN CONSENT OF AMERICAN STANDARD, INC.

DRAWN BY: K. RYAN

DATE: 2-9-07

REVISION DATE: 5-25-07

REVISIONS: 1

FOR SYSTEM USED: PRO/DIAGRAM

SIMILAR TO:

CONTROL SCHEMATIC - LHI, ECEM, MPM, VCM, ZPC

W/O EXHAUST OR RETURN V.F.D.

SHEET 5 OF 7