


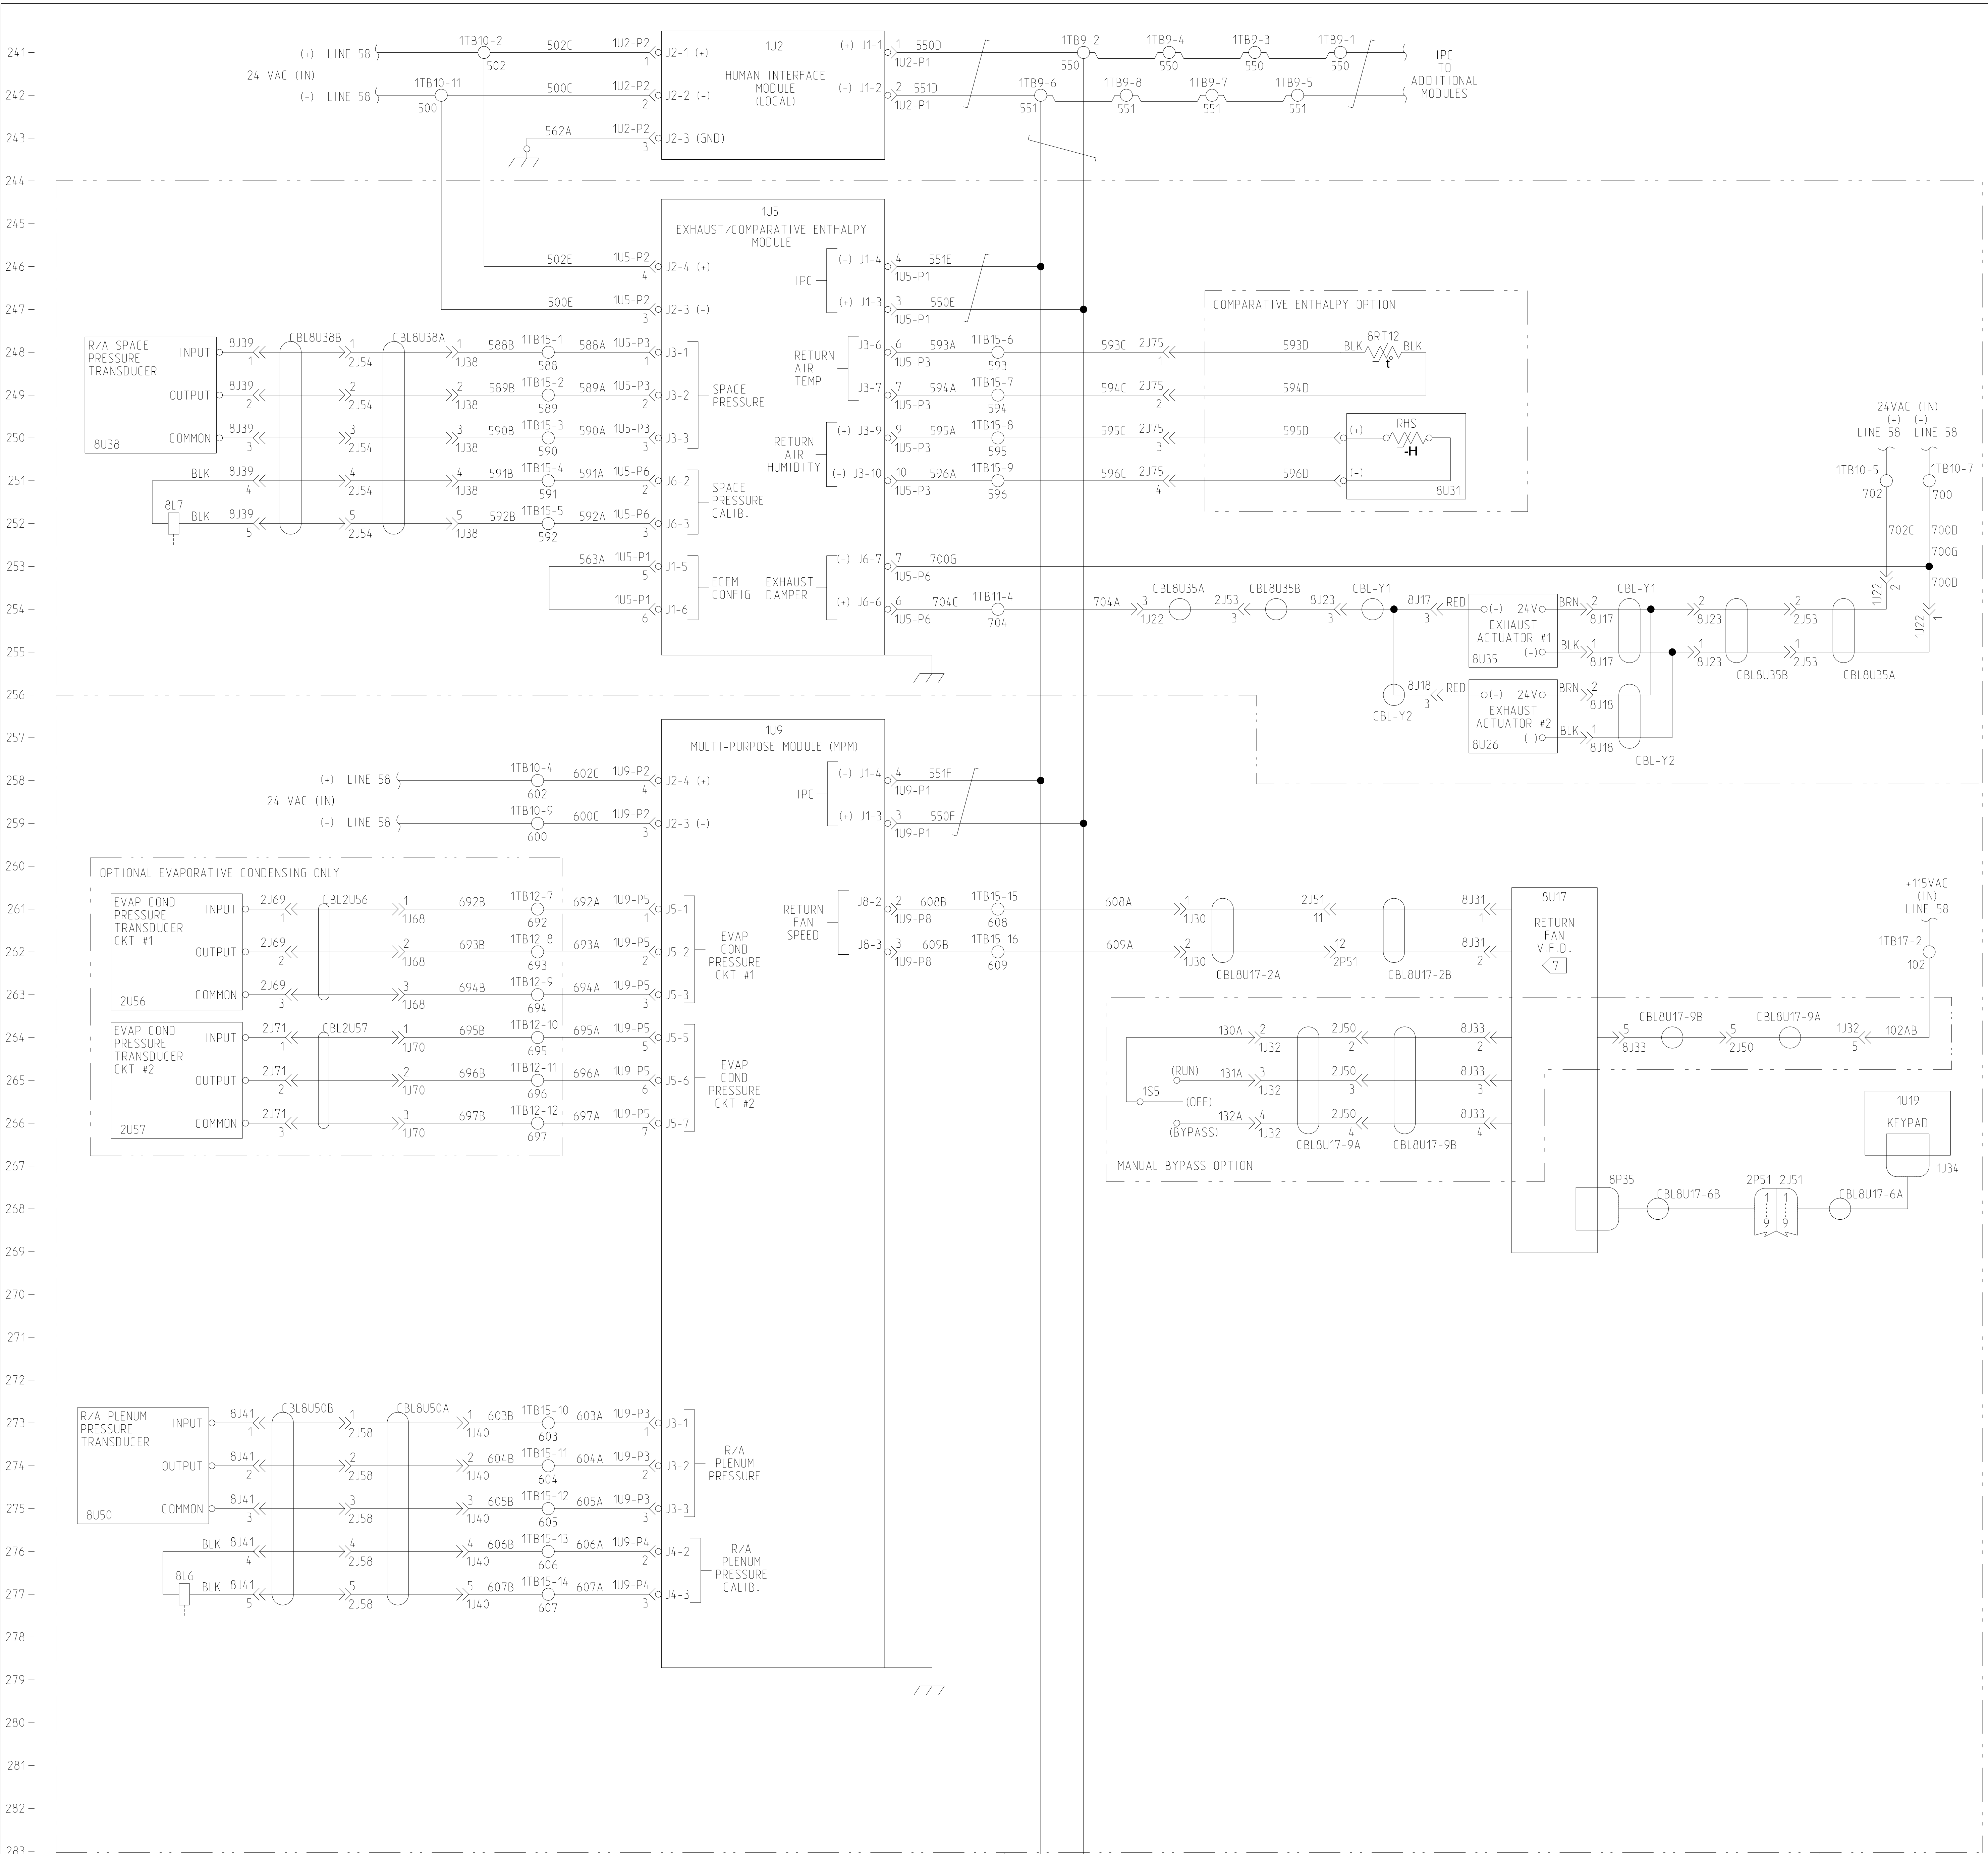

LEGEND		
DEVICE DESIG	DESCRIPTION	LINE NUMBER
1S5	SWITCH - EXH/RTN V.F.D. BYPASS	265
1U19	KEYPAD - EXH/RTN V.F.D.	267
1U2	MODULE - LHI	241
1U5	MODULE - ECEM	246
1U9	MODULE - MPM	260
2U56	TRANSDUCER - EVAP COND PRESS	261
2U57	TRANSDUCER - EVAP COND PRESS	264
7L14	SOLENOID - TRAQ PRESS CAL	284
7L9	SOLENOID - TRAQ PRESS CAL	286
7U14	MODULE - VCM	285
7U28	TRANSDUCER - TRAQ PRESSURE	288
7U29	TRANSDUCER - TRAQ PRESSURE	291
8L6	SOLENOID - R/A PLENUM PRESS CALIB	277
8L7	SOLENOID - SPACE PRESS CAL	252
8RT12	SENSOR - RETURN AIR TEMP	248
8U17	V.F.D. - RETURN FAN	261
8U26	ACTUATOR - EXHAUST DAMPER #2	256
8U31	SENSOR - R/A HUMIDITY	250
8U35	ACTUATOR - EXHAUST DAMPER #1	254
8U38	TRANSDUCER - R/A SPACE PRESSURE	248
8U50	TRANSDUCER - R/A PLENUM PRESSURE	273

CAUTION

USE COPPER CONDUCTORS ONLY!

UNIT TERMINALS ARE NOT DESIGNED TO ACCEPT OTHER TYPES OF CONDUCTORS.

FAILURE TO DO SO MAY CAUSE DAMAGE TO THE EQUIPMENT.

PRECAUCIÓN

N'UTILISER QUE DES CONDUCTEURS EN CUIVRE!

LES BORNES DE L'UNITÉ NE SONT PAS CONÇUES POUR RECEVOIR D'AUTRES TYPES DE CONDUCTEURS.

L'UTILISATION DE TOUT AUTRE CONDUCTEUR PEUT ENDOMMAGER L'ÉQUIPEMENT.

ATTENTION

¡UTILICE ÚNICAMENTE CONDUCTORES DE COBRE!

LAS TERMINALES DE LA UNIDAD NO ESTÁN DISEÑADAS PARA ACEPTAR OTROS TIPOS DE CONDUCTORES.

SI NO LO HACE, PUEDE OCASIONAR DAÑO AL EQUIPO.

OPTIONAL VENTILATION CONTROL

FILE NUMBER: 2309-3649

DRAWING NUMBER: 1 OF 1

REV: C

TRAFFIC

A DIVISION OF AMERICAN STANDARD, INC.

THIS DRAWING AND ITS CONTENTS SHALL BE LOANED OR ITS CONTENTS DISCLOSED TO OUTSIDE PARTIES WITHOUT THE CONSENT OF TRAFFIC.

DRAWN BY: K. RYAN

DATE: 1-30-07

REVISION DATE: 5-25-07

FOR SYSTEM USED: PRO/DIAGRAM

SIMILAR TO:

CONTROL SCHEMATIC - LHI, ECEM, MPM, VCM, ZPC

W/ RETURN FAN VARIABLE FREQUENCY DRIVE (V.F.D.)

SHEET 5 OF 7

NAME: LK004, OBJECT: 1209, 3449, DATE: 15-May-07, 08:42:06