


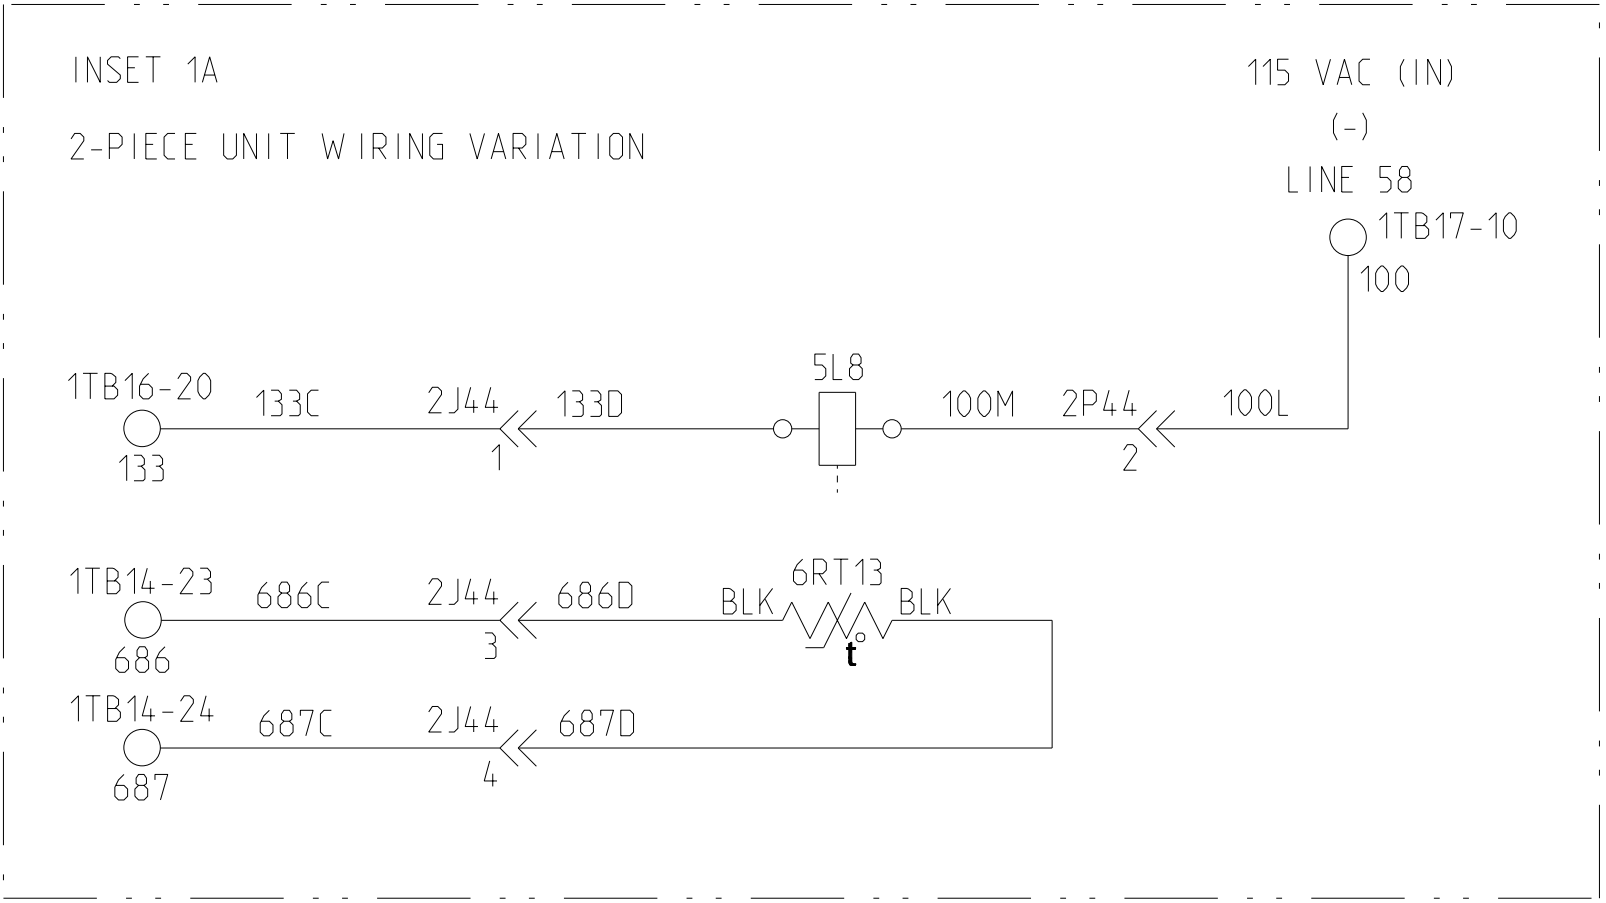

CAUTION

USE COPPER CONDUCTORS ONLY!

UNIT TERMINALS ARE NOT DESIGNED TO ACCEPT OTHER TYPES OF CONDUCTORS.

FAILURE TO DO SO MAY CAUSE DAMAGE TO THE EQUIPMENT.

ATTENTION

N'UTILISER QUE DES CONDUCTEURS EN CUIVRE!

LES BORNES DE L'UNITÉ NE SONT PAS CONÇUES POUR RECEVOIR D'AUTRES TYPES DE CONDUCTEURS.

L'UTILISATION DE TOUT AUTRE CONDUCTEUR PEUT ENDOMMAGER L'EQUIPEMENT.

PRECAUCIÓN

¡UTILICE ÚNICAMENTE CONDUCTORES DE COBRE!

LAS TERMINALES DE LA UNIDAD NO ESTÁN DISEÑADAS PARA ACEPTAR OTROS TIPOS DE CONDUCTORES.

SI NO LO HACE, PUEDE OCASIONAR DAÑO AL EQUIPO.

TITANE A DIVISION OF AMERICAN STANDARD, INC. THIS DRAWING IS THE PROPERTY OF AMERICAN STANDARD, INC. AND SHALL NOT BE LOANED, REPRODUCED, COPIED, OR IN ANY MANNER DISCLOSED TO OTHERS WITHOUT THE WRITTEN CONSENT OF TITANE.		FILE NUMBER: DRAWING NUMBER: 2309-3665		SHEET 1 OF 1 B	
ROOF-TOP PACKAGED AIR CONDITIONER DIAGRAM CONTROL SCHEMATIC - COOLING ONLY SHEET 4 OF 7					
DRAWN BY: K. RYAN @DATE: 12-14-06 REVISIONS: -- CAD SYSTEM USED: PRO/DIAGRAM		REVISION DATE: 2/16/07 SUBMIT TO: --			