


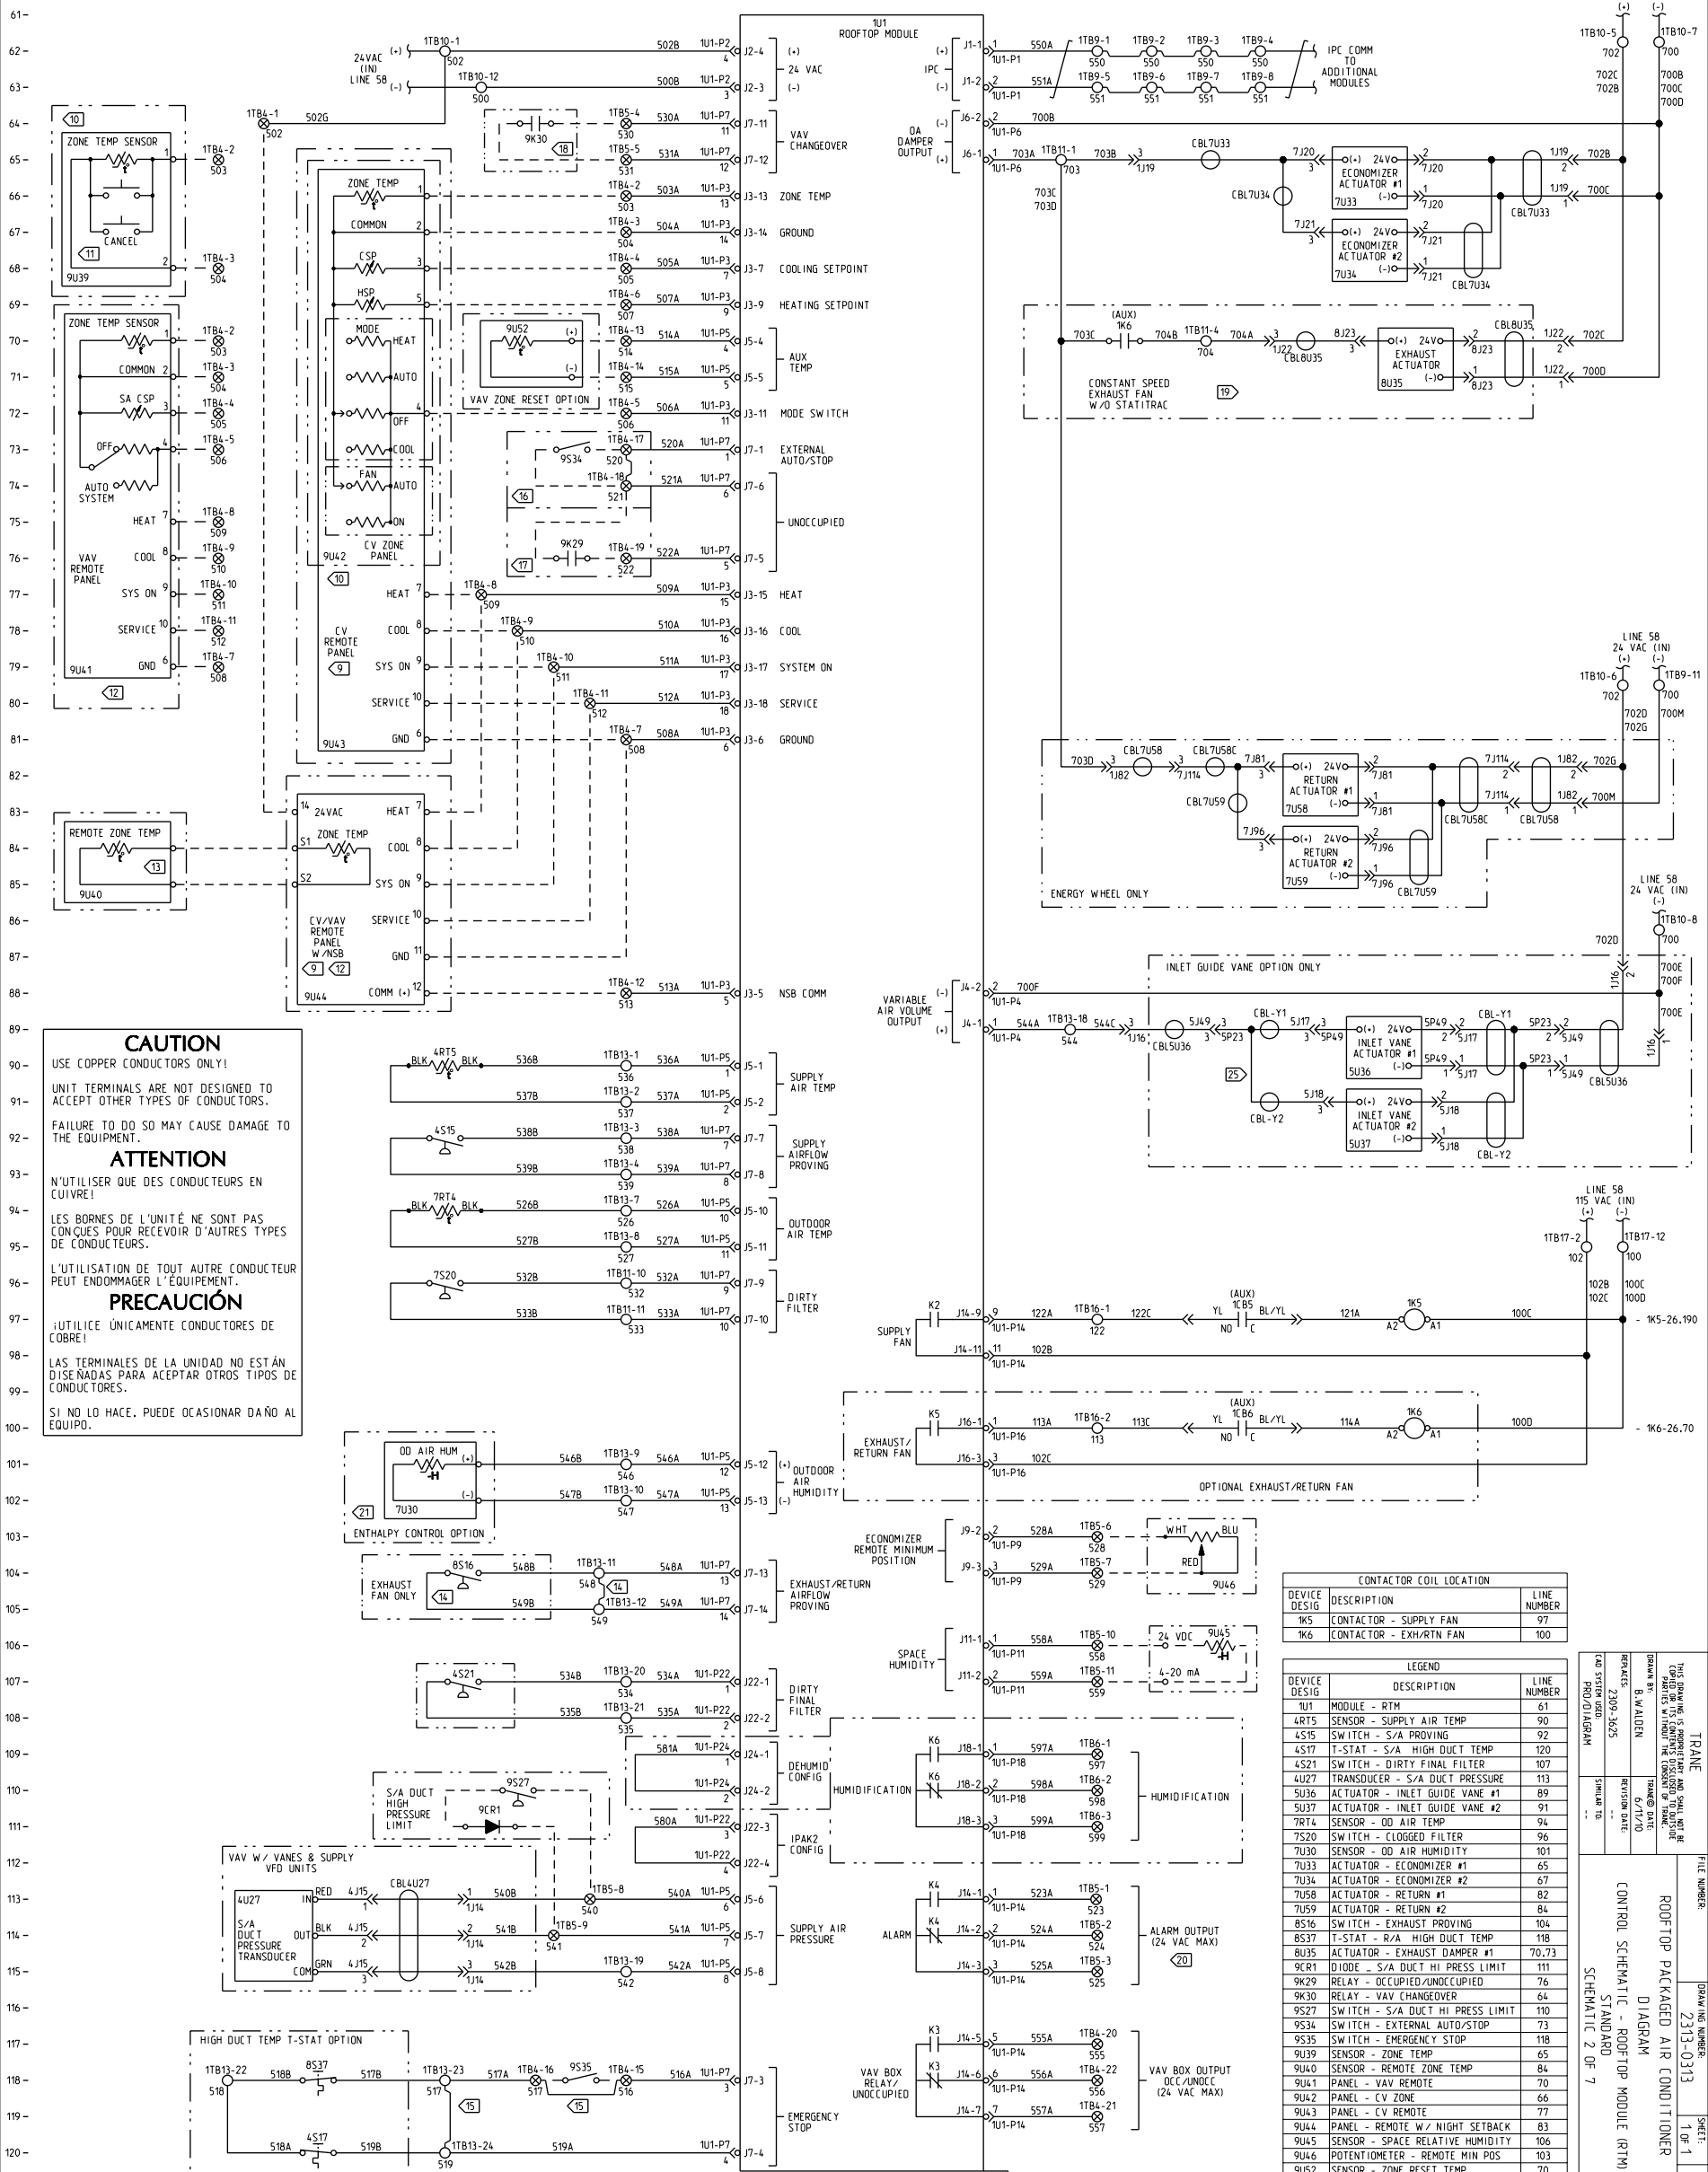

CAUTION
USE COPPER CONDUCTORS ONLY!
UNIT TERMINALS ARE NOT DESIGNED TO ACCEPT OTHER TYPES OF CONDUCTORS.
FAILURE TO DO SO MAY CAUSE DAMAGE TO THE EQUIPMENT.

ATTENTION
N'UTILISER QUE DES CONDUCTEURS EN CUIVRE!
LES BORNES DE L'UNITÉ NE SONT PAS CONÇUES POUR RECEVOIR D'AUTRES TYPES DE CONDUCTEURS.

PRECAUCIÓN
¡UTILICE ÚNICAMENTE CONDUCTORES DE COBRE!
LAS TERMINALES DE LA UNIDAD NO ESTÁN DISEÑADAS PARA ACEPTAR OTROS TIPOS DE CONDUCTORES.

SI NO LO HACE, PUEDE OCASIONAR DAÑO AL EQUIPO.

CONTACTOR COIL LOCATION		
DEVICE DESIG	DESCRIPTION	LINE NUMBER
1K5	CONTACTOR - SUPPLY FAN	97
1K6	CONTACTOR - EXH/RTN FAN	100

LEGEND		
DEVICE DESIG	DESCRIPTION	LINE NUMBER
1U1	MODULE - RTM	61
4RT5	SENSOR - SUPPLY AIR TEMP	90
4S15	SWITCH - S/A PROVING	92
4S17	T-STAT - S/A HIGH DUCT TEMP	120
4S21	SWITCH - DIRTY FINAL FILTER	107
4U27	TRANSDUCER - S/A DUCT PRESSURE	113
5U36	ACTUATOR - INLET GUIDE VANE #1	89
5U37	ACTUATOR - INLET GUIDE VANE #2	91
7RT4	SENSOR - OD AIR TEMP	94
7S20	SWITCH - CLOGGED FILTER	96
7U30	SENSOR - OD AIR HUMIDITY	101
7U33	ACTUATOR - ECONOMIZER #1	65
7U34	ACTUATOR - ECONOMIZER #2	67
7U58	ACTUATOR - RETURN #1	82
7U59	ACTUATOR - RETURN #2	84
8S16	SWITCH - EXHAUST PROVING	104
8S37	T-STAT - R/A HIGH DUCT TEMP	118
8U35	ACTUATOR - EXHAUST DAMPER #1	70.73
9CR1	DIODE - S/A DUCT HI PRESS LIMIT	111
9K29	RELAY - OCCUPIED/UNOCCUPIED	76
9K30	RELAY - VAV CHANGEOVER	64
9S27	SWITCH - S/A DUCT HI PRESS LIMIT	110
9S34	SWITCH - EXTERNAL AUTO/STOP	73
9S35	SWITCH - EMERGENCY STOP	118
9U39	SENSOR - ZONE TEMP	65
9U40	SENSOR - REMOTE ZONE TEMP	84
9U41	PANEL - VAV REMOTE	70
9U42	PANEL - CV ZONE	66
9U43	PANEL - CV REMOTE	77
9U44	PANEL - REMOTE W/ NIGHT SETBACK	83
9U45	SENSOR - SPACE RELATIVE HUMIDITY	106
9U46	POTENTIOMETER - REMOTE MIN POS	103
9U52	SENSOR - ZONE RESET TEMP	70

TRANF		FILE NUMBER	DRAWING NUMBER: 2313-0313	SHEET:	1 of 1 A
THIS DRAWING IS PROPERTY OF AND SHALL REMAIN THE PROPERTY OF THE COMPANY AND SHALL BE RETURNED TO THE COMPANY UPON REQUEST BY THE ARCHITECT.					
DRAWN BY: B. W. ALDEN		TRANF'D DATE: 6/17/70			
REVISED: 2/20/85		REVISION DATE: --			
AND STANDARD PROGRAM		SYMBOL TO:			
CONTROL SCHEMATIC - ROOFTOP MODULE (RTM)					
STANDARD					
SCHEMATIC 2 OF 7					