


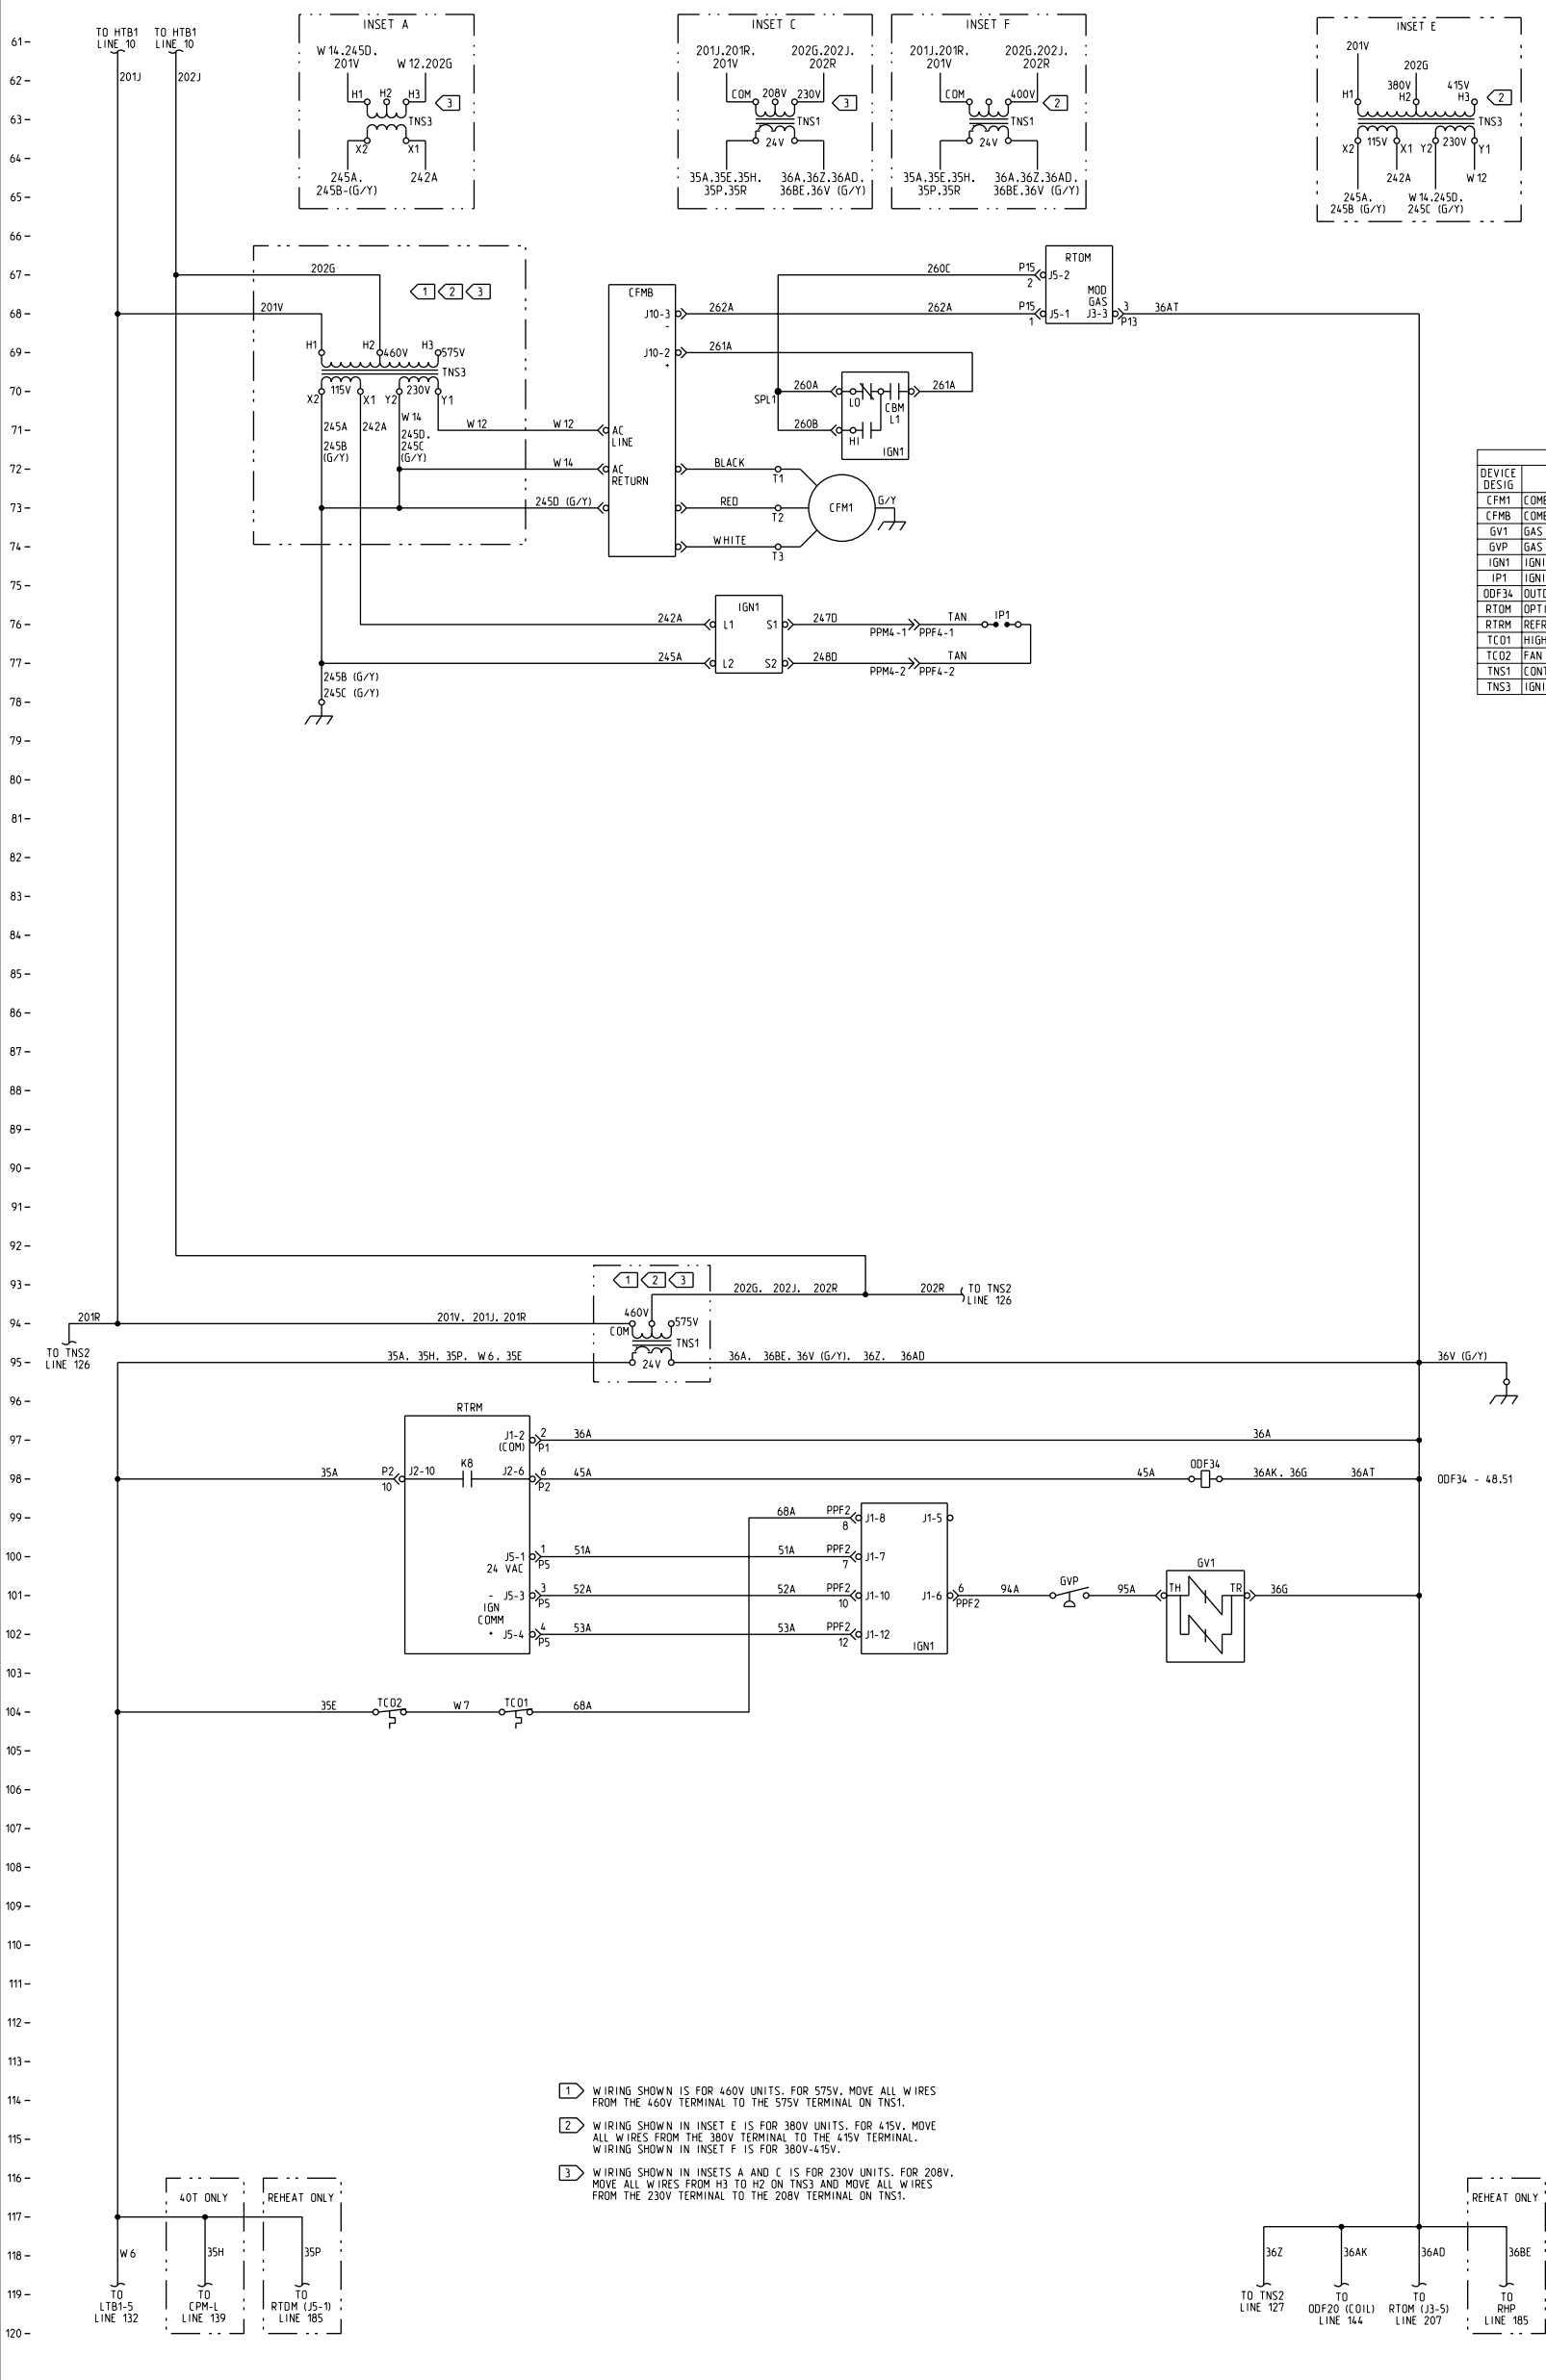

CAUTION
USE COPPER CONDUCTORS ONLY!
UNIT TERMINALS ARE NOT DESIGNED TO ACCEPT OTHER TYPES OF CONDUCTORS.
FAILURE TO DO SO MAY CAUSE DAMAGE TO THE EQUIPMENT.
ATTENTION
N'UTILISER QUE DES CONDUCTEURS EN CUIVRE!
LES BORNES DE L'UNITÉ NE SONT PAS CONÇUES POUR RECEVOIR D'AUTRES TYPES DE CONDUCTEURS.
L'UTILISATION DE TOUT AUTRE CONDUCTEUR PEUT ENDOMMAGER L'ÉQUIPEMENT.
PRECAUCIÓN
UTILICE ÚNICAMENTE CONDUCTORES DE COBRE!
LAS TERMINALES DE LA UNIDAD NO ESTÁN DISEÑADAS PARA ACEPTAR OTROS TIPOS DE CONDUCTORES.
SI NO LO HACE, PUEDE OCASIONAR DAÑO AL EQUIPO.

LEGEND		
DEVICE DESIG	DESCRIPTION	LINE NUMBER
CFM1	COMBUSTION FAN MOTOR	70,72
CFMB	COMBUSTION FAN MOTOR BOARD	71
GV1	GAS VALVE	101
GVP	GAS VALVE PRESSURE SWITCH	101
IGN1	IGNITION MODULE	70,76,99
IP1	IGNITION PROBE	76
ODF34	OUTDOOR FAN RELAY	98
RTOM	OPTIONS MODULE	68
RTRM	REFRIGERATION MODULE	98
TCO1	HIGH LIMIT CUTOFF #1	104
TCO2	FAN FAILURE LIMIT	104
TNS1	CONTROLS POWER TRANSFORMER	94
TNS3	IGNITION TRANSFORMER	69

- 1 WIRING SHOWN IS FOR 460V UNITS. FOR 575V, MOVE ALL WIRES FROM THE 460V TERMINAL TO THE 575V TERMINAL ON TNS1.
- 2 WIRING SHOWN IN INSET E IS FOR 380V UNITS. FOR 415V, MOVE ALL WIRES FROM THE 380V TERMINAL TO THE 415V TERMINAL. WIRING SHOWN IN INSET F IS FOR 380V-415V.
- 3 WIRING SHOWN IN INSETS A AND C IS FOR 230V UNITS. FOR 208V, MOVE ALL WIRES FROM H3 TO H2 ON TNS3 AND MOVE ALL WIRES FROM THE 230V TERMINAL TO THE 208V TERMINAL ON TNS1.

TRANE		FILE NUMBER	DRAWING NUMBER	SHEET	REV
2313-0602		2313-0605	VOYAGER 3	1 OF 1	A
HEAT POWER AND CONTROLS SCHEMATIC LOW HEAT MODULATING GAS					