


CAUTION
USE COPPER CONDUCTORS ONLY!
UNIT TERMINALS ARE NOT DESIGNED TO ACCEPT OTHER TYPES OF CONDUCTORS.
FAILURE TO DO SO MAY CAUSE DAMAGE TO THE EQUIPMENT.

ATTENTION
N'UTILISER QUE DES CONDUCTEURS EN CUIVRE!
LES BORNES DE L'UNITÉ NE SONT PAS CONÇUES POUR RECEVOIR D'AUTRES TYPES DE CONDUCTEURS.
L'UTILISATION DE TOUT AUTRE CONDUCTEUR PEUT ENDOMMAGER L'EQUIPEMENT.

PRECAUCIÓN
UTILICE ÚNICAMENTE CONDUCTORES DE COBRE!
LAS TERMINALES DE LA UNIDAD NO ESTÁN DISEÑADAS PARA ACEPTAR OTROS TIPOS DE CONDUCTORES.
SI NO LO HACE, PUEDE OCASIONAR DAÑO AL EQUIPO.

LEGEND		
DEVICE DESIGN	DESCRIPTION	LINE NUMBER
AH	CONTACTOR - ELECTRIC HEAT	68.69.70.101
BH	CONTACTOR - ELECTRIC HEAT	76.77.78.100.102
CH	CONTACTOR - ELECTRIC HEAT	84.85.86.103
FU11	FUSE - ELECTRIC HEAT	68
FU12	FUSE - ELECTRIC HEAT	69
FU13	FUSE - ELECTRIC HEAT	70
FU14	FUSE - ELECTRIC HEAT	76
FU15	FUSE - ELECTRIC HEAT	77
FU16	FUSE - ELECTRIC HEAT	78
FU17	FUSE - ELECTRIC HEAT	84
FU18	FUSE - ELECTRIC HEAT	85
FU19	FUSE - ELECTRIC HEAT	86
HLC1	HIGH LIMIT CUTOFF #1	98
HTRA	HEATER BANK A	68
HTRB	HEATER BANK B	71.76
HTRC	HEATER BANK C	76.79.84
ODF34	OUTDOOR FAN RELAY	98
RTRM	REFRIGERATION MODULE	98
TNS1	CONTROLS POWER TRANSFORMER	94

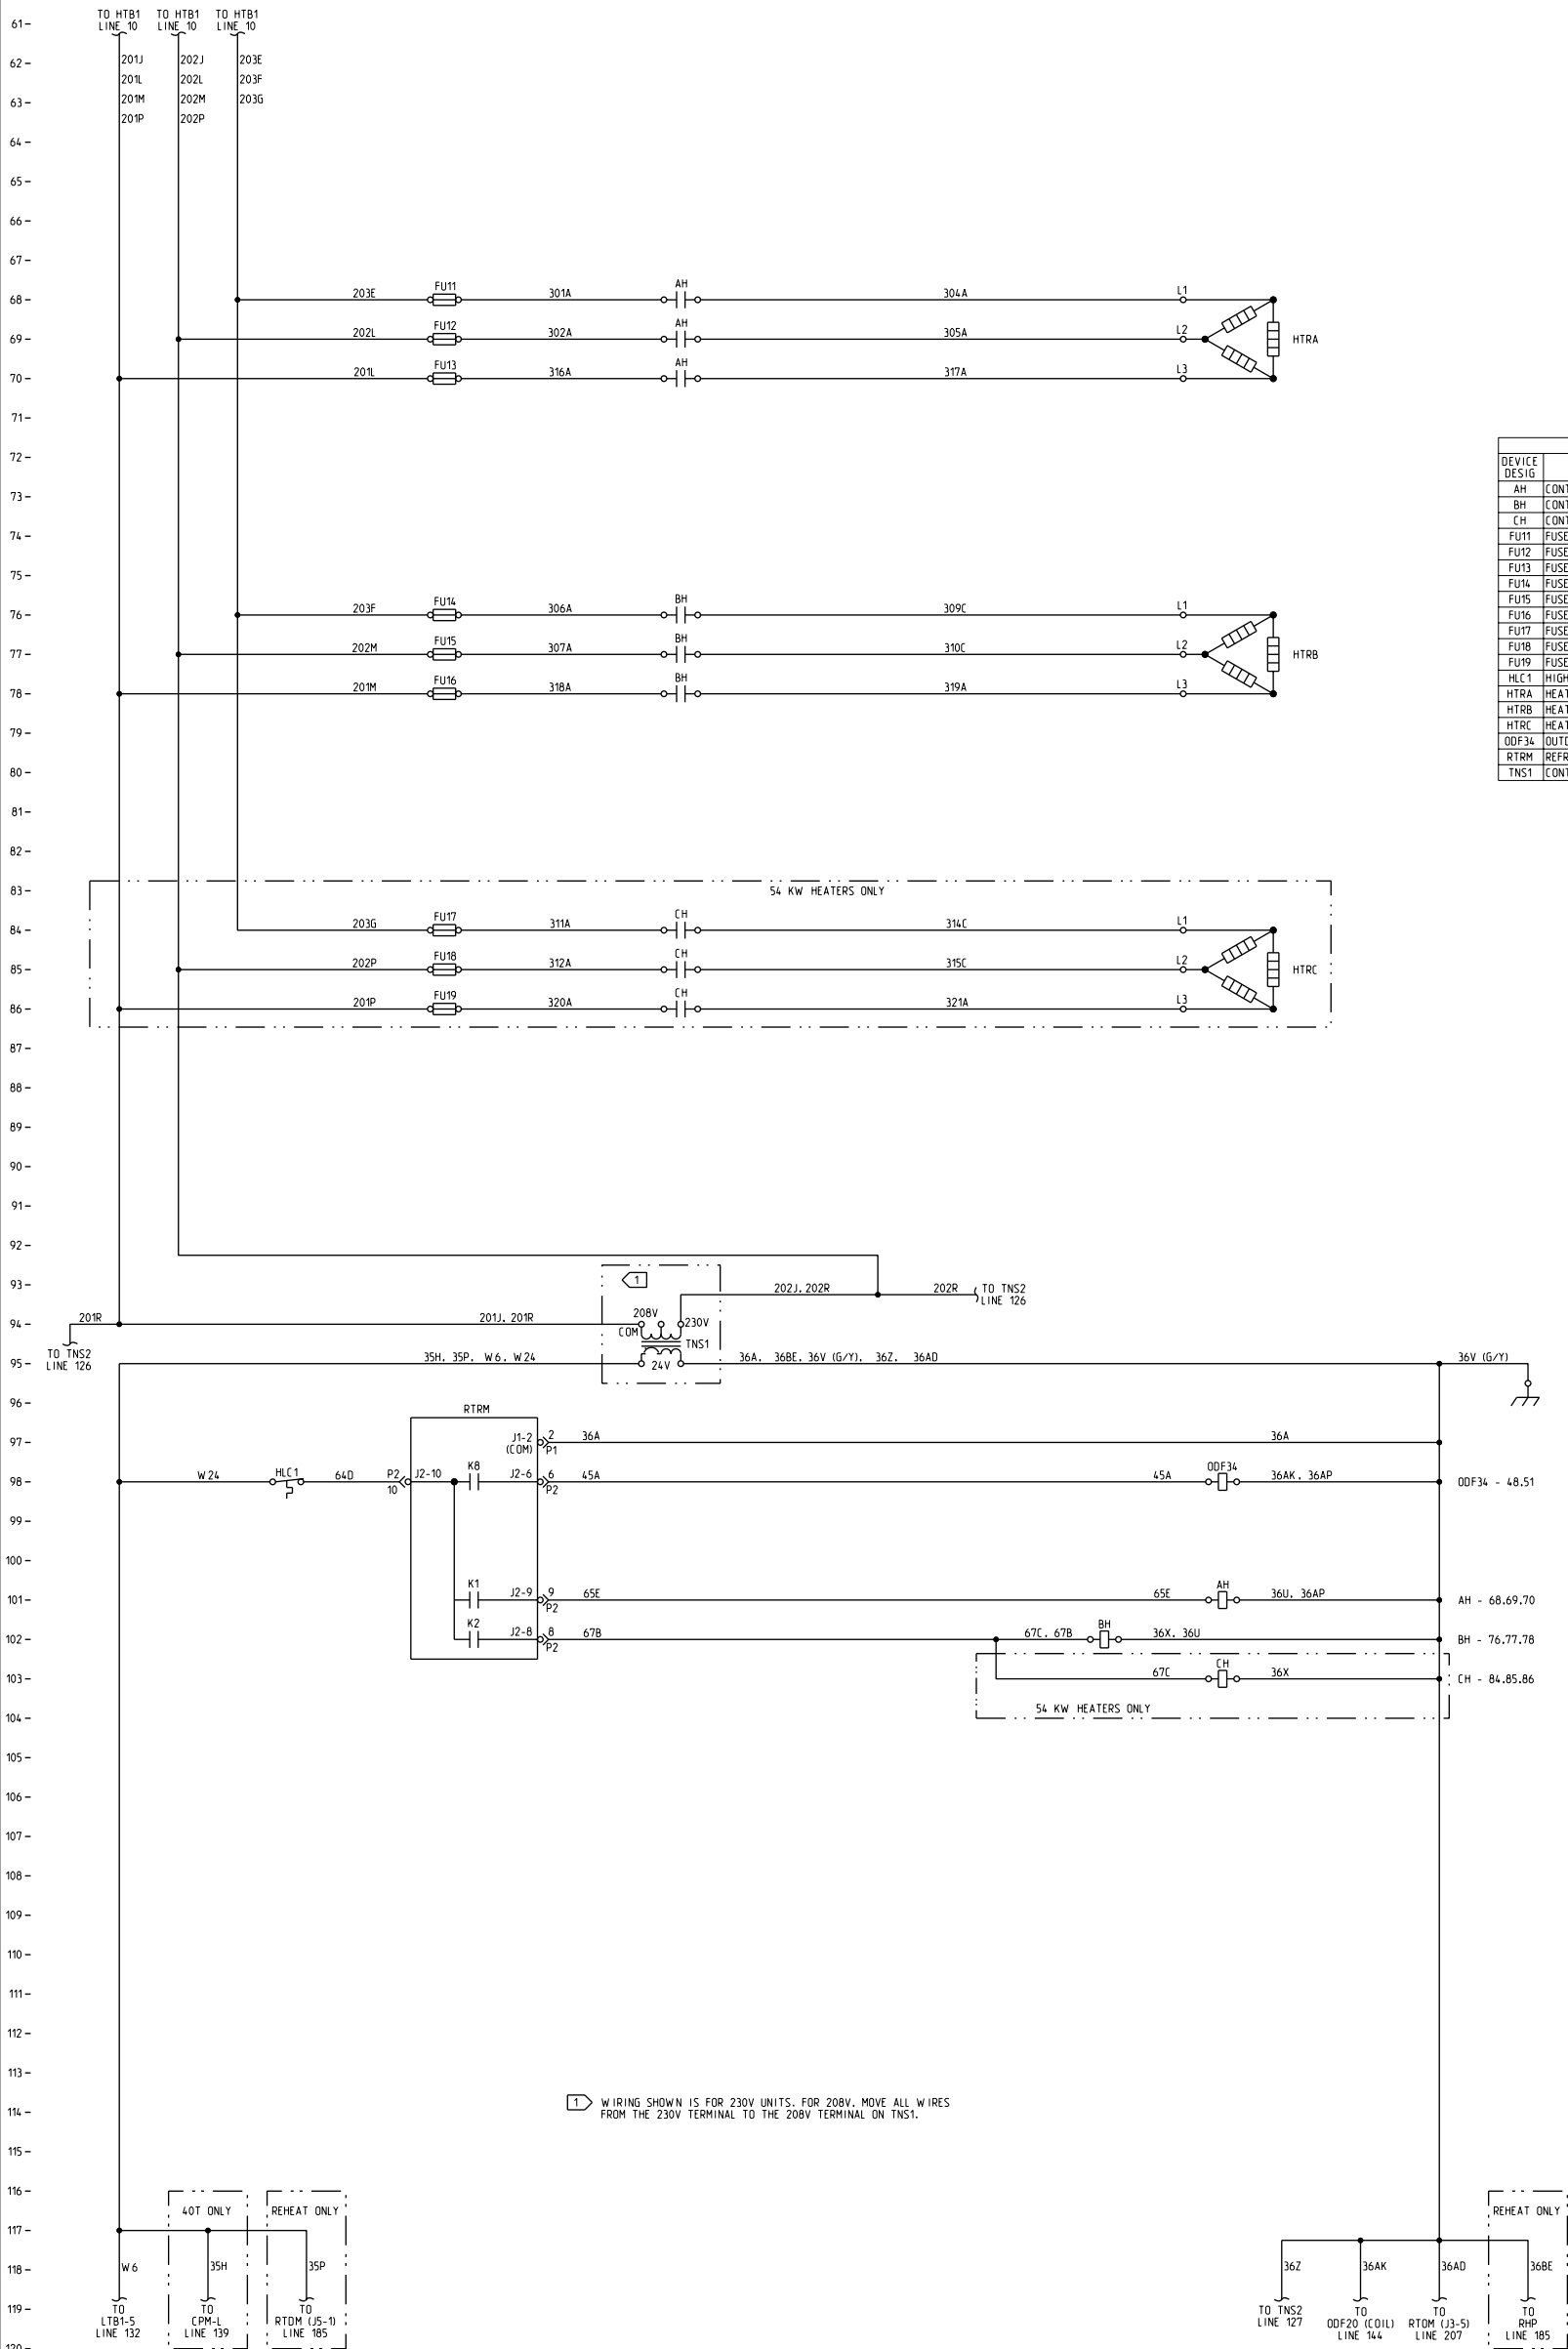

TRAN		FILE NUMBER	DRAWING NUMBER	SHEET	REV
2313-0602		2313-0607	1 OF 1	A	
THIS DRAWING IS APPROVED BY AND SHALL NOT BE USED WITHOUT THE SIGNATURE OF THE DESIGNER OR THE COMPANY OF TRAN.		HEAT POWER AND CONTROLS SCHEMATIC			
DRAWN BY: K. EDWARDS		36KW/54KW ELECTRIC HEAT			
REVISED: 2313-0103		208V-230V			
CAB SYSTEM DESIGN		HTRC/DIAGRAM			