


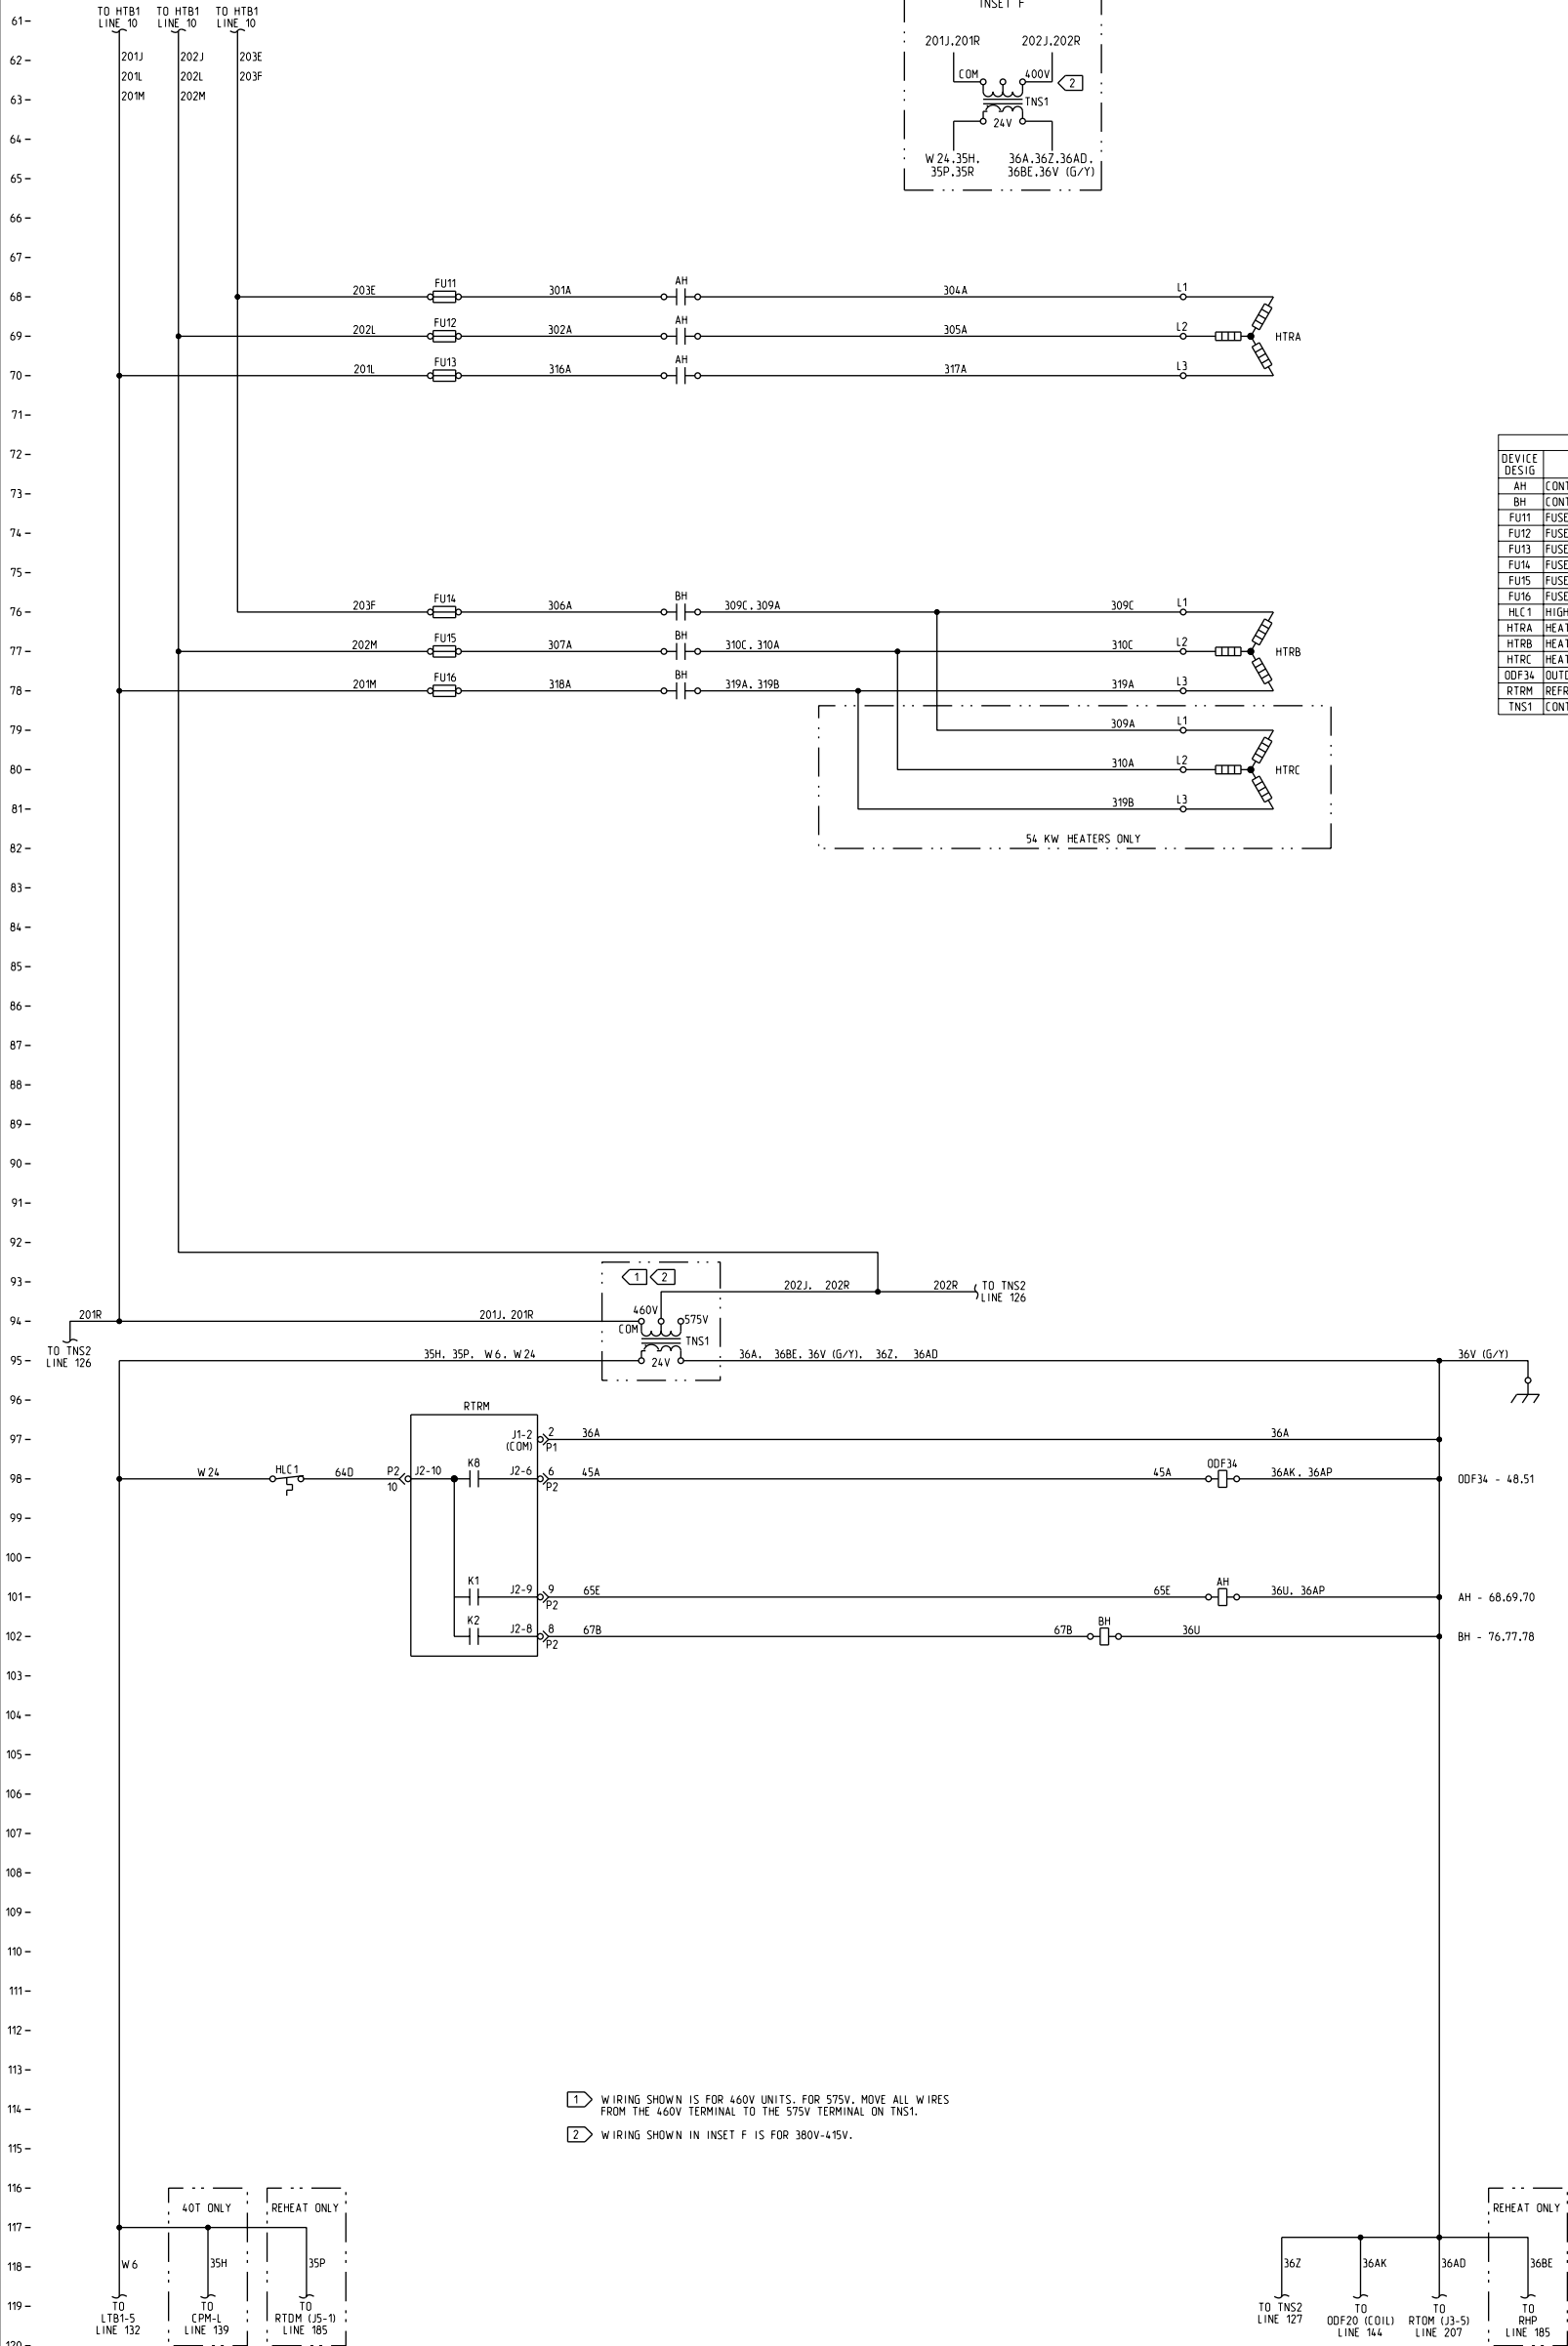

CAUTION

USE COPPER CONDUCTORS ONLY!

UNIT TERMINALS ARE NOT DESIGNED TO ACCEPT OTHER TYPES OF CONDUCTORS.

FAILURE TO DO SO MAY CAUSE DAMAGE TO THE EQUIPMENT.

ATTENTION

N'UTILISER QUE DES CONDUCTEURS EN CUIVRE!

LES BORNES DE L'UNITÉ NE SONT PAS CONÇUES POUR RECEVOIR D'AUTRES TYPES DE CONDUCTEURS.

L'UTILISATION DE TOUT AUTRE CONDUCTEUR PEUT ENDOMMAGER L'ÉQUIPEMENT.

PRECAUCIÓN

UTILICE ÚNICAMENTE CONDUCTORES DE COBRE!

LAS TERMINALES DE LA UNIDAD NO ESTÁN DISEÑADAS PARA ACEPTAR OTROS TIPOS DE CONDUCTORES.

SI NO LO HACE, PUEDE OCASIONAR DAÑO AL EQUIPO.

LEGEND		
DEVICE DESIG	DESCRIPTION	LINE NUMBER
AH	CONTACTOR - ELECTRIC HEAT	68,69,70,101
BH	CONTACTOR - ELECTRIC HEAT	76,77,78,100,102
FU11	FUSE - ELECTRIC HEAT	68
FU12	FUSE - ELECTRIC HEAT	69
FU13	FUSE - ELECTRIC HEAT	70
FU14	FUSE - ELECTRIC HEAT	76
FU15	FUSE - ELECTRIC HEAT	77
FU16	FUSE - ELECTRIC HEAT	78
HLC1	HIGH LIMIT CUTOUT #1	98
HTRA	HEATER BANK A	68
HTRB	HEATER BANK B	71,76
HTRC	HEATER BANK C	76,79,84
ODF34	OUTDOOR FAN RELAY	98
RTRM	REFRIGERATION MODULE	98
TNS1	CONTROLS POWER TRANSFORMER	94

TRANE		FILE NUMBER	DRAWING NUMBER	SHEET	REV
THIS DRAWING IS APPROXIMATE AND SHALL NOT BE USED FOR PARTS WITHOUT THE CONSENT OF TRANE.		2313-0602	2313-0608	1 OF 1	A
DRAWN BY: K. EDWARDS	TRANE DATE: 8/10/09	VOYAGER 3			
REPLACES: 2313-078A	REVISION DATE: --	HEAT POWER AND CONTROLS SCHEMATIC			
CAD SYSTEM USED: FRED O DIAGRAM	SYMBOL TO: --	36KW/54KW ELECTRIC HEAT			
		380V-575V			