


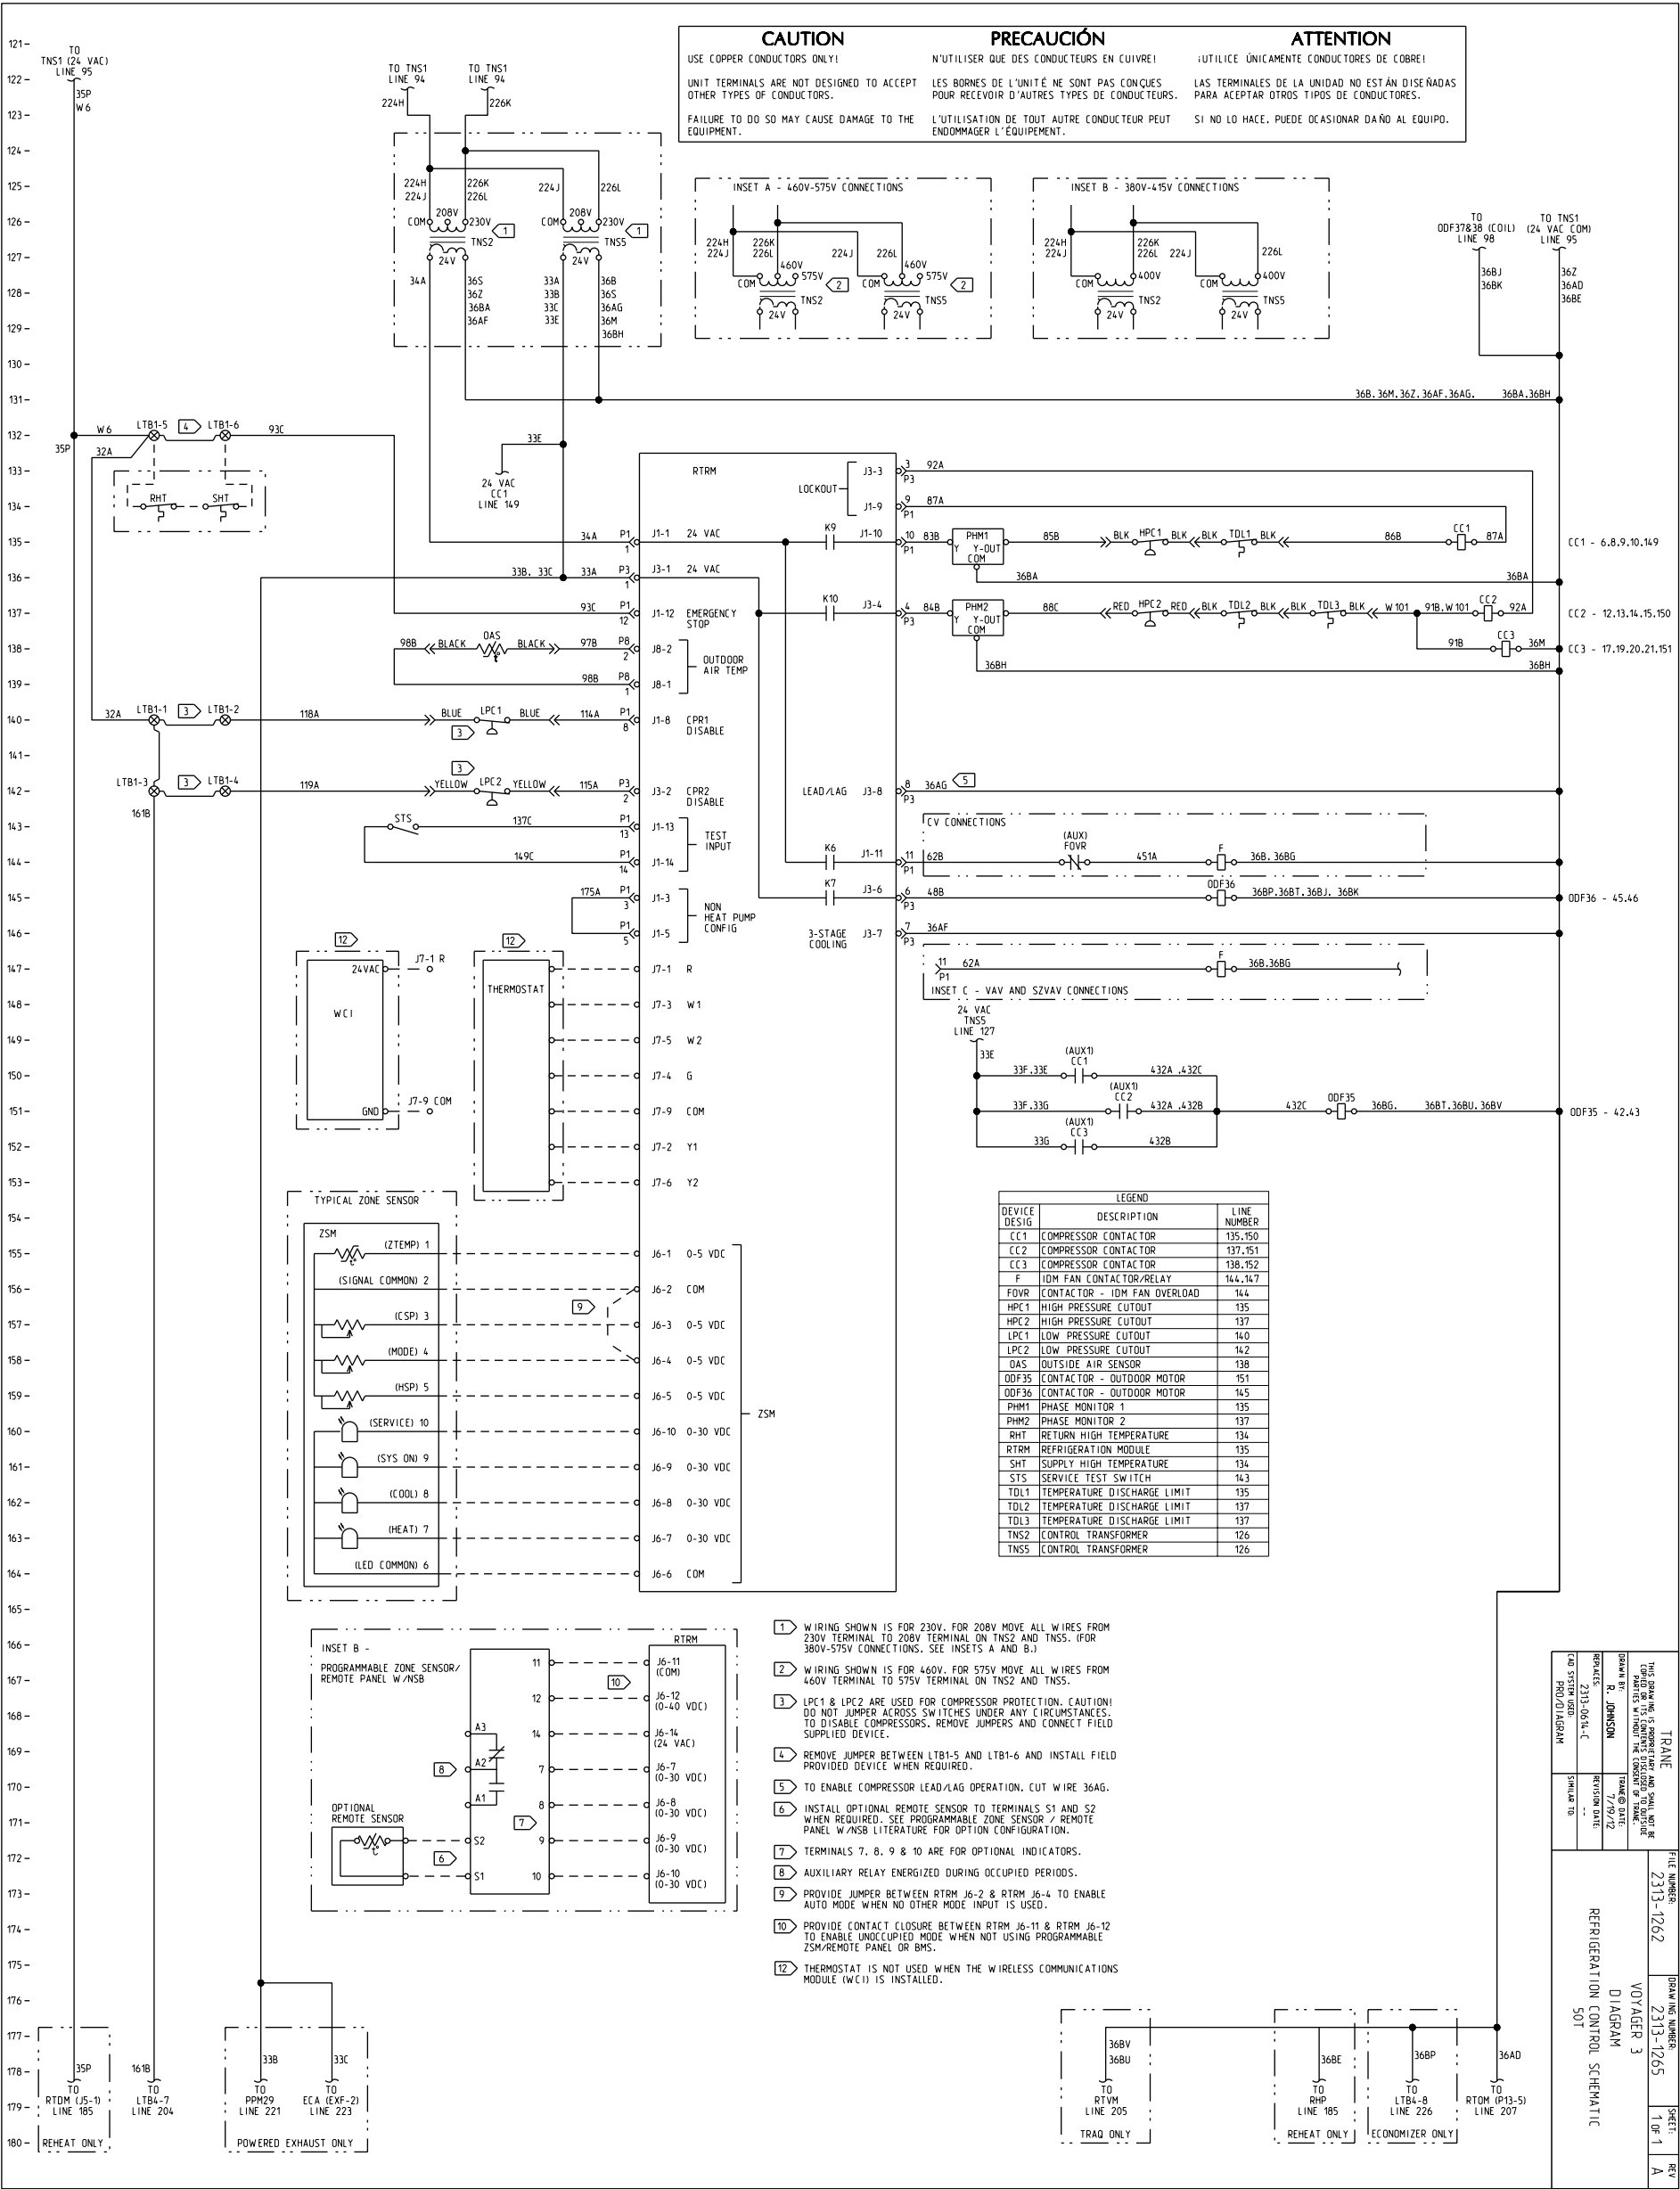

THIS DRAWING IS THE PROPERTY OF R. J. JOHNSON. IT IS TO BE USED FOR THE PROJECT AND NOT BE LOANED, REPRODUCED, COPIED, OR IN ANY MANNER DISCLOSED TO ANY OTHER PARTY WITHOUT THE WRITTEN CONSENT OF R. J. JOHNSON.	FILE NUMBER 2313-1262	DRAWING NUMBER 2313-1265	SHEET 1 OF 1	REV A
DRAWN BY R. JOHNSON	DATE 7/27/12	REVISION DATE 7/27/12	SCALE 1:1	
PROJ. NO. 2313-064-1	PROJ. NAME PROJ. DIAGRAM	PROJ. LOCATION SHELTER 10	PROJ. DESCRIPTION REFRIGERATION CONTROL SCHEMATIC	