


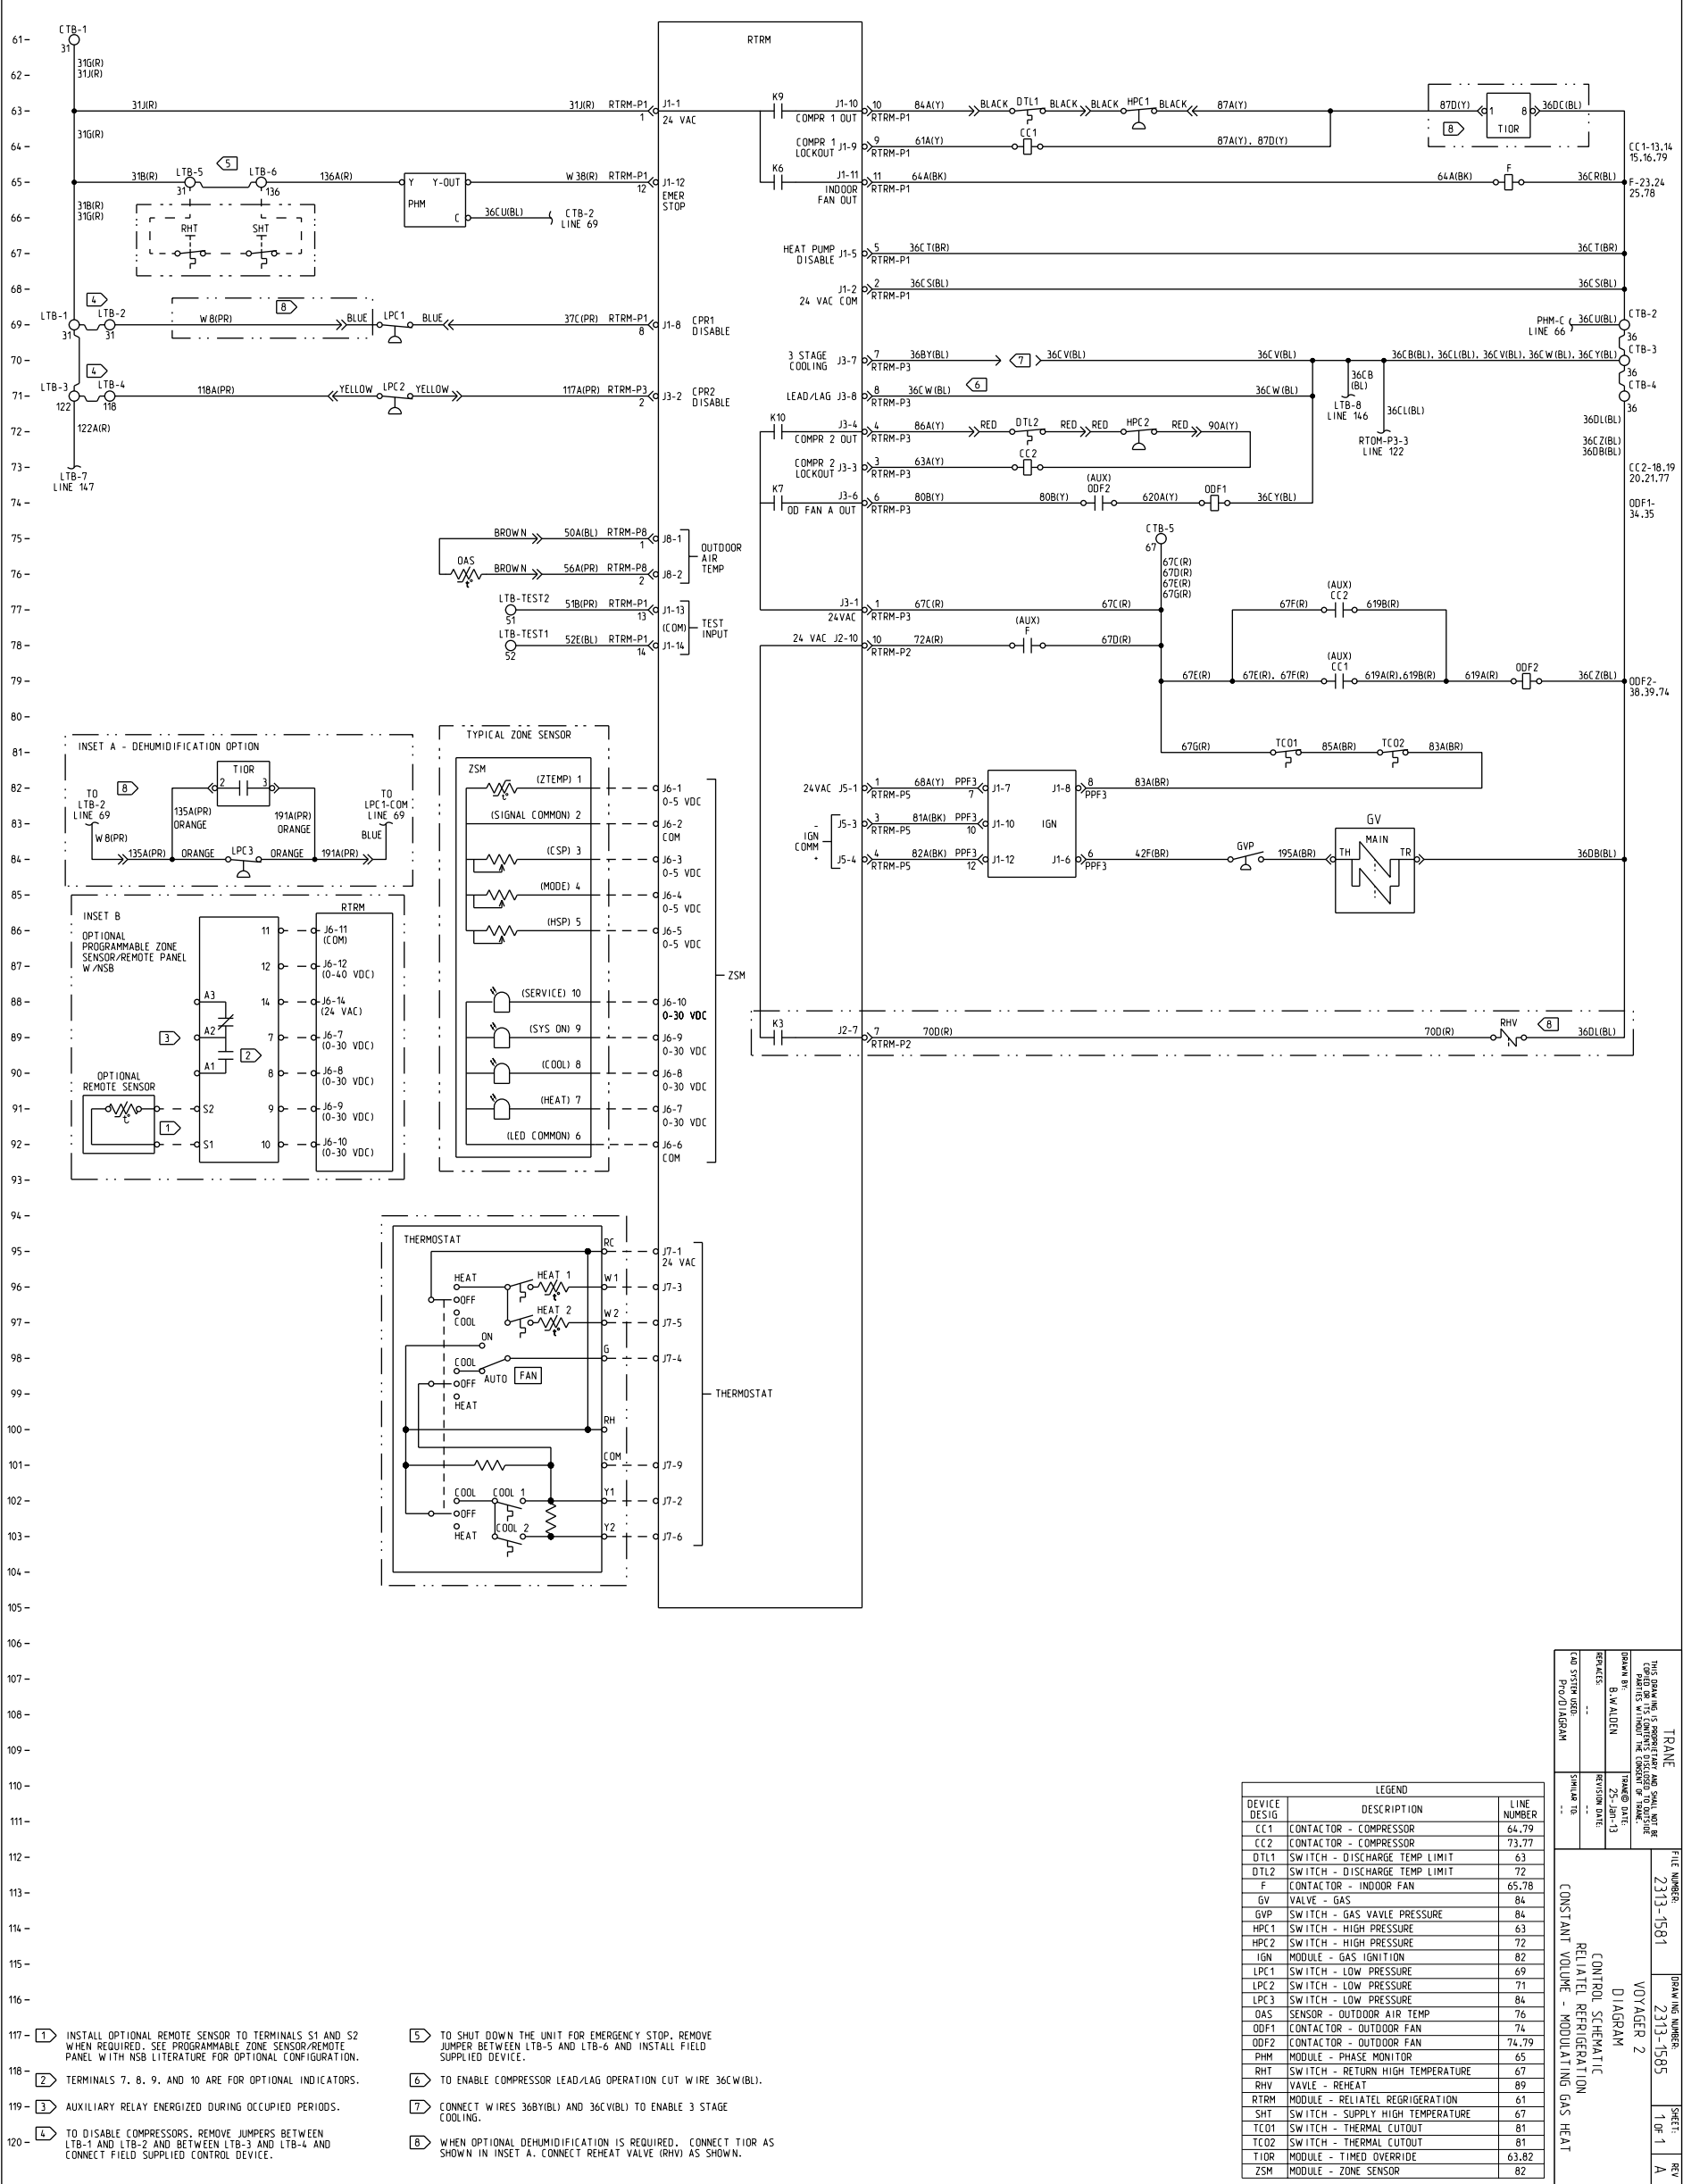

TRAINING		FILE NUMBER	2313-1581	DRAWING NUMBER	2313-1585	SHEET	1 OF 1	REV	A
THIS DRAWING IS A PART OF THE TRAINING PACKAGE. IT IS NOT TO BE USED FOR ANY OTHER PURPOSE. THE USER OF THIS DRAWING IS RESPONSIBLE FOR THE CORRECTNESS OF THE INFORMATION CONTAINED HEREIN.		DRAWN BY: B. W. ALLEN CHECKED BY: J. S. ALLEN DATE: 12/13/11 PROJECT: HVAC SYSTEMS SHEET NO: 1							CONTROL SCHEMATIC RELIATEL REFRIGERATION CONSTANT VOLUME - MODULATING GAS HEAT