


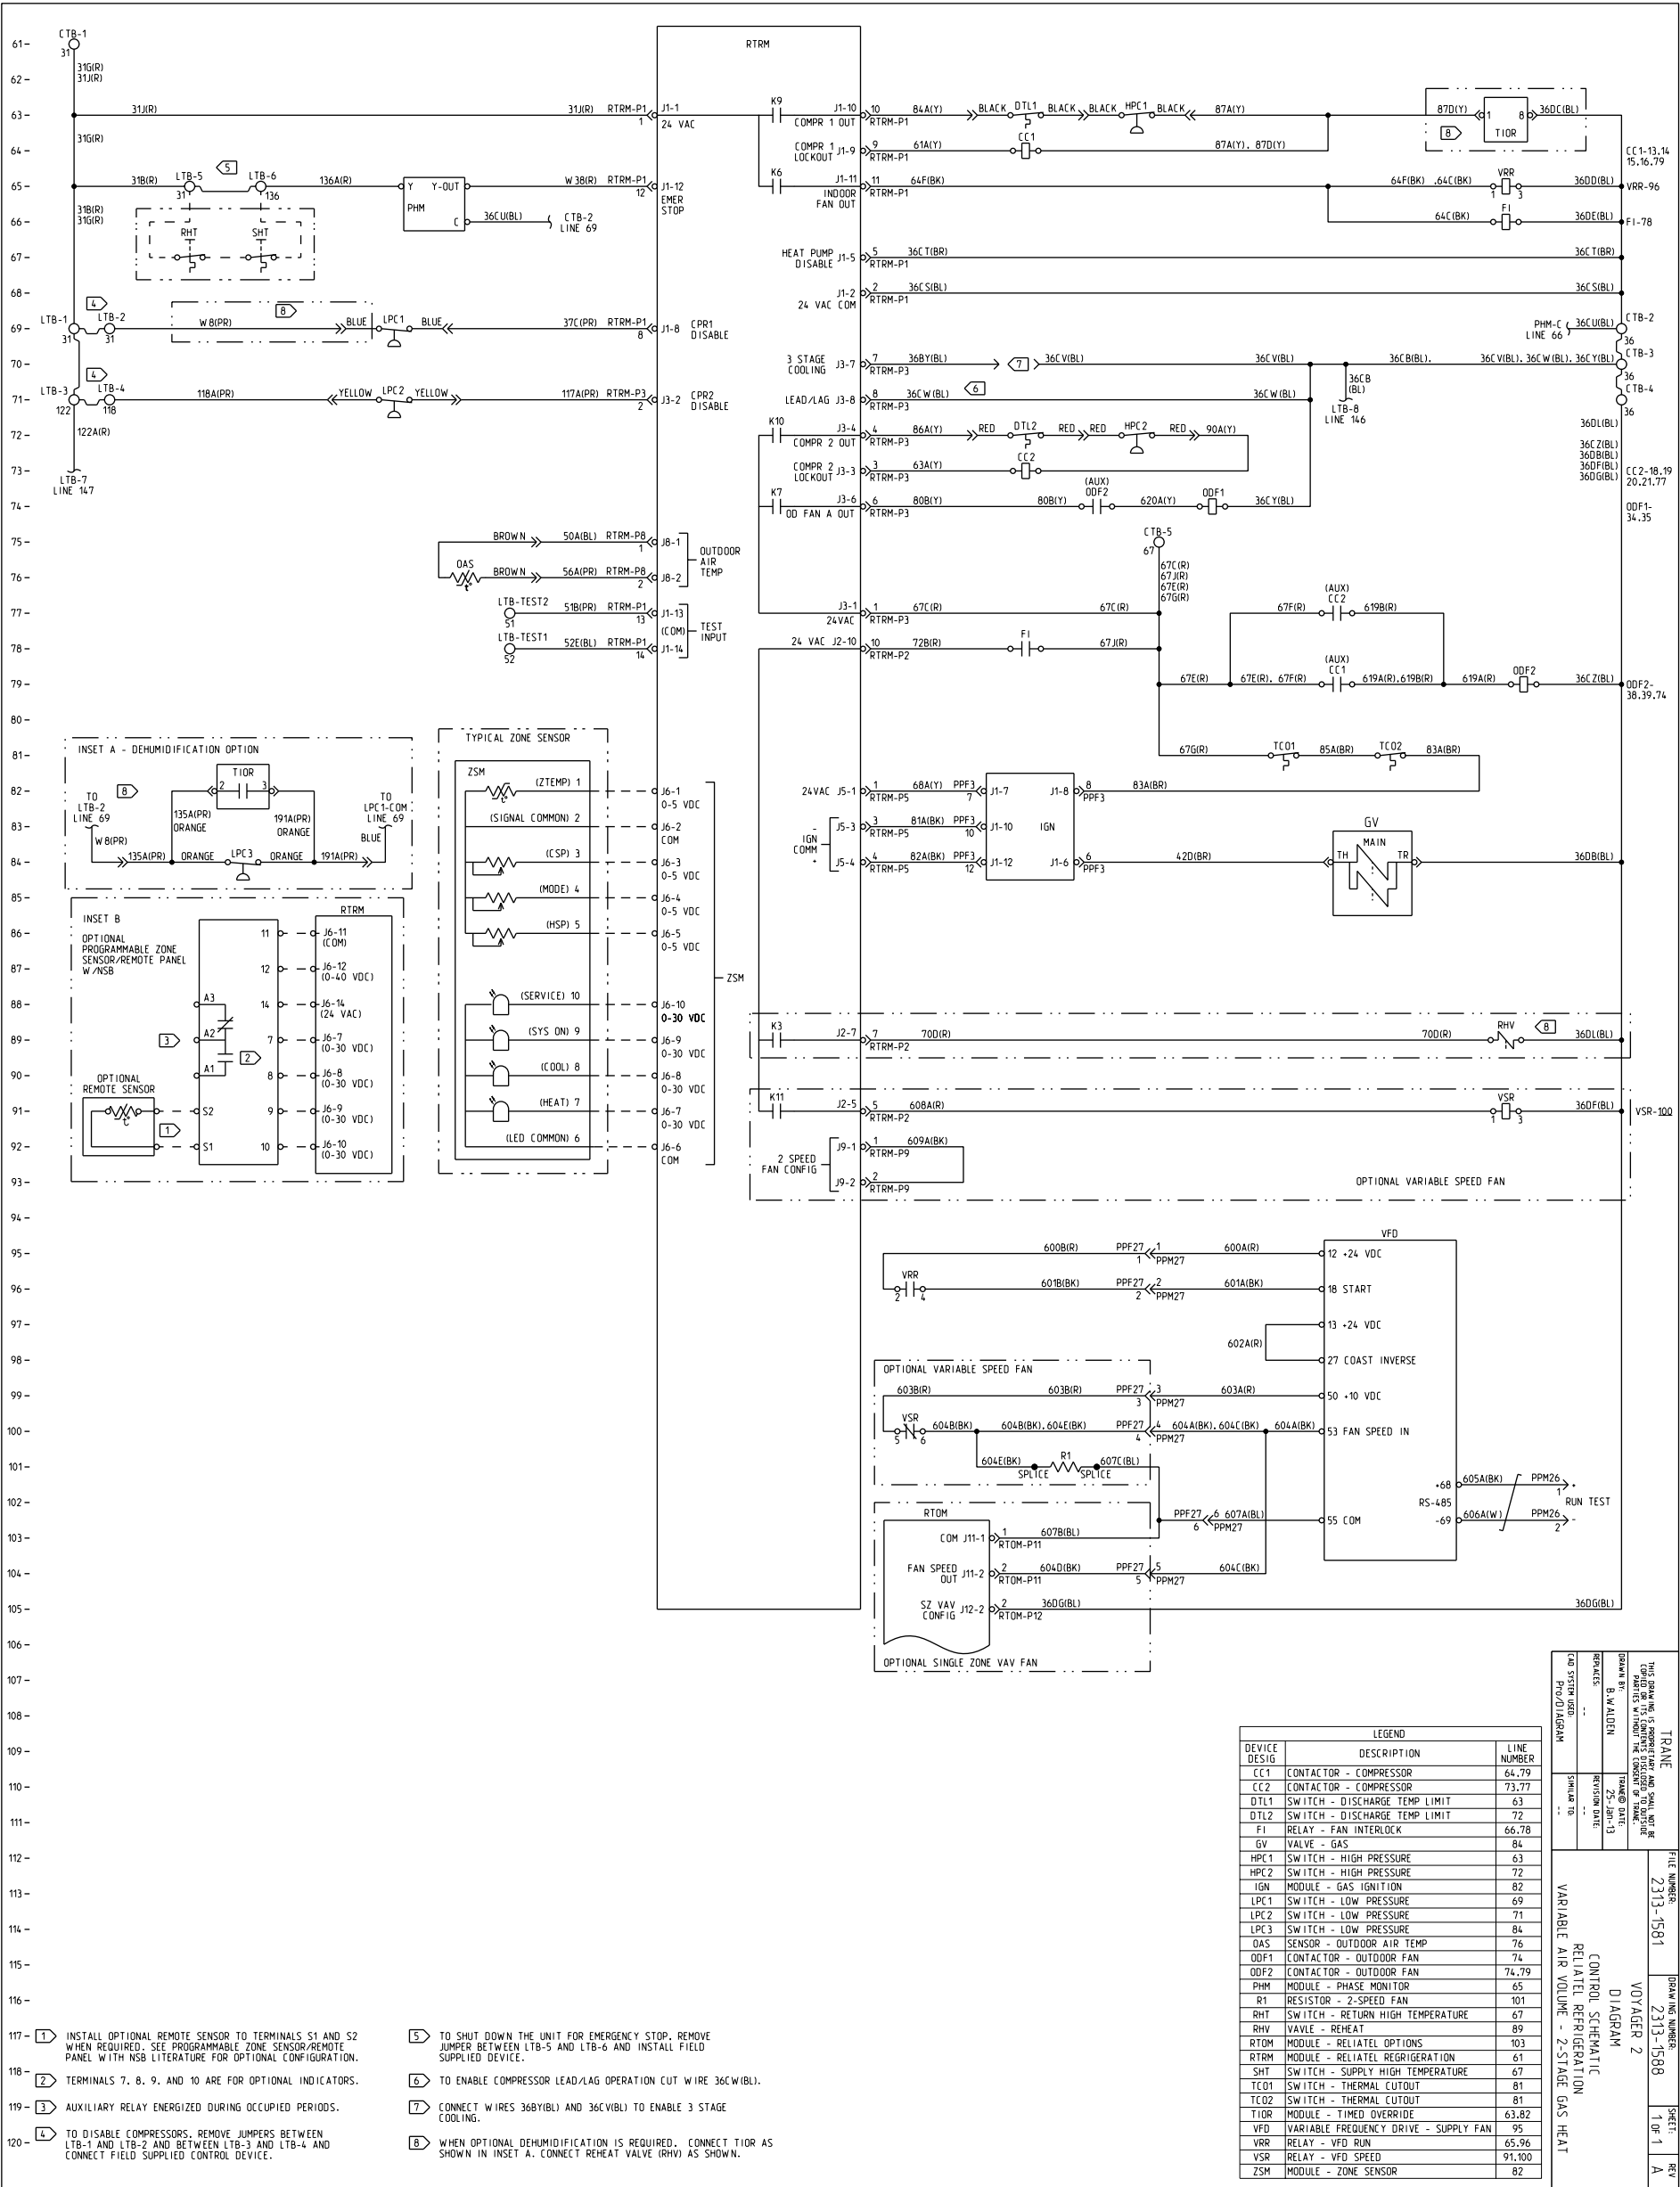

DEVICE DESIG	DESCRIPTION	LINE NUMBER
CC1	CONTACTOR - COMPRESSOR	64.79
CC2	CONTACTOR - COMPRESSOR	73.77
DTL1	SWITCH - DISCHARGE TEMP LIMIT	63
DTL2	SWITCH - DISCHARGE TEMP LIMIT	72
F1	RELAY - FAN INTERLOCK	66.78
GV	VALVE - GAS	84
HPC1	SWITCH - HIGH PRESSURE	63
HPC2	SWITCH - HIGH PRESSURE	72
IGN	MODULE - GAS IGNITION	82
LPC1	SWITCH - LOW PRESSURE	69
LPC2	SWITCH - LOW PRESSURE	71
LPC3	SWITCH - LOW PRESSURE	84
OAS	SENSOR - OUTDOOR AIR TEMP	76
ODF1	CONTACTOR - OUTDOOR FAN	74
ODF2	CONTACTOR - OUTDOOR FAN	74.79
PHM	MODULE - PHASE MONITOR	65
R1	RESISTOR - 2-SPEED FAN	101
RHT	SWITCH - RETURN HIGH TEMPERATURE	67
RHV	VALVE - REHEAT	89
RTOM	MODULE - RELIATEL OPTIONS	103
RTRM	MODULE - RELIATEL REFRIGERATION	61
SHT	SWITCH - SUPPLY HIGH TEMPERATURE	67
TCO1	SWITCH - THERMAL CUTOFF	81
TCO2	SWITCH - THERMAL CUTOFF	81
TIOR	MODULE - TIMED OVERRIDE	63.82
VFD	VARIABLE FREQUENCY DRIVE - SUPPLY FAN	95
VRR	RELAY - VFD RUN	65.96
VSR	RELAY - VFD SPEED	91.100
ZSM	MODULE - ZONE SENSOR	82

THIS DRAWING IS THE PROPERTY OF TRANE. IT IS TO BE USED FOR THE PROJECT AND NOT TO BE REPRODUCED OR COPIED IN ANY MANNER WITHOUT THE WRITTEN CONSENT OF TRANE.	DATE: 2/23/2013	BY: B. W. ALLEN	PROJECT: 2313-1581	FILE NUMBER: 2313-1581	DRAWING NUMBER: 2313-1588	SHEET: 1 OF 1	REV: A
CONTROL SCHEMATIC VARIABLE AIR VOLUME - 2-STAGE GAS HEAT							